
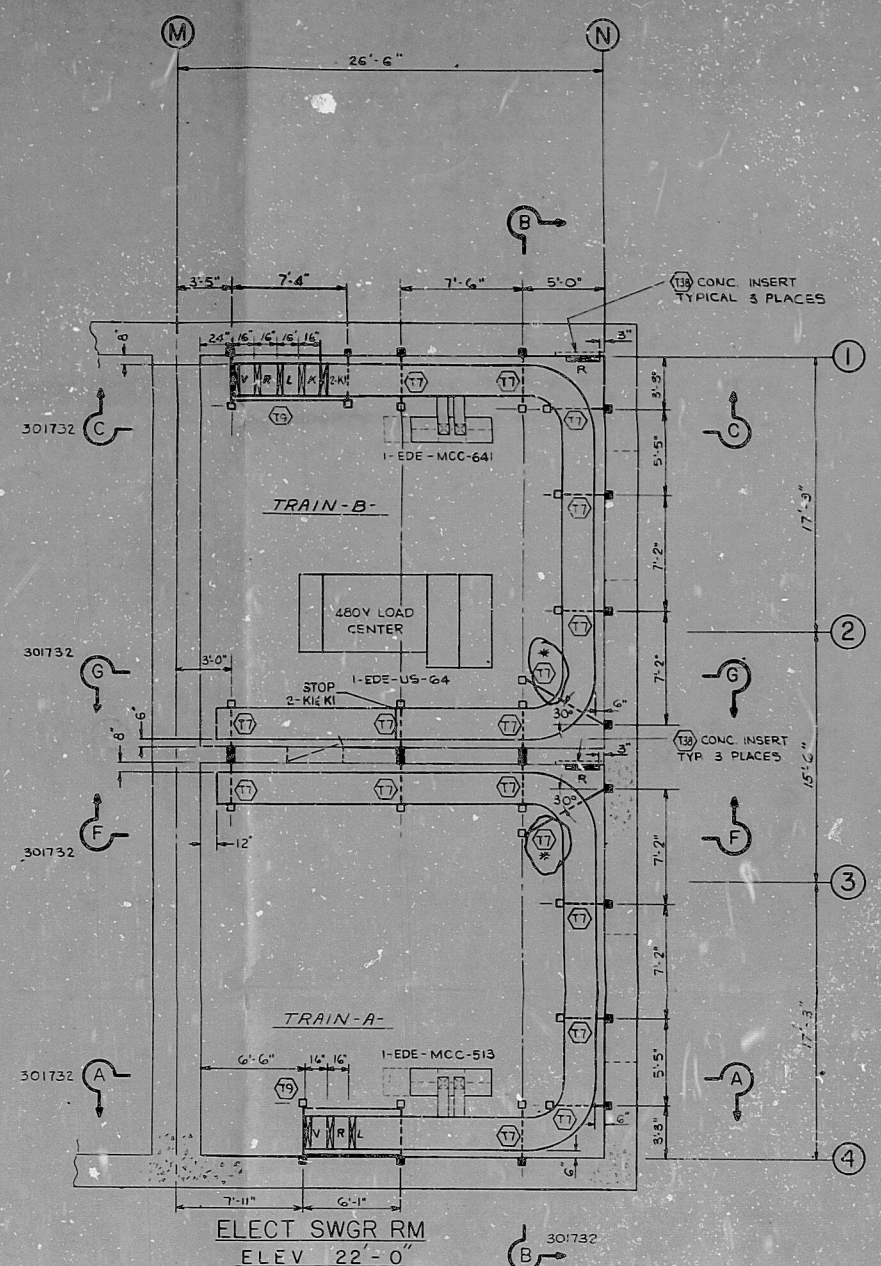


161108-2-301731

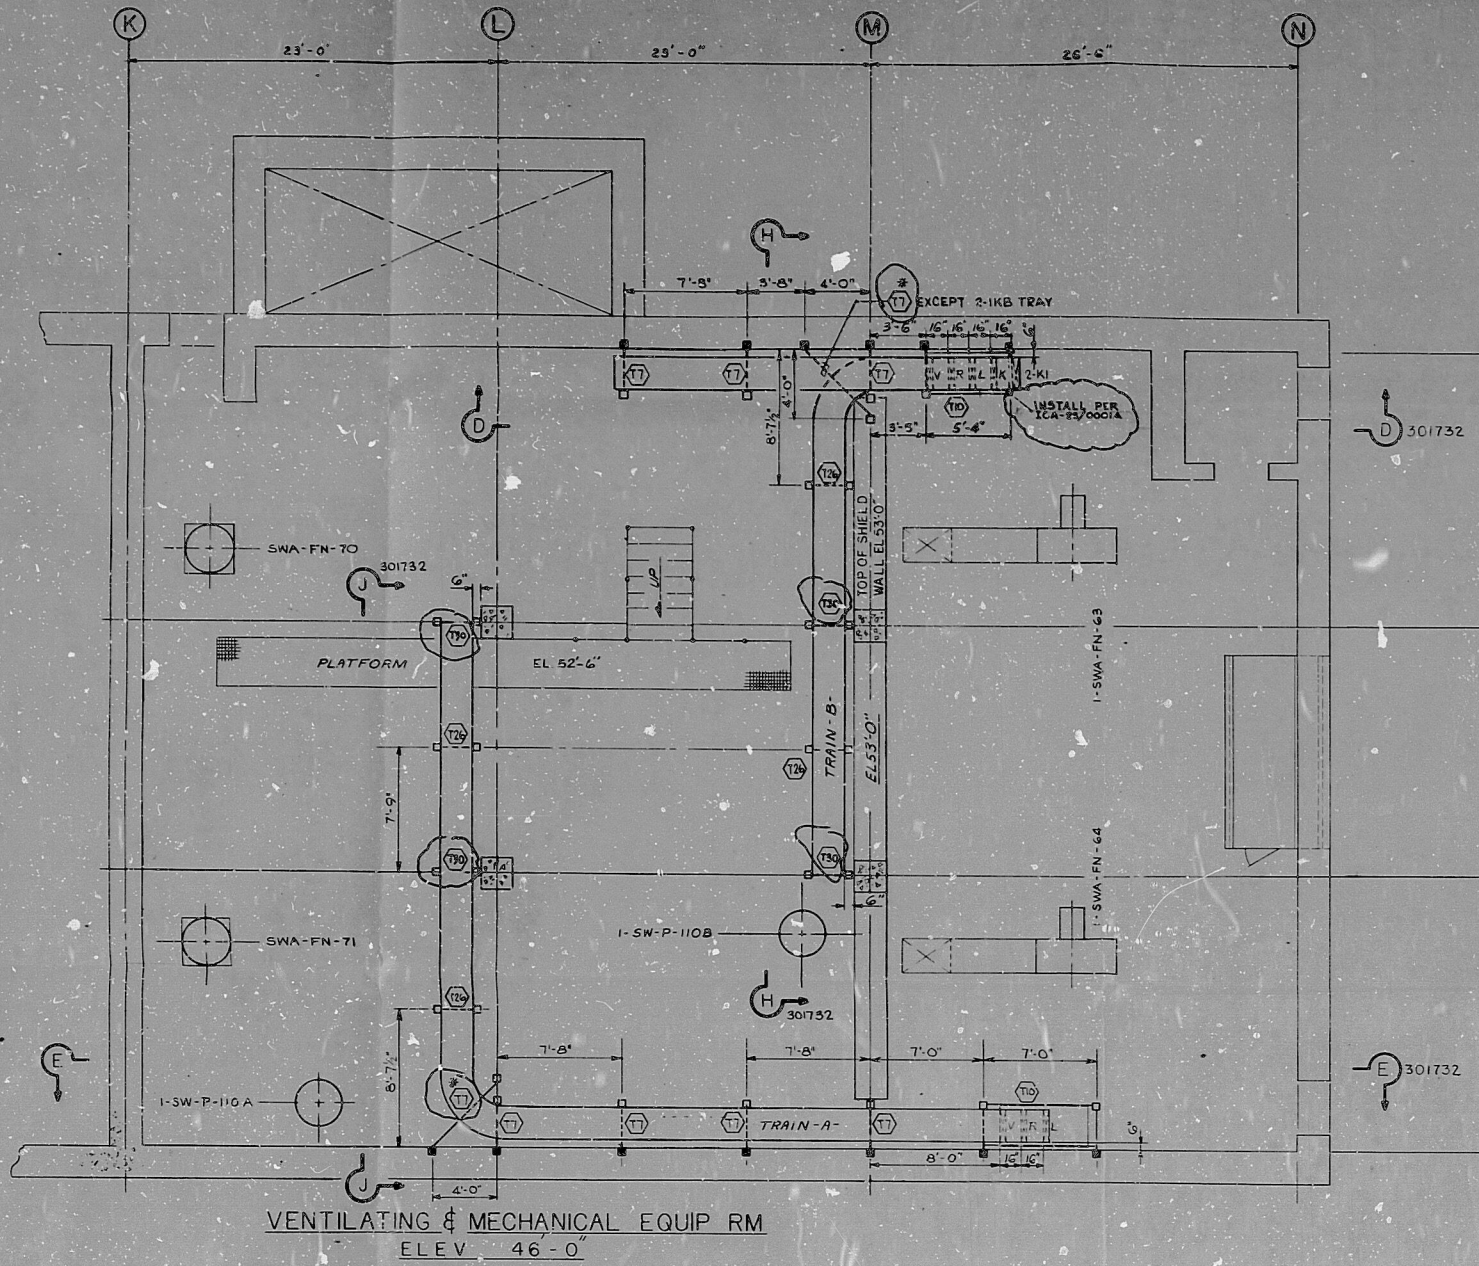

REFERENCE DRAWINGS

ELECTRICAL

M-300229 - CABLE TRAY SYSTEMS, NOTES & TYPICAL DETAILS
M-300226 - GROUNDING SYSTEM NOTES & TYPICAL DETAILS
F-301736 - COOLING TOWER WEST CABLE TRAY PLAN
F-301732 & F-301737 - CABLE TRAY SECTIONS
F-301711 & F-301712 - GEN. ARRGT, EMBEDDED CONDUIT & GROUNDING

MECHANICAL SERVICES

F-604139 - VENTILATION & DRAINAGE PLAN

INSTRUMENTATION

F-500208 - INST. PIPING

STRUCTURAL

F-101701 THRU F-101710 - CONCRETE PLANS & DETAILS
F-101711 - STRUCTURAL STEEL FRAMING
F-104115 - EMBEDMENTS EL 22'-0" & 46'-0"

NUCLEAR

F-805068 - TOWER GENERAL ARRGT
F-805100 - PIPING DWG.

NOTE:

1. FOR CABLE TRAY SYSTEM NOTES AND TYPICAL DETAILS WITH BILL OF MATERIAL ITEMS SEE M-300229.
2. PREFIX '2' INDICATES UNIT 2 EQUIPMENT IN UNIT 1 AREA.
3. * SPAN ON HORIZONTAL MEMBERS GREATER THAN 48' APPROVED BY ANALYSIS.

TERA
APERTURE
CARD

NUCLEAR SAFETY RELATED

REV	DATE	DESCRIPTION	BY	CHKD
1	10/26/77	REVISED AS NOTED	RRC	AC
2	10/26/77	FIRST ISSUE	DF	AC
3	10/26/77	ADDED SECT'S F.C.H.4.3	DF	AC
4	10/26/77	REV. 'KA' & 'KB' TRAY	JD	AC
5	10/26/77	REV. 'KA' TRAY	JD	AC
6	10/26/77	ADDED K2 TRAY TO 5 TRAIN	JD	AC
7	10/26/77	ADDED CABLE TRAY SUPPORTS	JD	AC
8	10/26/77	ISSUED FOR CONSTRUCTION	JD	AC

DISCIPLINE	COO	DATE	DISCIPLINE	COO	DATE
STRUCT.	WLP	10/26/77	INST. & CONTR.	WLP	10/26/77
MECH.	WLP	10/26/77	ELECT.	WLP	10/26/77
NUCLEAR	WLP	10/26/77	WATER	WLP	10/26/77

COOLING TOWER EAST
CABLE TRAY LAYOUT - PLAN

PUBLIC SERVICE CO. OF NEW HAMPSHIRE
SEABROOK STATION

UNITS 1 AND 2 9763-F-301731

SCALE 1/4" = 1'-0"

PDR

811190441

