


- NOTES:
1. SCALE: 1"=40'
 2. GRID COORDINATE VALUES ARE BASED ON A BASELINE SYSTEM ESTABLISHED FOR UNIT 1 (SEE EASCO DWG G-187464)
 3. SURFACE CONTOURS ARE FROM TOPOGRAPHICAL MAP OF MILLSTONE POINT BY KRATZERT & JONES, LAND SURVEYORS, MILLDALE, CONN., DATED AUG. 1973, AND REVISED OCT. 1, 1973.
 4. ELEVATIONS SHOWN ARE BASED ON MSL DATUM (10.00)
 5. ROAD CROSS SECTION (SEE DWG EY-80 (11011))
 6. ROAD PROFILES (SEE DWG EY-80 (11011))
 7. SIDE SLOPES ARE 3:1 UNLESS OTHERWISE NOTED.
 8. C/PVE DATA TABLE (SEE DWG EY-80 (11011))
 9. LOCATION OF ALL EXISTING UTILITIES SHOULD BE REGARDED AS APPROXIMATE AND THE EXACT LOCATION IS TO BE DETERMINED IN THE FIELD.
 10. AT ROAD INTERSECTIONS, THE RAD OF CURVATURE OF THE PAVEMENT SHALL BE 25.00 (UOS)

- LEGEND:
- 20- EXISTING GROUND CONTOUR
 - 20- PROPOSED GROUND CONTOUR
 - MANHOLE WITH GRATED COVER
 - MANHOLE WITH SOLID COVER
 - SMH SENER MANHOLE
 - DMH DRAIN MANHOLE
 - INV ELEVATION OF INVERT OF PIPE
 - R-22.00 RIM ELEVATION OF MANHOLE
 - RADIUS
 - C W CIRCULATING WATER PIPE
 - E ELECTRIC DUCT
 - RTL RECIRCULATING TEMP LINE
 - S W SERVICE WATER PIPE
 - H P HIGH POINT
 - INLET BASIN (IB)
 - CONC PAD
- REFERENCE DRAINAGES:
- EXISTING XFMR TMS & ELEC M'S
- A.) EASCO SERVICES DWG NO G187902 DATED AUG 17, 1967
- B.) BECHTEL CORP DWG NO 25204-33803 DATED APRIL 23, 1971
- EXISTING SEWAGE FACILITIES, NUSCO DWG NO 25203-1220
- SITE PLAN
- PLOT PLAN
- C W DISCHARGE TUNNEL
- RAILROAD PLAN
- BACKFILL PLAN & DETAILS
- OUTFALL STRUCTURE
- YARD STORM & SANITARY SENSORS
- YARD WATER & FIRE PROTECTION
- ELEC DUCT LINES
- ARRANGEMENT-TRANSFORMER AREA
- CIRC WATER & RECIRC WATER PIPING
- SERVICE WATER
- FDN MN XFMR YARD
- ET-24 (11001)
- EX-1A (10002)
- EX-4C (11005)
- EX-4A (11007)
- EX-12A (11512)
- EX-17A (11393)
- EX-1 SERIES (25001 ETC)
- EX-2 SERIES (25004 ETC)
- EX-32 SERIES (33058 ETC)
- EX-30 SERIES (33054 ETC)
- EX-1 SERIES (20404 ETC)
- EX-15 SERIES (21041 ETC)
- EX-21A (11365)

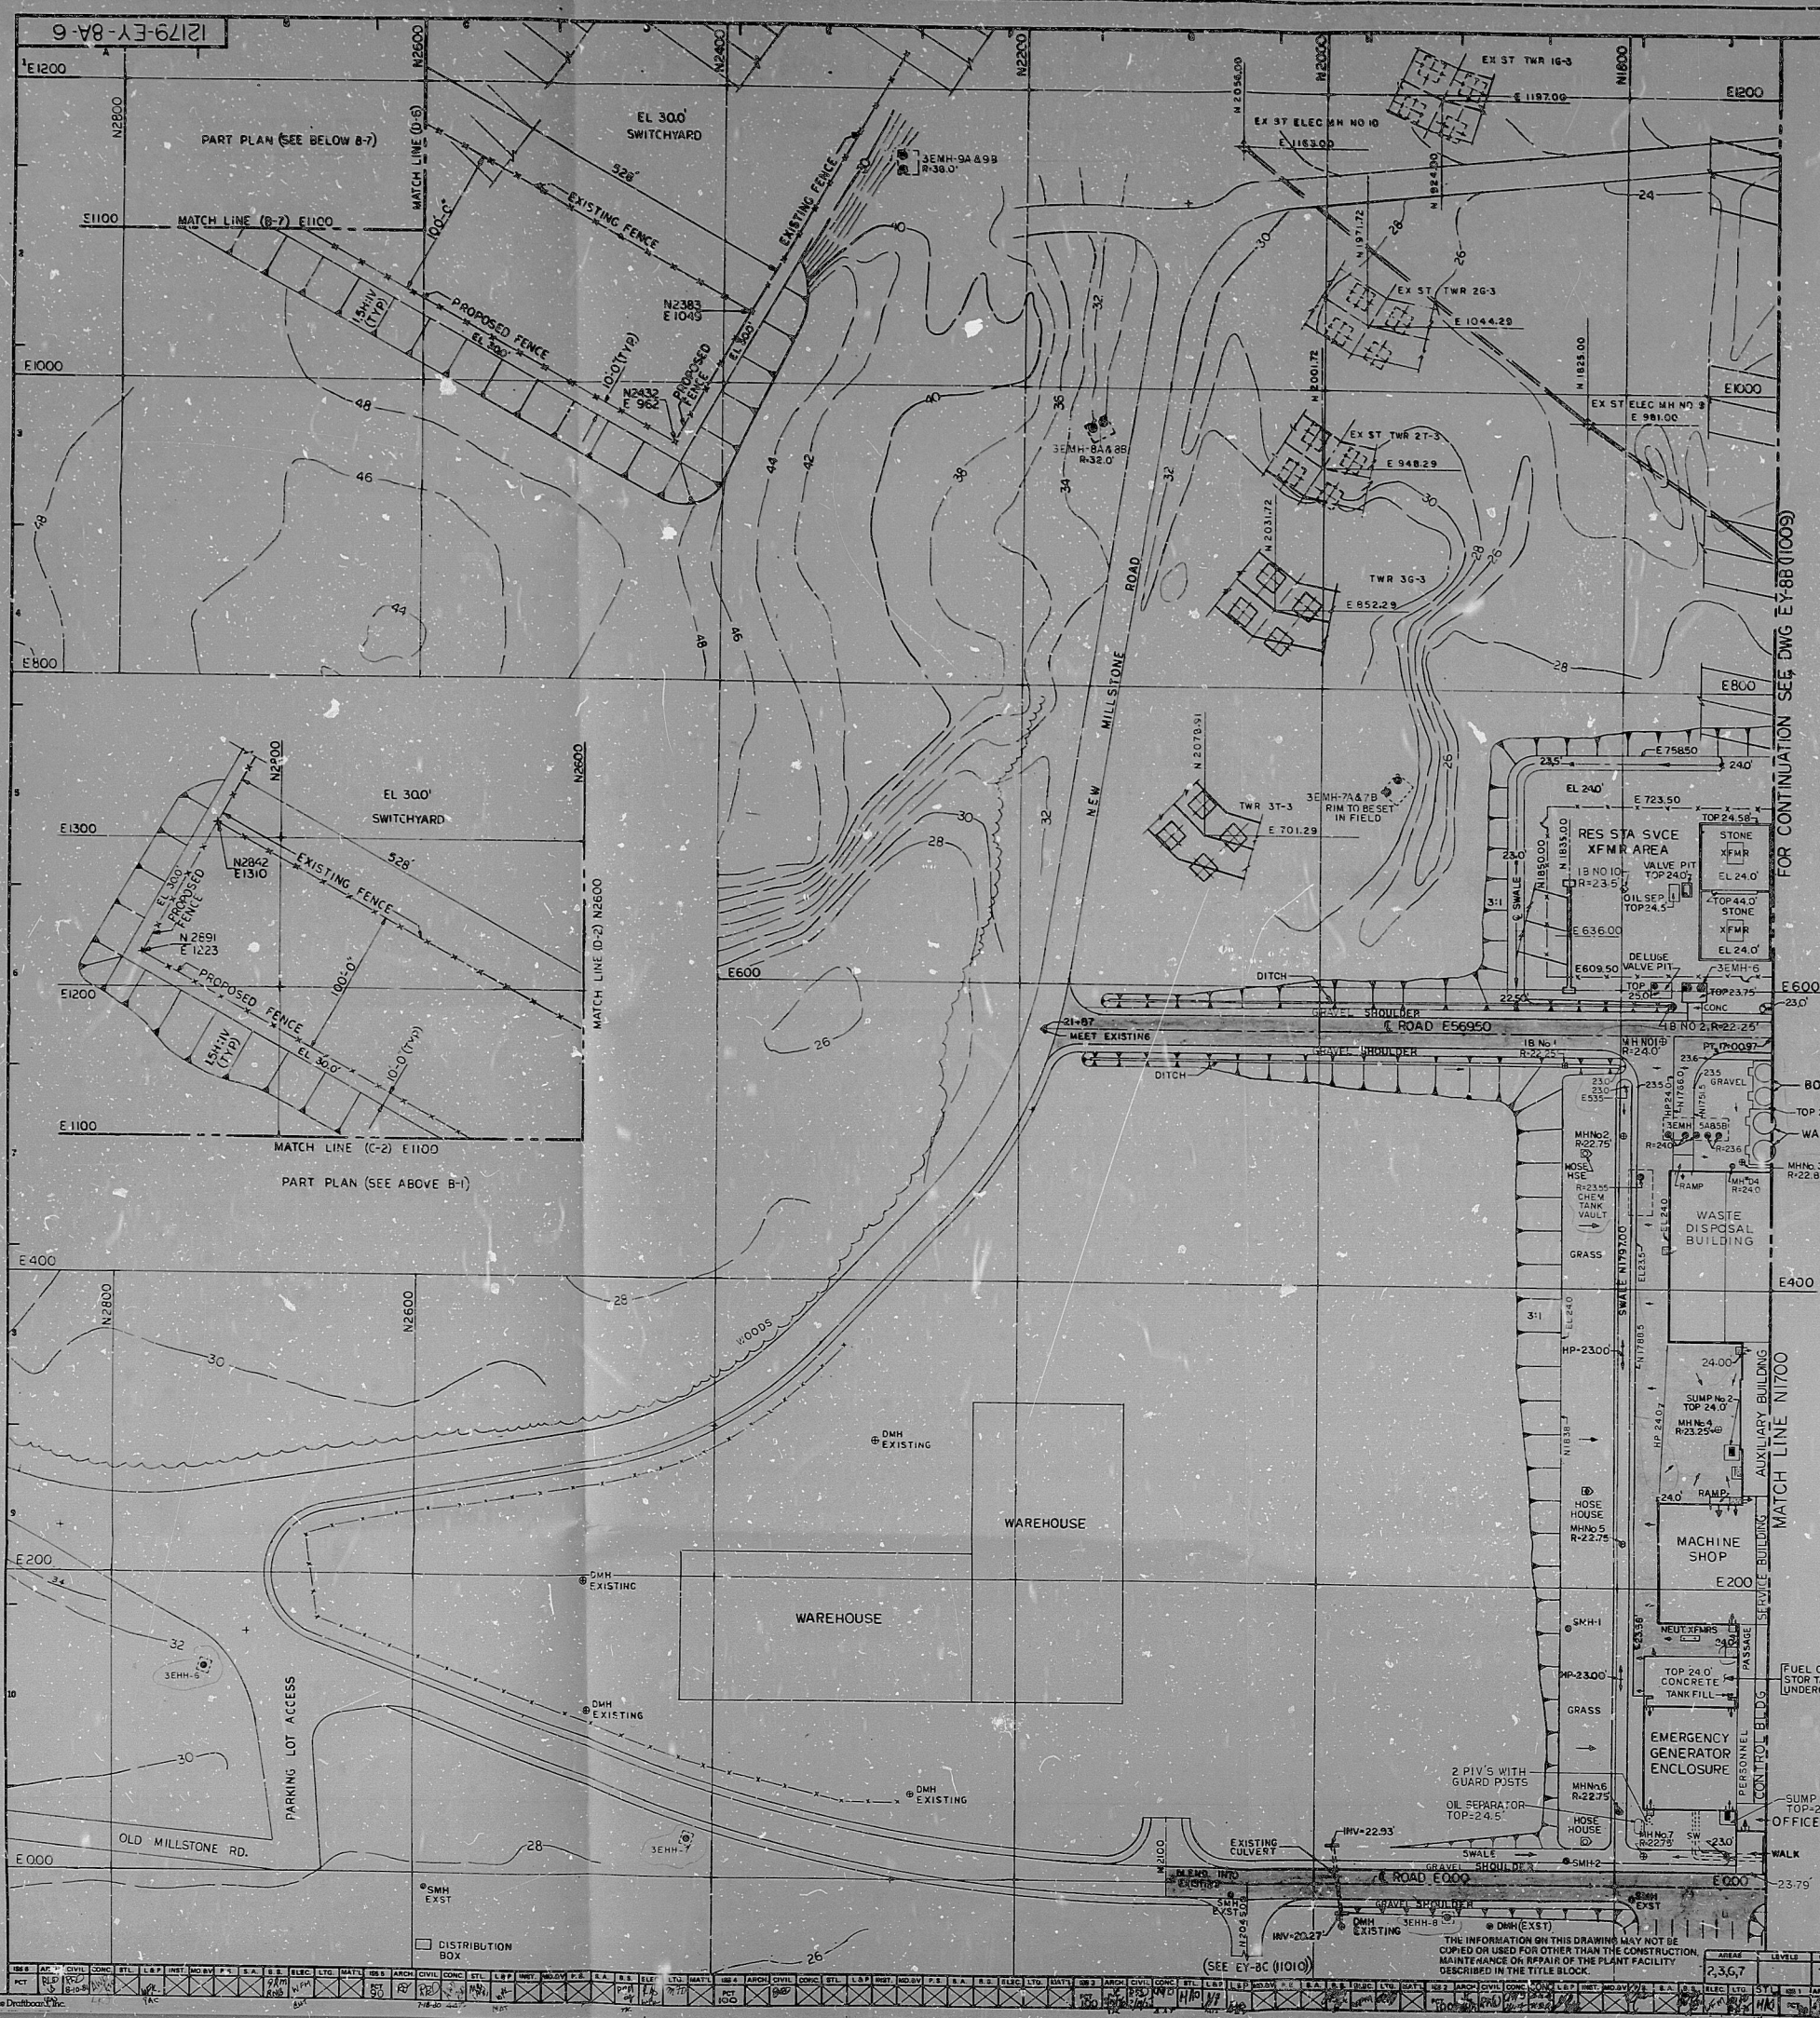

APPROVED: *R. W. Leighton*

REGISTERED PROFESSIONAL ENGINEER, NO. 12179

DATE: 12/27/75

PROJECT: MILLSTONE NUCLEAR POWER STATION-UNIT NO. 3

FINISHED GRADING, ROADS AND WALKWAYS-SHEET 1

DATE: 12/27/75

SCALE: 1"=40'

PROJECT NO. 25212-11008

STONE & WEBSTER ENGINEERING CORPORATION

BOSTON, MASS. 02114

S & W DWG. NO. 12179-EY-8A-6

DRAWN BY: R. C. GRANT & R. W. LEIGHTON

CHECKED BY: R. E. DONOVAN

ITERA APERTURE CARD

QA CAT III

REV	DATE	DESCRIPTION	BY	CHK	APP
1					
2					
3					
4					
5					
6					
7					
8					
9					
10					

THE MILLSTONE POINT COMPANY

SUBSIDIARY OF

NORTHEAST UTILITIES

REVISIONS DURING CONSTRUCTION

P.A. 10 71-158

RIDS

8111300421

