


08031-M-75FD

SIZE E

REF
C
(75-2)

TURBINE ENCLOSURE FAN CABINET UNIT COOLERS 1RV133 (TYPT 2)

NOTES:
1. THIS FUNCTIONAL DESCRIPTION DRAWING IS BASED ON P & ID M-75, SHT 1, REV. 1, SHT 2, REV. 1

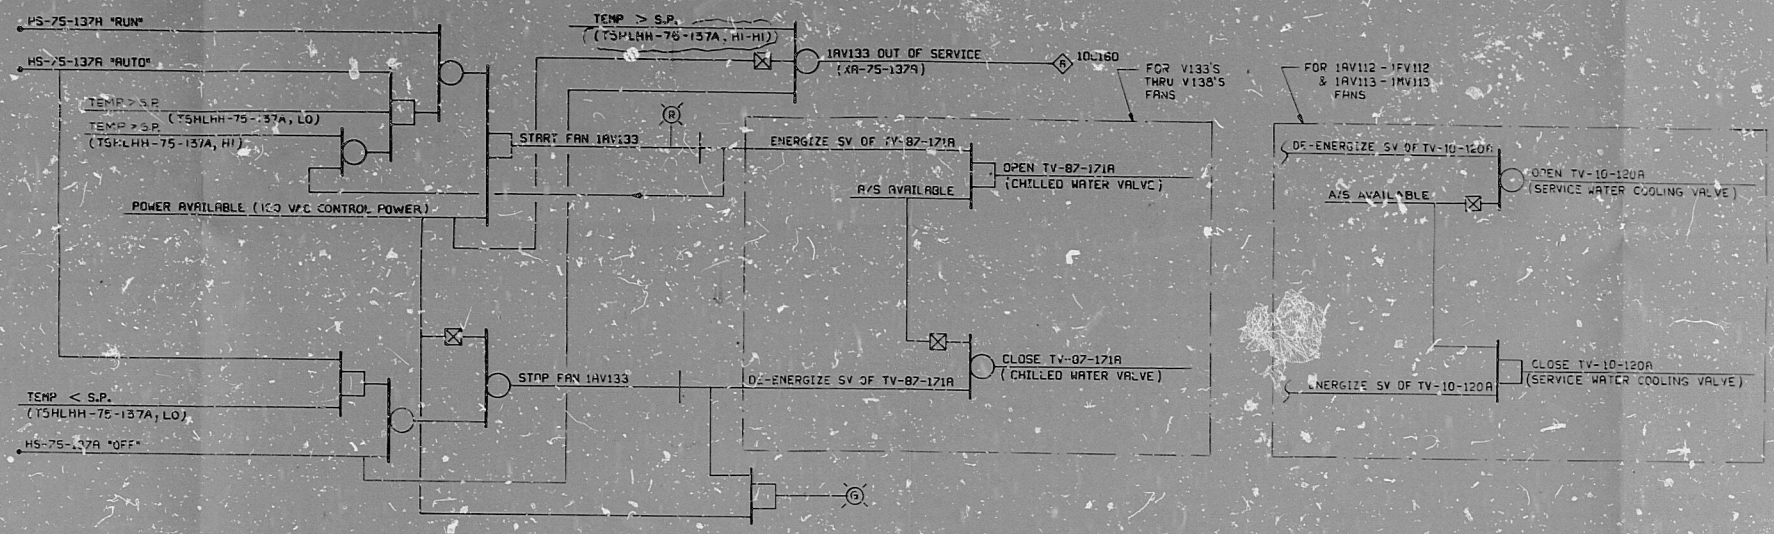


FAN CABINETS	INSTRUMENT NUMBERS					PANEL
	IS-	TAL-	TSHLHH	YR-	TV-	
1RV133 TO 1RV134		75-137A TO F			87-171A TO F	10C150
1RV134 TO 1RV135		75-138A TO J			87-171A TO J	10C151
1RV135 TO 1RV136		75-176A TO D			87-171A TO D	10C152
1RV136 & 1RV137		75-176A & B			87-181A & B	10C153
1RV137 & 1RV138		75-177A & B			87-179A & B	10C154
1RV138 & 1RV139		75-138A TO J			87-175A TO J	10C155
1RV139 TO 1RV140		75-124A TO F			10-120A TO F	10C156
1RV140 TO 1RV141		75-127A TO M			10-127A TO M	10C157




REF
D
(75-3)

TURBINE ENCLOSURE EQUIPMENT COMPARTMENT EXHAUST FILTER ASSEMBLY

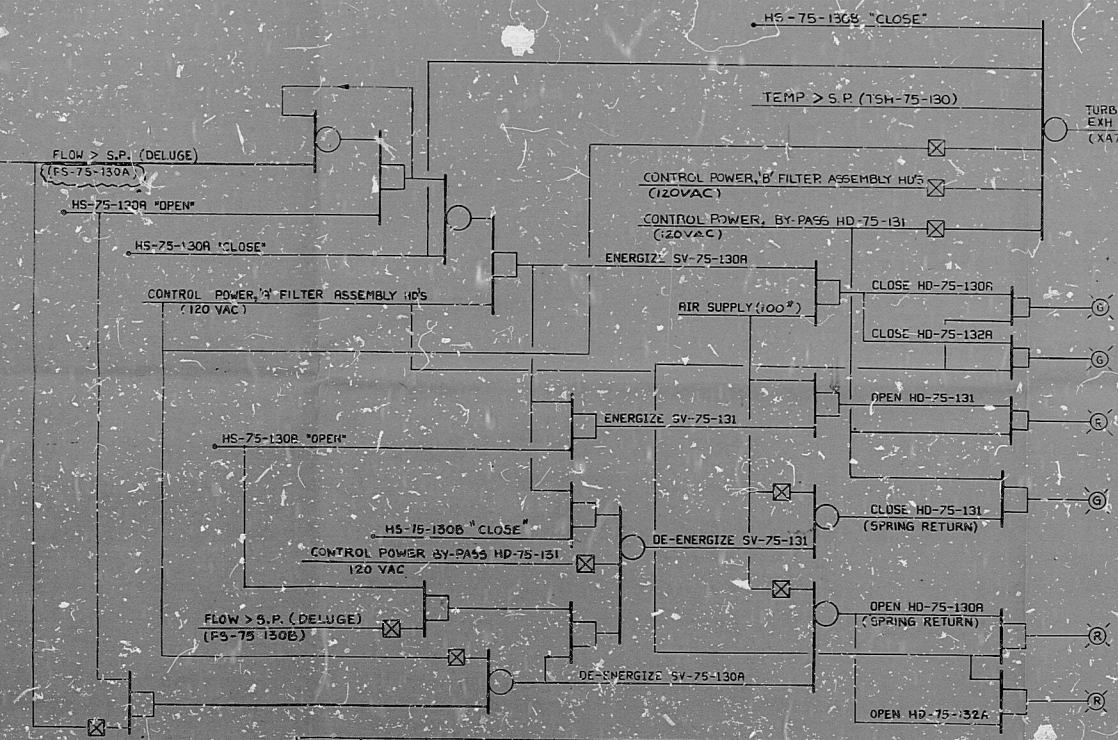

FILTER UNIT	PDH-	PDISH-	PS-	HD-	HS-	SV-	HS-	HD-	TAH-	TAHH-	TAHHH-	TSH-	TSHH-	TSHHH-	PANEL
A	75-129A			75-130A			75-130B	75-132A				75-136A			10C158
C	75-129B			75-130B			130A	75-132B				75-136B			10C159

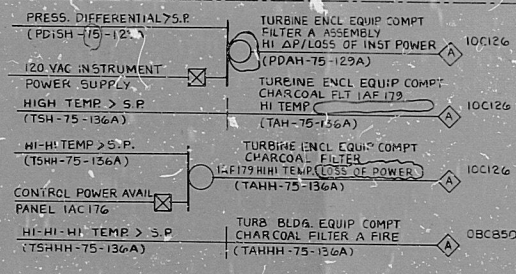

REFERENCE SCHEMATIC DRAWINGS		
REF NO.	DWG NO.	TITLE
C	E455	TURBINE ENCLOSURE H & V UNIT COOLERS - UNITS 1 & 2
D	E452	TURBINE ENCLOSURE EQUIPMENT COMPARTMENT EXHAUST AIR FILTER ASSEMBLY - UNITS 1 & 2

REVISION	DATE	BY	CHKD	APPD
1	10/1/75	J. J. J.	J. J. J.	J. J. J.
2	10/1/75	J. J. J.	J. J. J.	J. J. J.
3	10/1/75	J. J. J.	J. J. J.	J. J. J.
4	10/1/75	J. J. J.	J. J. J.	J. J. J.
5	10/1/75	J. J. J.	J. J. J.	J. J. J.
6	10/1/75	J. J. J.	J. J. J.	J. J. J.
7	10/1/75	J. J. J.	J. J. J.	J. J. J.
8	10/1/75	J. J. J.	J. J. J.	J. J. J.
9	10/1/75	J. J. J.	J. J. J.	J. J. J.
10	10/1/75	J. J. J.	J. J. J.	J. J. J.

BECHTEL
SAN FRANCISCO
LIMERICK GENERATING STATION UNITS 1 & 2
PHILADELPHIA ELECTRIC COMPANY

FUNCTIONAL DESCRIPTION
TURBINE ENCLOSURE - HVAC

JOB NO.	DRAWING NO.	SHT	REV.
8031	M-75FD	3	

REF. C, D

PDR RIDS

8405310110

