


FUEL HANDLING FLOOR EL. 426'0"

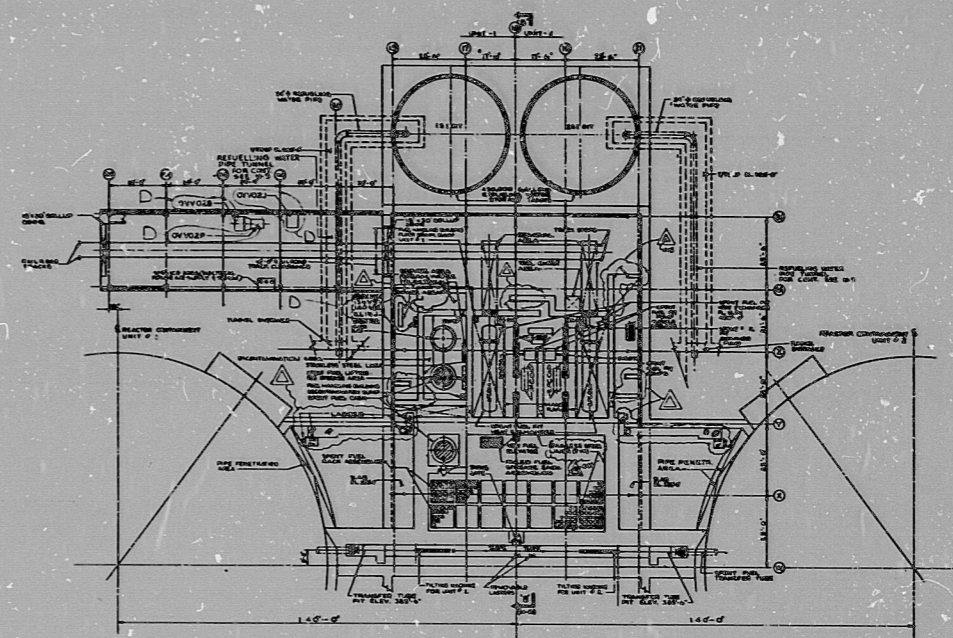

GROUND FLOOR PLAN EL. 401'0"

PRC
APERTURE
CARD



NUCLEAR SAFETY RELATED
ITEMS ARE SHOWN ON THIS DRAWING
FOR SAFETY CLASSIFICATION SEE (CC-ME-01-01)

NO.	DATE	BY	REVISION
1	11-18-78	J. M. ...	RECORD DRAWING, REVISION UPDATE

NO.	DATE	BY	REVISION
1	11-18-78	J. M. ...	RECORD DRAWING, REVISION UPDATE

REV.	DATE	RELD.	PREPARED	REVIEWED	APPROVED	PURPOSE
B	8-11-78		Robert	SYSTEM REV. D. 1.16-78 FOR PSI INFORMATION
D	8-20-79		FOR INFORMATION PER SPEC. Y-2730 & Y-2773A
C	11-8-79		FOR INFORMATION PER SPEC. Y-2730 & Y-2773A
D	12-14-81		FOR INFORMATION PER SPEC. Y-2730 & Y-2773A

REV.	DATE	RELD.	PREPARED	REVIEWED	APPROVED	PURPOSE
B	8-11-78		Robert	SYSTEM REV. D. 1.16-78 FOR PSI INFORMATION
D	8-20-79		FOR INFORMATION PER SPEC. Y-2730 & Y-2773A
C	11-8-79		FOR INFORMATION PER SPEC. Y-2730 & Y-2773A
D	12-14-81		FOR INFORMATION PER SPEC. Y-2730 & Y-2773A

UNIQUE FEATURES TAG

THIS ATTACHED TO AN ENCLOSED AREA OF THIS DRAWING INDICATES A UNIQUE FEATURE FOR MARBLE HILL STATION

SCALE: 1/4" = 1'-0"

PROJECT NUMBER: 430900

DATE: 4/23/80

GENERAL ARRANGEMENT FUEL HANDLING BUILDING MARBLE HILL NUCLEAR GENERATING STATION UNITS 1 & 2 PUBLIC SERVICE INDIANA PLAINFIELD, INDIANA

DRAWING NO. M-13

SHEET 1 OF 1

8305050329

RIDS

