


2-9-EM-1478-2

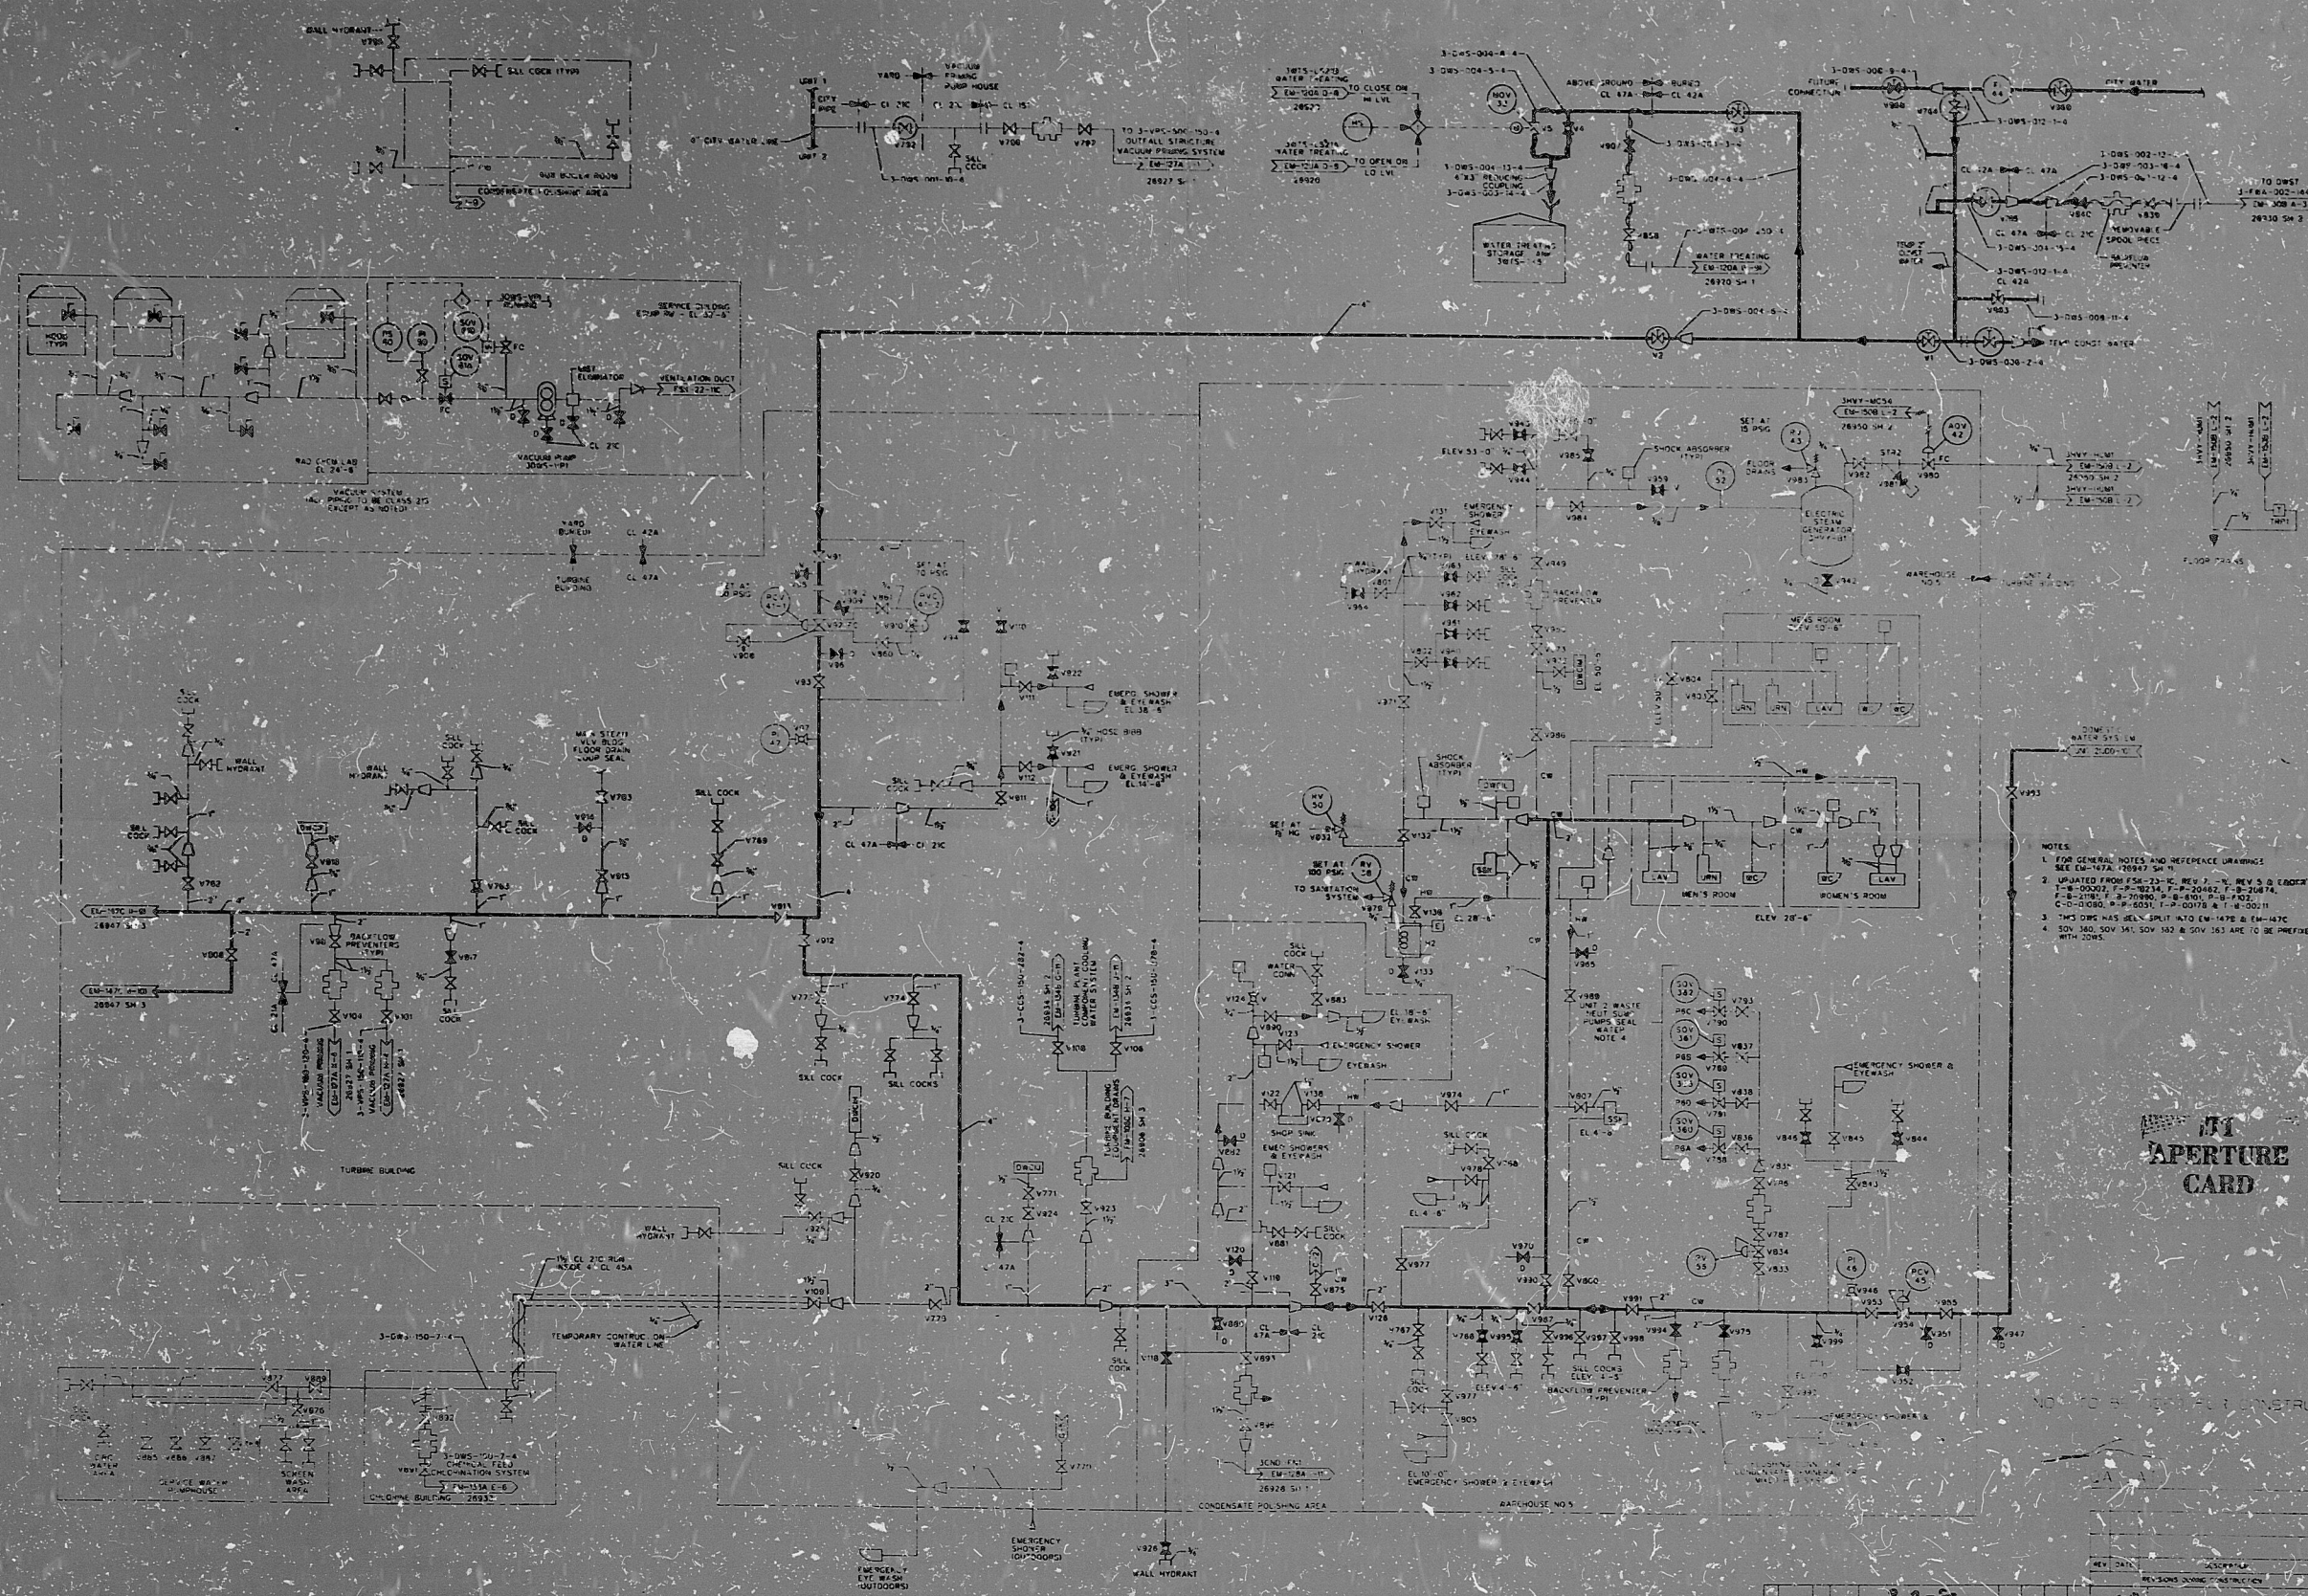

- NOTES
1. FOR GENERAL NOTES AND REFERENCE DRAWINGS SEE EM-1478-1.
 2. UPDATED FROM EM-1478-1, REV. 3, REV. 5 & 6. CHANGES: F-8-1007-A, F-1007-B, F-1007-C, F-1007-D, F-1007-E, F-1007-F, F-1007-G, F-1007-H, F-1007-I, F-1007-J, F-1007-K, F-1007-L, F-1007-M, F-1007-N, F-1007-O, F-1007-P, F-1007-Q, F-1007-R, F-1007-S, F-1007-T, F-1007-U, F-1007-V, F-1007-W, F-1007-X, F-1007-Y, F-1007-Z, F-1007-AA, F-1007-AB, F-1007-AC, F-1007-AD, F-1007-AE, F-1007-AF, F-1007-AG, F-1007-AH, F-1007-AI, F-1007-AJ, F-1007-AL, F-1007-AM, F-1007-AN, F-1007-AO, F-1007-AP, F-1007-AQ, F-1007-AR, F-1007-AS, F-1007-AT, F-1007-AU, F-1007-AV, F-1007-AW, F-1007-AX, F-1007-AY, F-1007-AZ, F-1007-BA, F-1007-BB, F-1007-BC, F-1007-BD, F-1007-BE, F-1007-BF, F-1007-BG, F-1007-BH, F-1007-BI, F-1007-BJ, F-1007-BL, F-1007-BM, F-1007-BN, F-1007-BO, F-1007-BP, F-1007-BQ, F-1007-BR, F-1007-BS, F-1007-BT, F-1007-BU, F-1007-BV, F-1007-BW, F-1007-BX, F-1007-BY, F-1007-BZ, F-1007-CA, F-1007-CB, F-1007-CC, F-1007-CD, F-1007-CE, F-1007-CF, F-1007-CG, F-1007-CH, F-1007-CI, F-1007-CJ, F-1007-CL, F-1007-CM, F-1007-CN, F-1007-CO, F-1007-CP, F-1007-CQ, F-1007-CR, F-1007-CS, F-1007-CT, F-1007-CU, F-1007-CV, F-1007-CW, F-1007-CX, F-1007-CY, F-1007-CZ, F-1007-DA, F-1007-DB, F-1007-DC, F-1007-DD, F-1007-DE, F-1007-DF, F-1007-DG, F-1007-DH, F-1007-DI, F-1007-DJ, F-1007-DL, F-1007-DM, F-1007-DN, F-1007-DO, F-1007-DP, F-1007-DQ, F-1007-DR, F-1007-DS, F-1007-DT, F-1007-DU, F-1007-DV, F-1007-DW, F-1007-DX, F-1007-DY, F-1007-DZ, F-1007-EA, F-1007-EB, F-1007-EC, F-1007-ED, F-1007-EE, F-1007-EF, F-1007-EG, F-1007-EH, F-1007-EI, F-1007-EJ, F-1007-EL, F-1007-EM, F-1007-EN, F-1007-EO, F-1007-EP, F-1007-EQ, F-1007-ER, F-1007-ES, F-1007-ET, F-1007-EU, F-1007-EV, F-1007-EW, F-1007-EX, F-1007-EY, F-1007-EZ, F-1007-FA, F-1007-FB, F-1007-FC, F-1007-FD, F-1007-FE, F-1007-FF, F-1007-FG, F-1007-FH, F-1007-FI, F-1007-FJ, F-1007-FL, F-1007-FM, F-1007-FN, F-1007-FO, F-1007-FP, F-1007-FQ, F-1007-FR, F-1007-FS, F-1007-FT, F-1007-FU, F-1007-FV, F-1007-FW, F-1007-FX, F-1007-FY, F-1007-FZ, F-1007-GA, F-1007-GB, F-1007-GC, F-1007-GD, F-1007-GE, F-1007-GF, F-1007-GG, F-1007-GH, F-1007-GI, F-1007-GJ, F-1007-GL, F-1007-GM, F-1007-GN, F-1007-GO, F-1007-GP, F-1007-GQ, F-1007-GR, F-1007-GS, F-1007-GT, F-1007-GU, F-1007-GV, F-1007-GW, F-1007-GX, F-1007-GY, F-1007-GZ, F-1007-HA, F-1007-HB, F-1007-HC, F-1007-HD, F-1007-HE, F-1007-HF, F-1007-HG, F-1007-HH, F-1007-HI, F-1007-HJ, F-1007-HL, F-1007-HM, F-1007-HN, F-1007-HO, F-1007-HP, F-1007-HQ, F-1007-HR, F-1007-HS, F-1007-HT, F-1007-HU, F-1007-HV, F-1007-HW, F-1007-HX, F-1007-HY, F-1007-HZ, F-1007-IA, F-1007-IB, F-1007-IC, F-1007-ID, F-1007-IE, F-1007-IF, F-1007-IG, F-1007-IH, F-1007-II, F-1007-IJ, F-1007-IL, F-1007-IM, F-1007-IN, F-1007-IO, F-1007-IP, F-1007-IQ, F-1007-IR, F-1007-IS, F-1007-IT, F-1007-IU, F-1007-IV, F-1007-IW, F-1007-IX, F-1007-IY, F-1007-IZ, F-1007-JA, F-1007-JB, F-1007-JC, F-1007-JD, F-1007-JE, F-1007-JF, F-1007-JG, F-1007-JH, F-1007-JI, F-1007-JJ, F-1007-JL, F-1007-JM, F-1007-JN, F-1007-JO, F-1007-JP, F-1007-JQ, F-1007-JR, F-1007-JS, F-1007-JT, F-1007-JU, F-1007-JV, F-1007-JW, F-1007-JX, F-1007-JY, F-1007-JZ, F-1007-KA, F-1007-KB, F-1007-KC, F-1007-KD, F-1007-KE, F-1007-KF, F-1007-KG, F-1007-KH, F-1007-KI, F-1007-KJ, F-1007-KL, F-1007-KM, F-1007-KN, F-1007-KO, F-1007-KP, F-1007-KQ, F-1007-KR, F-1007-KS, F-1007-KT, F-1007-KU, F-1007-KV, F-1007-KW, F-1007-KX, F-1007-KY, F-1007-KZ, F-1007-LA, F-1007-LB, F-1007-LC, F-1007-LD, F-1007-LE, F-1007-LF, F-1007-LG, F-1007-LH, F-1007-LI, F-1007-LJ, F-1007-LL, F-1007-LM, F-1007-LN, F-1007-LO, F-1007-LP, F-1007-LQ, F-1007-LR, F-1007-LS, F-1007-LT, F-1007-LU, F-1007-LV, F-1007-LW, F-1007-LX, F-1007-LY, F-1007-LZ, F-1007-MA, F-1007-MB, F-1007-MC, F-1007-MD, F-1007-ME, F-1007-MF, F-1007-MG, F-1007-MH, F-1007-MI, F-1007-MJ, F-1007-ML, F-1007-MM, F-1007-MN, F-1007-MO, F-1007-MP, F-1007-MQ, F-1007-MR, F-1007-MS, F-1007-MT, F-1007-MU, F-1007-MV, F-1007-MW, F-1007-MX, F-1007-MY, F-1007-MZ, F-1007-NA, F-1007-NB, F-1007-NC, F-1007-ND, F-1007-NE, F-1007-NF, F-1007-NG, F-1007-NH, F-1007-NI, F-1007-NJ, F-1007-NL, F-1007-NM, F-1007-NN, F-1007-NO, F-1007-NP, F-1007-NQ, F-1007-NR, F-1007-NS, F-1007-NT, F-1007-NU, F-1007-NV, F-1007-NW, F-1007-NX, F-1007-NY, F-1007-NZ, F-1007-OA, F-1007-OB, F-1007-OC, F-1007-OD, F-1007-OE, F-1007-OF, F-1007-OG, F-1007-OH, F-1007-OI, F-1007-OJ, F-1007-OL, F-1007-OM, F-1007-ON, F-1007-OO, F-1007-OP, F-1007-OQ, F-1007-OR, F-1007-OS, F-1007-OT, F-1007-OU, F-1007-OV, F-1007-OW, F-1007-OX, F-1007-OY, F-1007-OZ, F-1007-PA, F-1007-PB, F-1007-PC, F-1007-PD, F-1007-PE, F-1007-PF, F-1007-PG, F-1007-PH, F-1007-PI, F-1007-PJ, F-1007-PL, F-1007-PM, F-1007-PN, F-1007-PO, F-1007-PP, F-1007-PQ, F-1007-PR, F-1007-PS, F-1007-PT, F-1007-PU, F-1007-PV, F-1007-PW, F-1007-PX, F-1007-PY, F-1007-PZ, F-1007-QA, F-1007-QB, F-1007-QC, F-1007-QD, F-1007-QE, F-1007-QF, F-1007-QG, F-1007-QH, F-1007-QI, F-1007-QJ, F-1007-QL, F-1007-QM, F-1007-QN, F-1007-QO, F-1007-QP, F-1007-QL, F-1007-QM, F-1007-QN, F-1007-QO, F-1007-QP, F-1007-QR, F-1007-QS, F-1007-QT, F-1007-QU, F-1007-QV, F-1007-QW, F-1007-QX, F-1007-QY, F-1007-QZ, F-1007-RA, F-1007-RB, F-1007-RC, F-1007-RD, F-1007-RE, F-1007-RF, F-1007-RG, F-1007-RH, F-1007-RI, F-1007-RJ, F-1007-RL, F-1007-RM, F-1007-RN, F-1007-RO, F-1007-RR, F-1007-RS, F-1007-RT, F-1007-RU, F-1007-RV, F-1007-RW, F-1007-RX, F-1007-RY, F-1007-RZ, F-1007-SA, F-1007-SB, F-1007-SC, F-1007-SD, F-1007-SE, F-1007-SF, F-1007-SG, F-1007-SH, F-1007-SI, F-1007-SJ, F-1007-SL, F-1007-SM, F-1007-SN, F-1007-SO, F-1007-SS, F-1007-ST, F-1007-SU, F-1007-SV, F-1007-SW, F-1007-SX, F-1007-SY, F-1007-SZ, F-1007-TA, F-1007-TB, F-1007-TC, F-1007-TD, F-1007-TE, F-1007-TF, F-1007-TG, F-1007-TH, F-1007-TI, F-1007-TJ, F-1007-TL, F-1007-TM, F-1007-TN, F-1007-TO, F-1007-TT, F-1007-TU, F-1007-TV, F-1007-TW, F-1007-TX, F-1007-TY, F-1007-TZ, F-1007-UA, F-1007-UB, F-1007-UC, F-1007-UD, F-1007-UE, F-1007-UF, F-1007-UG, F-1007-UH, F-1007-UI, F-1007-UJ, F-1007-UL, F-1007-UM, F-1007-UN, F-1007-UO, F-1007-UR, F-1007-US, F-1007-UT, F-1007-UY, F-1007-UZ, F-1007-VA, F-1007-VB, F-1007-VC, F-1007-VD, F-1007-VE, F-1007-VF, F-1007-VG, F-1007-VH, F-1007-VI, F-1007-VJ, F-1007-VL, F-1007-VM, F-1007-VN, F-1007-VO, F-1007-VR, F-1007-VS, F-1007-VT, F-1007-VU, F-1007-VV, F-1007-VW, F-1007-VX, F-1007-VY, F-1007-VZ, F-1007-WA, F-1007-WB, F-1007-WC, F-1007-WD, F-1007-WE, F-1007-WF, F-1007-WG, F-1007-WH, F-1007-WI, F-1007-WJ, F-1007-WL, F-1007-WM, F-1007-WN, F-1007-WO, F-1007-WR, F-1007-WS, F-1007-WT, F-1007-WU, F-1007-WV, F-1007-WX, F-1007-WY, F-1007-WZ, F-1007-XA, F-1007-XB, F-1007-XC, F-1007-XD, F-1007-XE, F-1007-XF, F-1007-XG, F-1007-XH, F-1007-XI, F-1007-XJ, F-1007-XL, F-1007-XM, F-1007-XN, F-1007-XO, F-1007-XR, F-1007-XS, F-1007-XT, F-1007-XU, F-1007-XV, F-1007-XW, F-1007-XX, F-1007-XY, F-1007-XZ, F-1007-YA, F-1007-YB, F-1007-YC, F-1007-YD, F-1007-YE, F-1007-YF, F-1007-YG, F-1007-YH, F-1007-YI, F-1007-YJ, F-1007-YL, F-1007-YM, F-1007-YN, F-1007-YO, F-1007-YP, F-1007-YQ, F-1007-YR, F-1007-YS, F-1007-YT, F-1007-YU, F-1007-YV, F-1007-YW, F-1007-YX, F-1007-YY, F-1007-YZ, F-1007-ZA, F-1007-ZB, F-1007-ZC, F-1007-ZD, F-1007-ZE, F-1007-ZF, F-1007-ZG, F-1007-ZH, F-1007-ZI, F-1007-ZJ, F-1007-ZL, F-1007-ZM, F-1007-ZN, F-1007-ZO, F-1007-ZP, F-1007-ZQ, F-1007-ZR, F-1007-ZS, F-1007-ZT, F-1007-ZU, F-1007-ZV, F-1007-ZW, F-1007-ZX, F-1007-ZY, F-1007-ZZ.
 3. THIS Dwg HAS BEEN SPLIT INTO EM-1478-B & EM-1478-C.
 4. SOU, S&W, SOU 341, SOU 142 & SOU 143 ARE TO BE PROVIDED WITH Dwg.

APERTURE CARD

REV	DATE	DESCRIPTION	BY	CHK	APP
1					
2					
3					
4					
5					
6					
7					
8					
9					
10					

7-1-8
2002

NORTH-EAST NUCLEAR ENERGY COMPANY
SUBSIDIARY OF
NORTH-EAST UTILITIES

TITLE: HILLSTONE NUCLEAR POWER STATION - UNIT NO. 3
PIPING & INSTRUMENTATION DIAGRAM
DOMESTIC WATER & SANITARY SYSTEM

DATE: 11/13/81
SCALE: AS SHOWN
DRAWN: J. J. BROWN
CHECKED: J. J. BROWN
APPROVED: J. J. BROWN

DRAWING CREATED BY AUTOCAD

PDR RIDS

8406020247

