


3-CNS-113-6-12

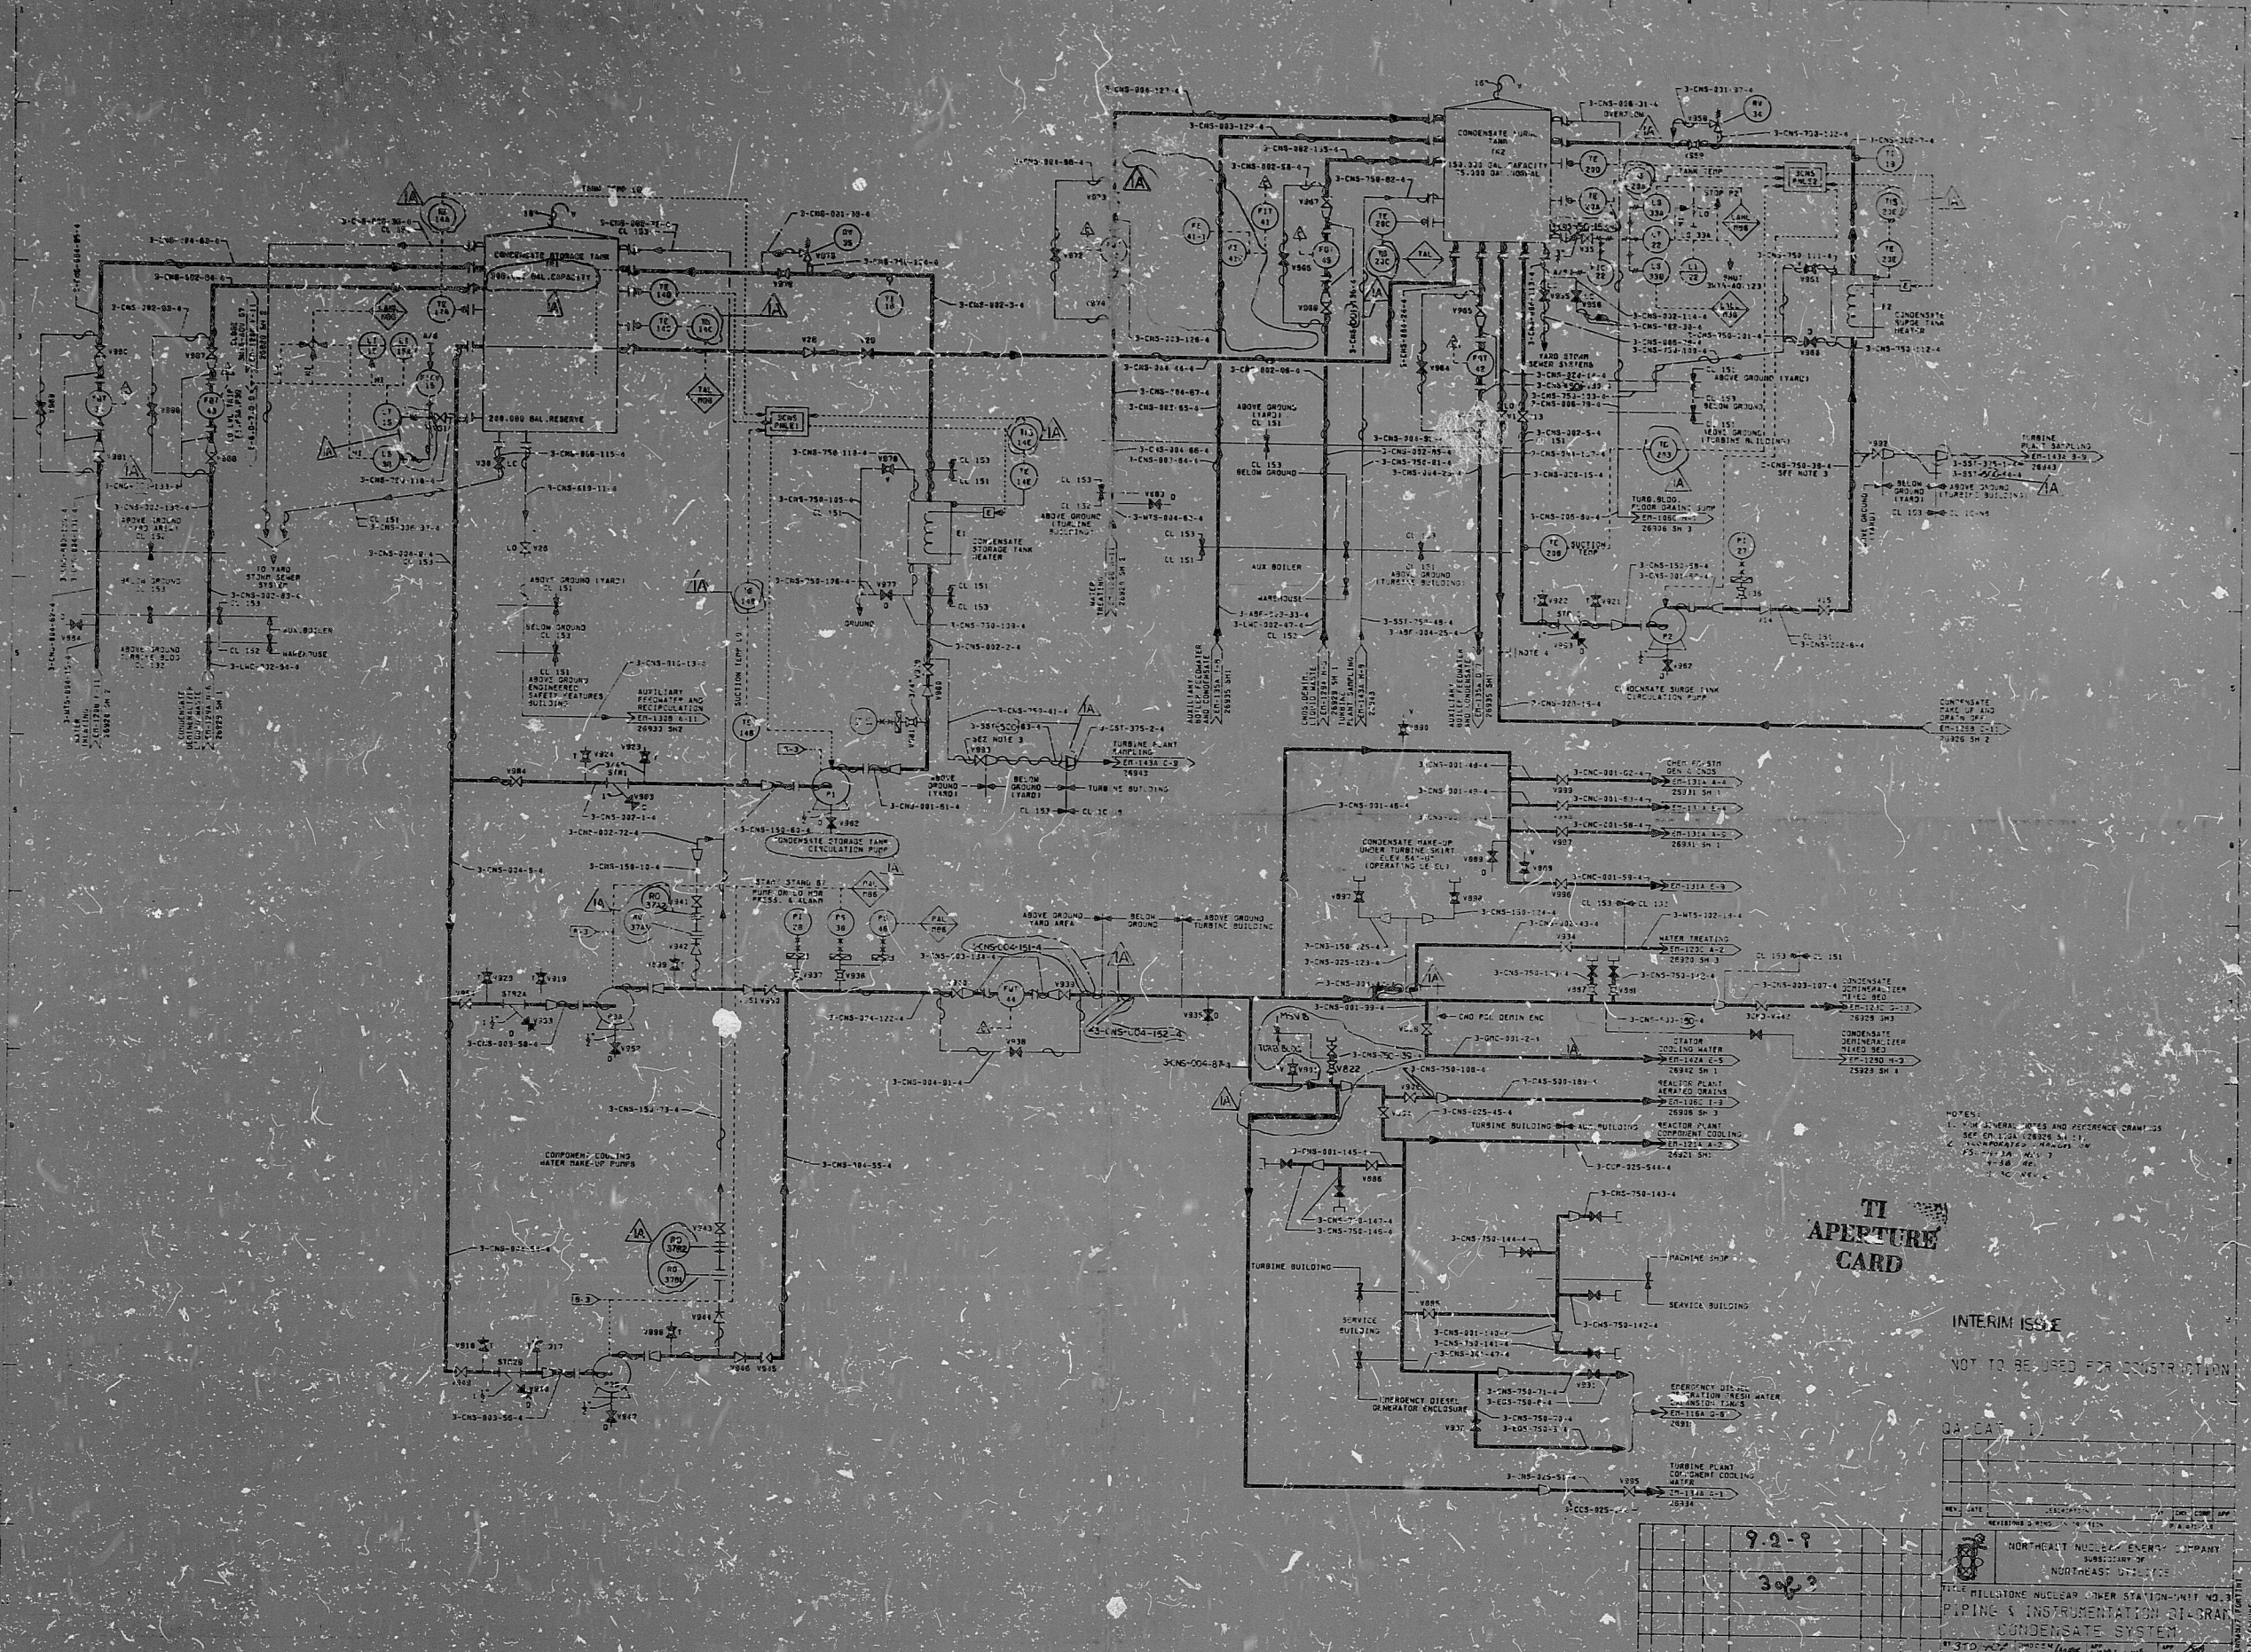

**TI APERTURE CARD**

INTERIM ISSUE  
NOT TO BE USED FOR CONSTRUCTION

QA - DA - 11

REV. DATE	DESCRIPTION	BY	CHKD BY
9-2-9			
3083			

NORTH EAST NUCLEAR ENERGY COMPANY  
 SUBSIDIARY OF  
 NORTHEAST UTILITIES  
 TITLE: PILLSTONE NUCLEAR POWER STATION - UNIT NO. 3  
 PIPING & INSTRUMENTATION DIAGRAM  
 CONDENSATE SYSTEM  
 DRAWING NO. 3-CNS-113-6-12  
 SCALE: AS SHOWN  
 DATE: 9-2-9  
 DRAWN BY: JAR 98 AS 5304N  
 CHECKED BY: JAR 98 AS 5304N  
 APPROVED BY: JAR 98 AS 5304N  
 DATE: 9-2-9

THE INFORMATION ON THIS DRAWING MAY NOT BE  
 COPIED OR USED FOR OTHER THAN THE COPIES  
 PROVIDED OR REPRODUCED BY THE PLANT FACILITY  
 DESCRIBED IN THE TITLE BLOCK.



in T10 - Line 16  
Line 17

PDR RIDS

8406020289

