


12179-E-M-151D-1

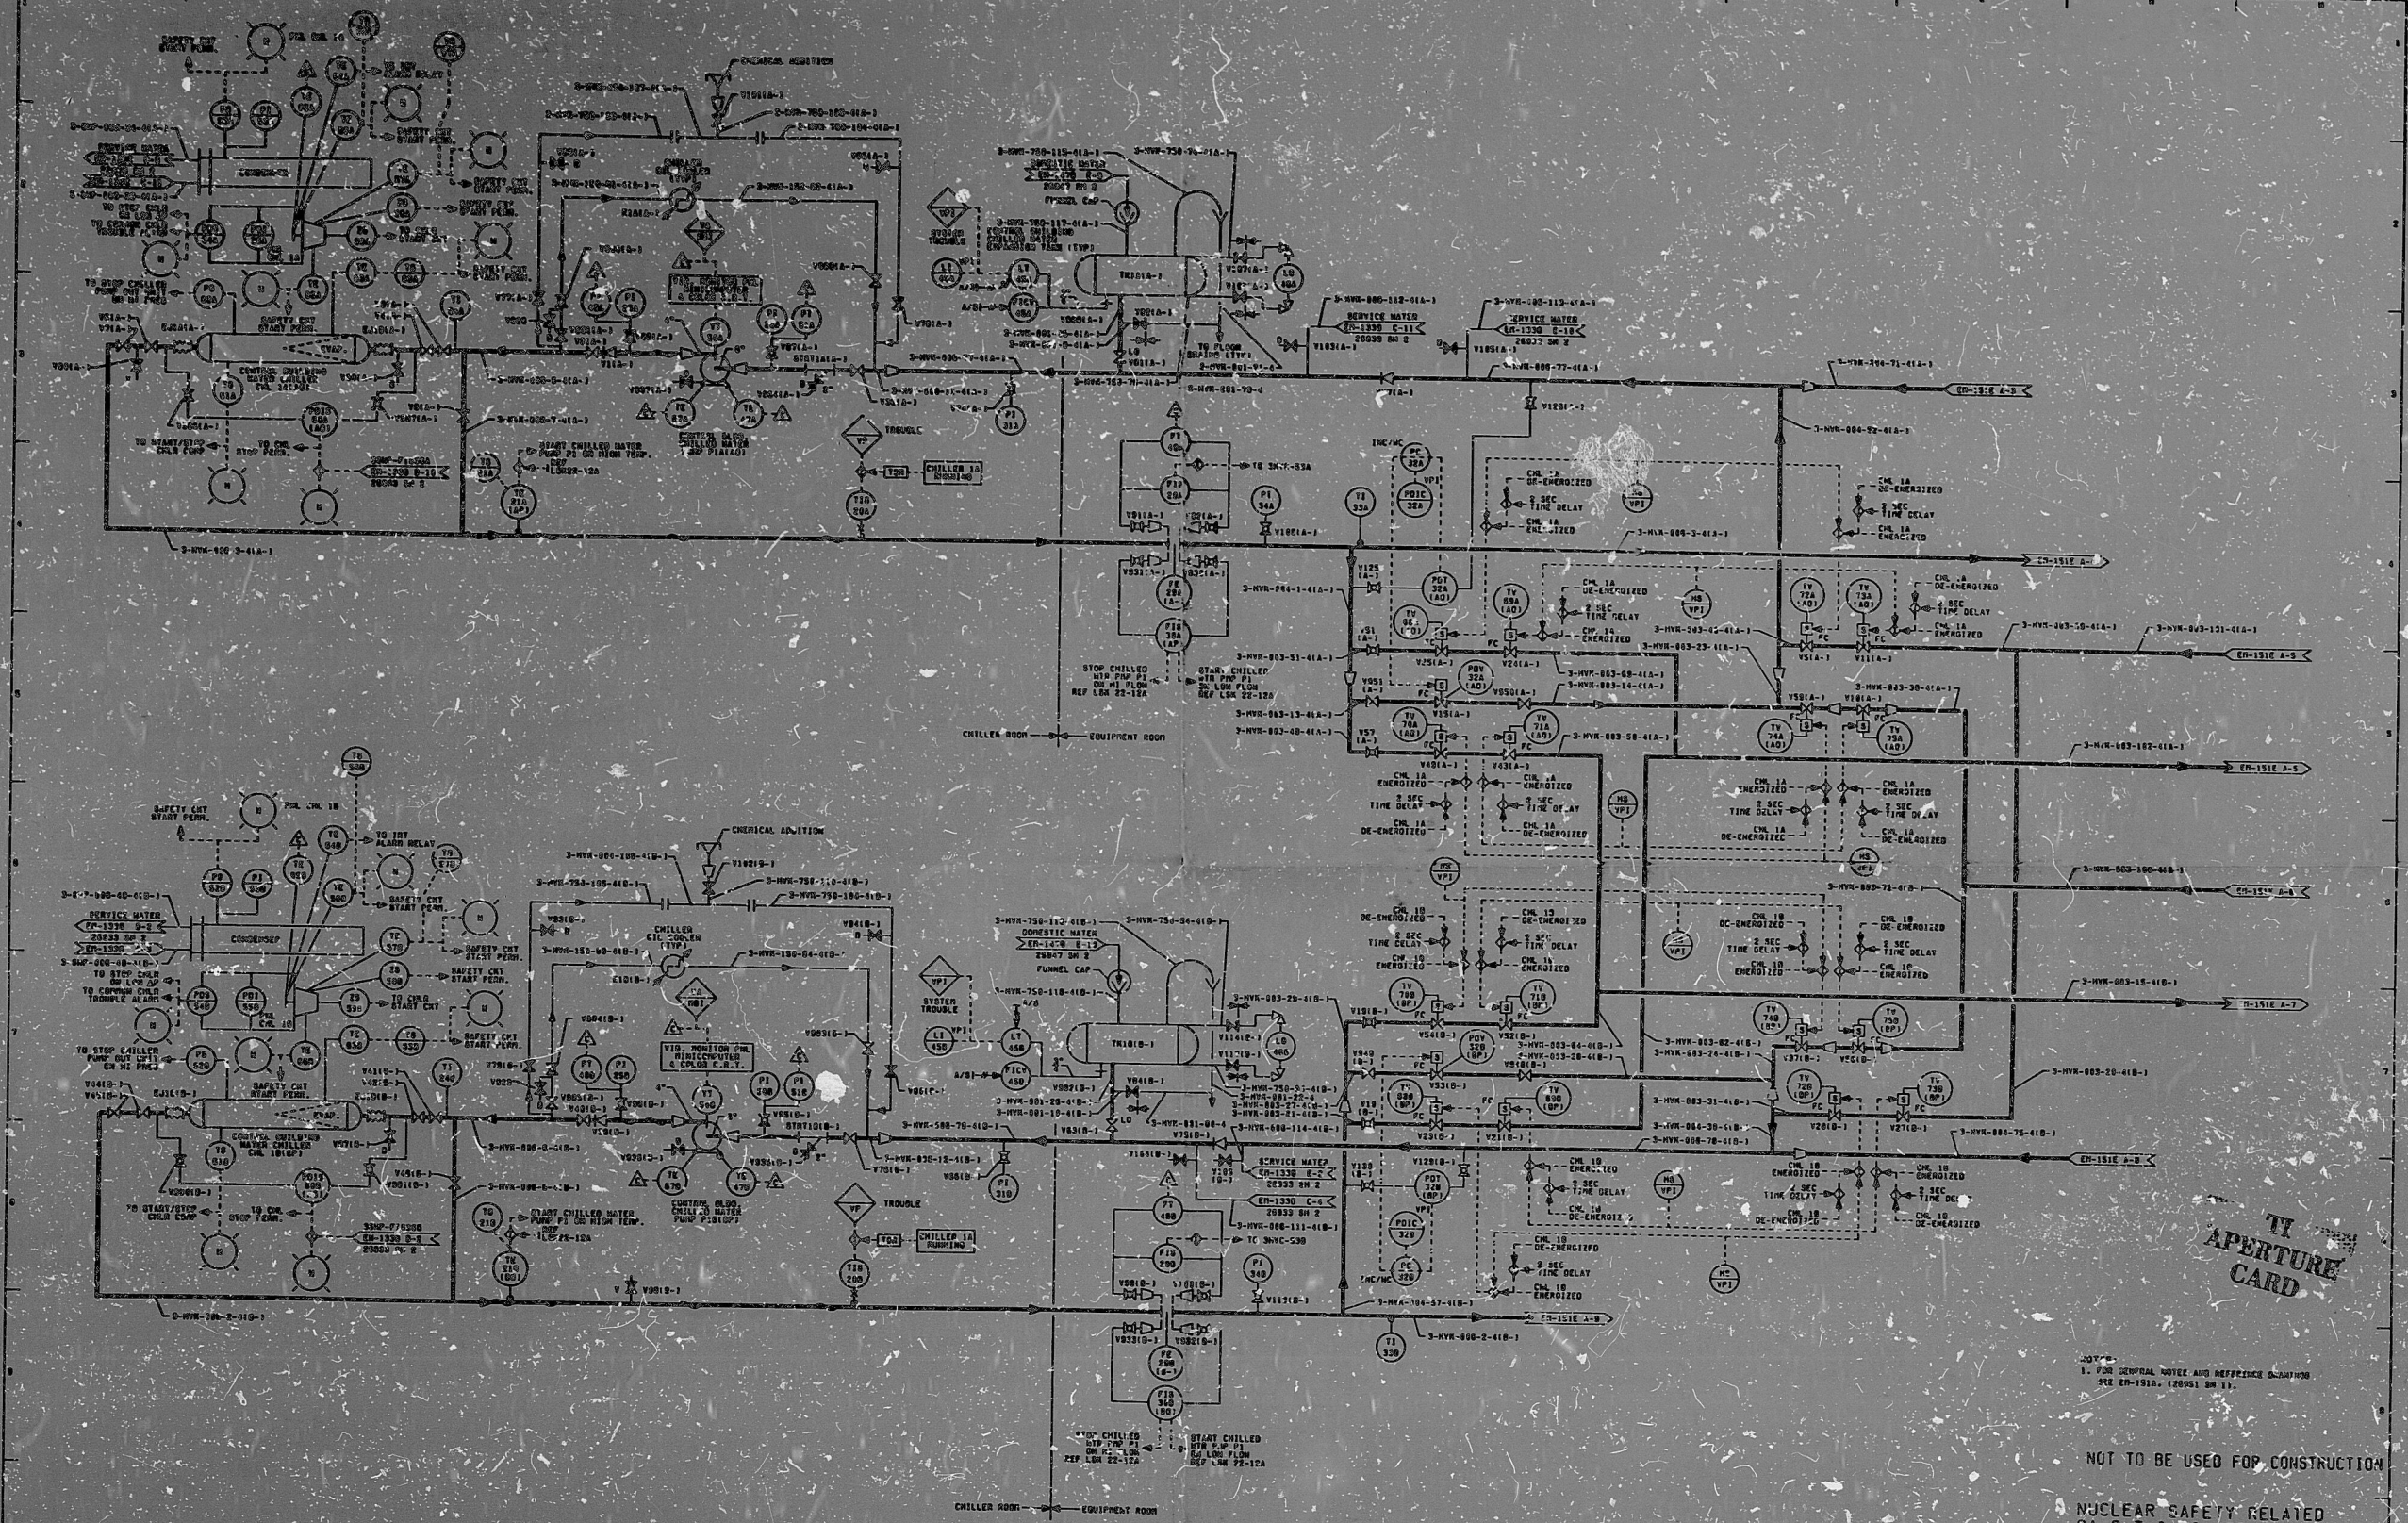

FOR GENERAL NOTICE AND REFERENCE ONLY
SEE EN-151A, 120951 SH 11.

NOT TO BE USED FOR CONSTRUCTION

NUCLEAR SAFETY RELATED
QA CAT. I, II, III

REV	NO	DESCRIPTION	DATE

9.4-1
4085

NORTHEAST NUCLEAR ENERGY COMPANY
A DIVISION OF
NORTHEAST UTILITIES

TITLE: PIPING & INSTRUMENTATION DIAGRAM
CONTROL BUILDING HEATING
VENTILATION AND AIR CONDITIONING

PROJECT NO. 5212-2601 SH 4 REV 5
DATE: 12/15/68
SCALE: AS SHOWN
P. A. #1-150

5212-2601 SH 4 REV 5
DRAWN BY: F. C. GILLEY
CHECKED BY: R. J. LAM

S4M OHG NO 12179-E-M-151D-1

PDR RIDS

8406020369

