


1-3151 43-6-74

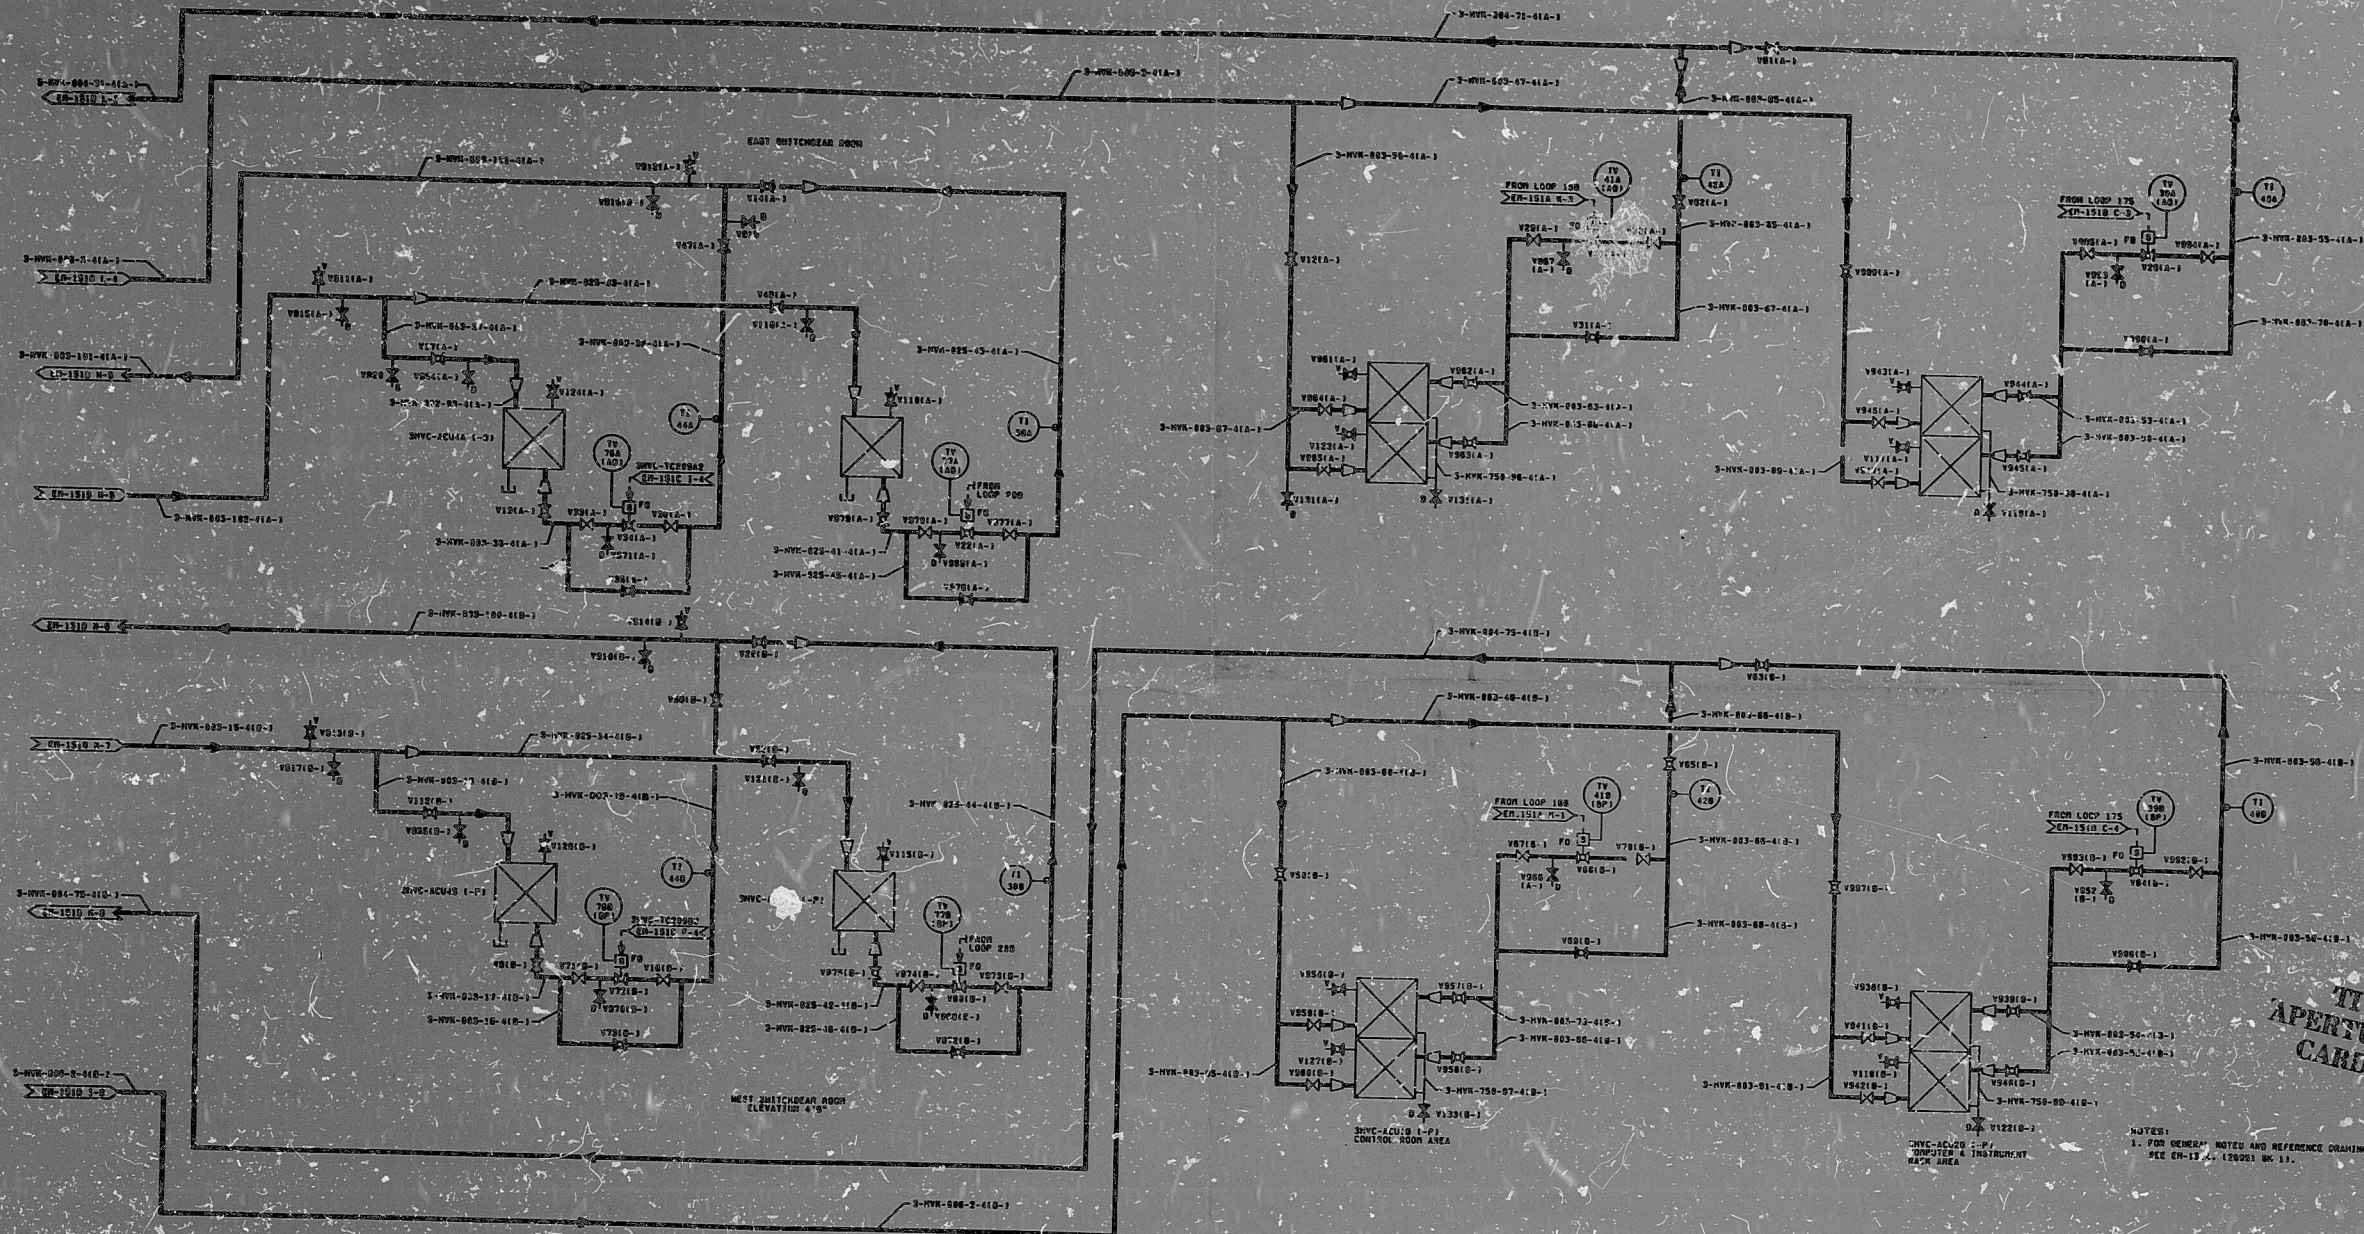

TI APERTURE CARD

NOTE:
1. FOR GENERAL NOTES AND REFERENCE DRAWINGS
SEE EN-17-A-12001 BK 11.

NOT TO BE USED FOR CONSTRUCTION

NUCLEAR SAFETY RELATED
QA CAT. 1, II, III

REV	DATE	DESCRIPTION	BY	CHK'D	APP'D

NORTH-EAST NUCLEAR ENERGY COMPANY
MEMBER OF
NORTHEAST UTILITIES
FILE MILLSTONE NUCLEAR POWER STATION UNIT NO. 3
PIPING & INSTRUMENTATION DIAGRAM
CONTROL BUILDING HEATING
VENTILATION AND AIR CONDITIONING
P.L. 478-150
25212: 2087 6X 9 OF 9
STAGE 4 HEATED ENGINEERING CORPORATION
CHECKED BY: J. L. LAM

S&W DMC NO 12179-E M-151E-1
DRAWN BY: F. GILLEY

THE INFORMATION ON THIS DRAWING HAS BEEN
OBTAINED FROM THE DESIGN OFFICE AND THE
INSTRUMENTATION DESIGN OFFICE OF THE
CONTROL BUILDING AREA.

PDR RIDS

8406020372

