
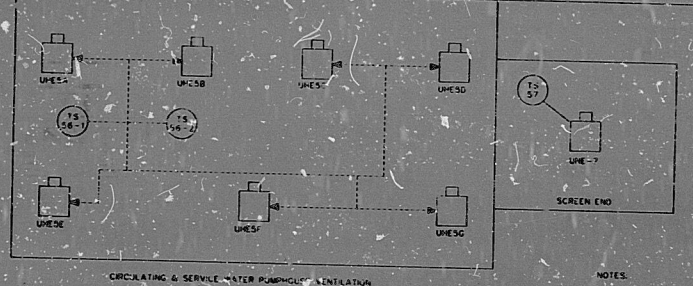
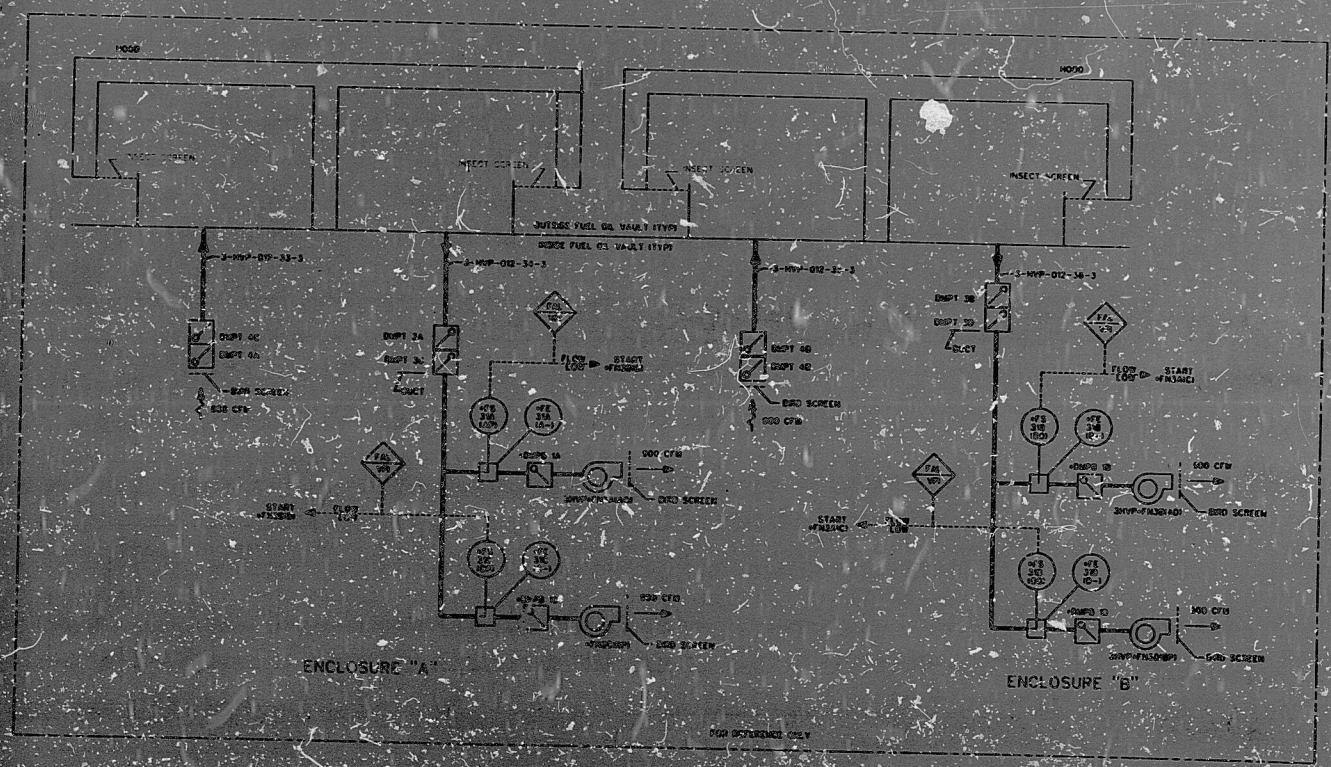
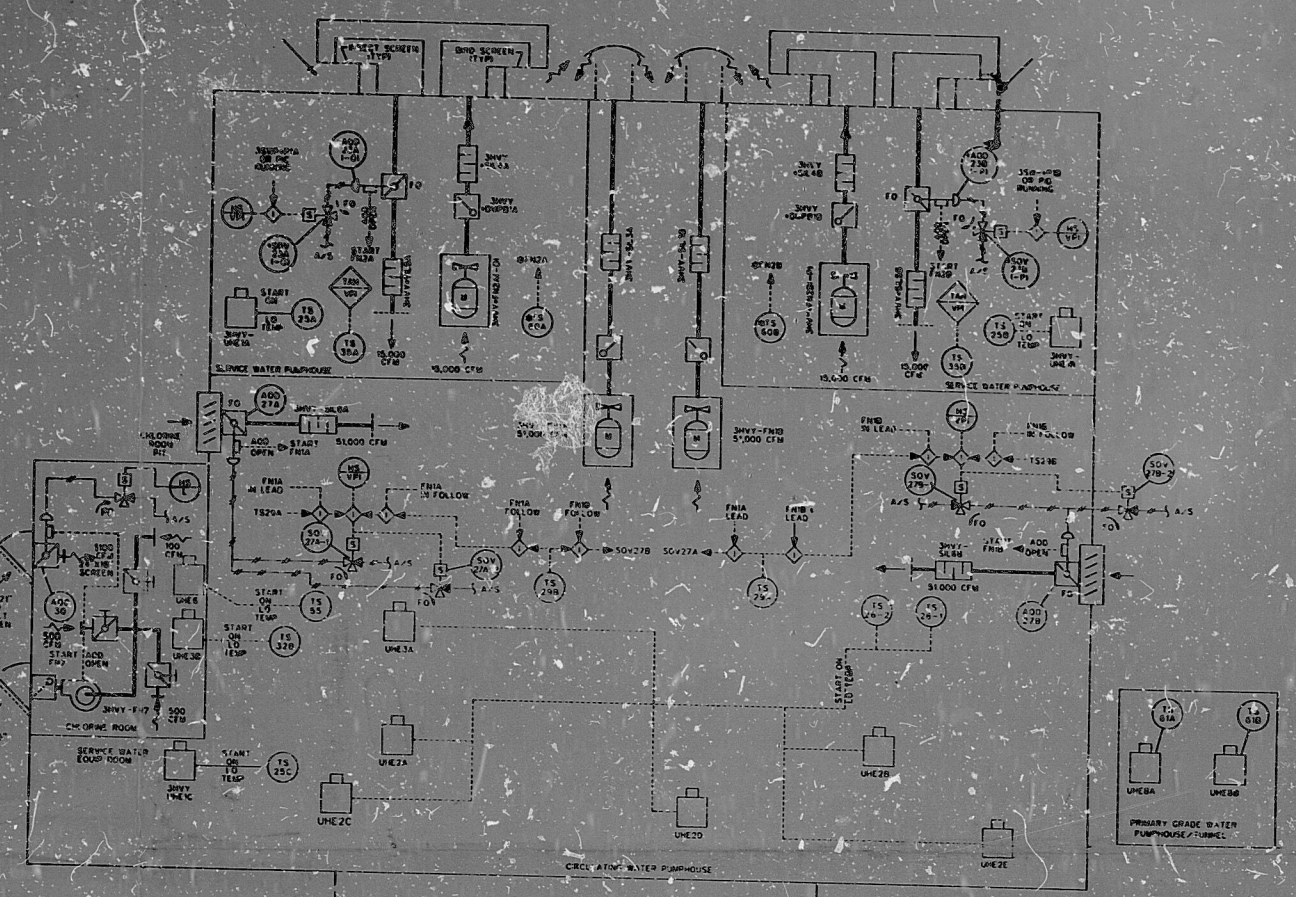


12-1500-1-3

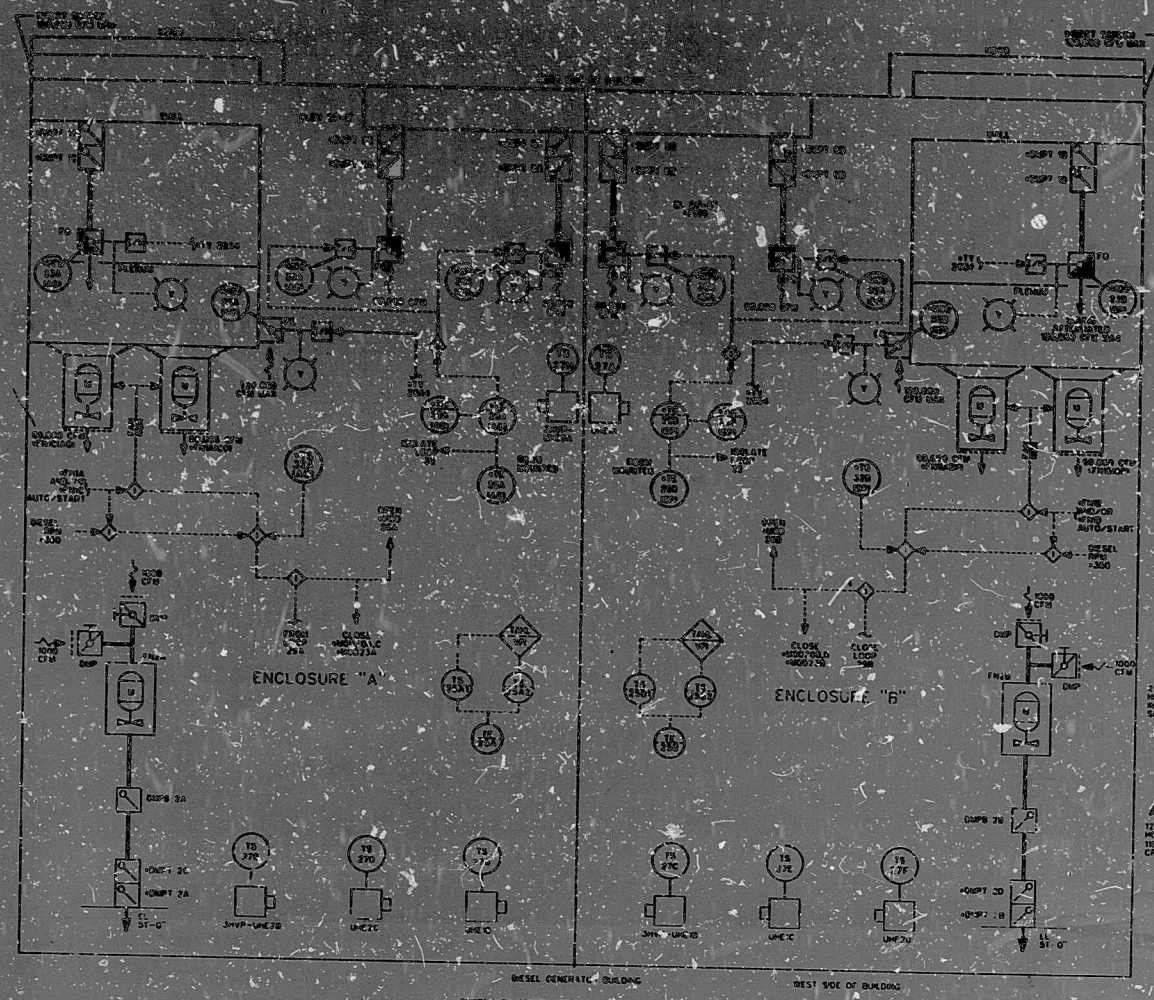

NOTES

71 APERTURE CARD

NOT TO BE USED FOR CONSTRUCTION

NUCLEAR SAFETY RELATED
QA CAT. I, II

INTERIM ISSUE

9-4-3
3 of 3

NO.	DATE	DESCRIPTION	BY	CHKD.
1		ISSUED FOR CONSTRUCTION		
2				
3				
4				
5				

NORTHEAST NUCLEAR ENERGY COMPANY
SUBSIDIARY OF
NORTHEAST UTILITIES
WILMINGTON NUCLEAR POWER STATION UNIT NO. 2
PIPING & INSTRUMENTATION DIAGRAM
TURBINE PLANT VENTILATION

DATE: 12-1500-1-3
SCALE: AS SHOWN
SHEET NO: 3 of 3
P. 8 of 10

25712-28000 SH 3 OF 3
S & W DWG NO. 12-179-E-M-159C-1B
DRAWN BY: P. G. BOGARD
CHECKED BY: J. B. CARLSON

THE INFORMATION ON THIS DRAWING MAY NOT BE
CORRECT OR COMPLETE. OTHER THAN THE INFORMATION
CONTAINED ON THE FACE OF THE DRAWING, THE USER
IS RESPONSIBLE FOR THE TITLE OF THIS DRAWING.

PDR RIDS

8406020399

