


12179-EM-1268-1

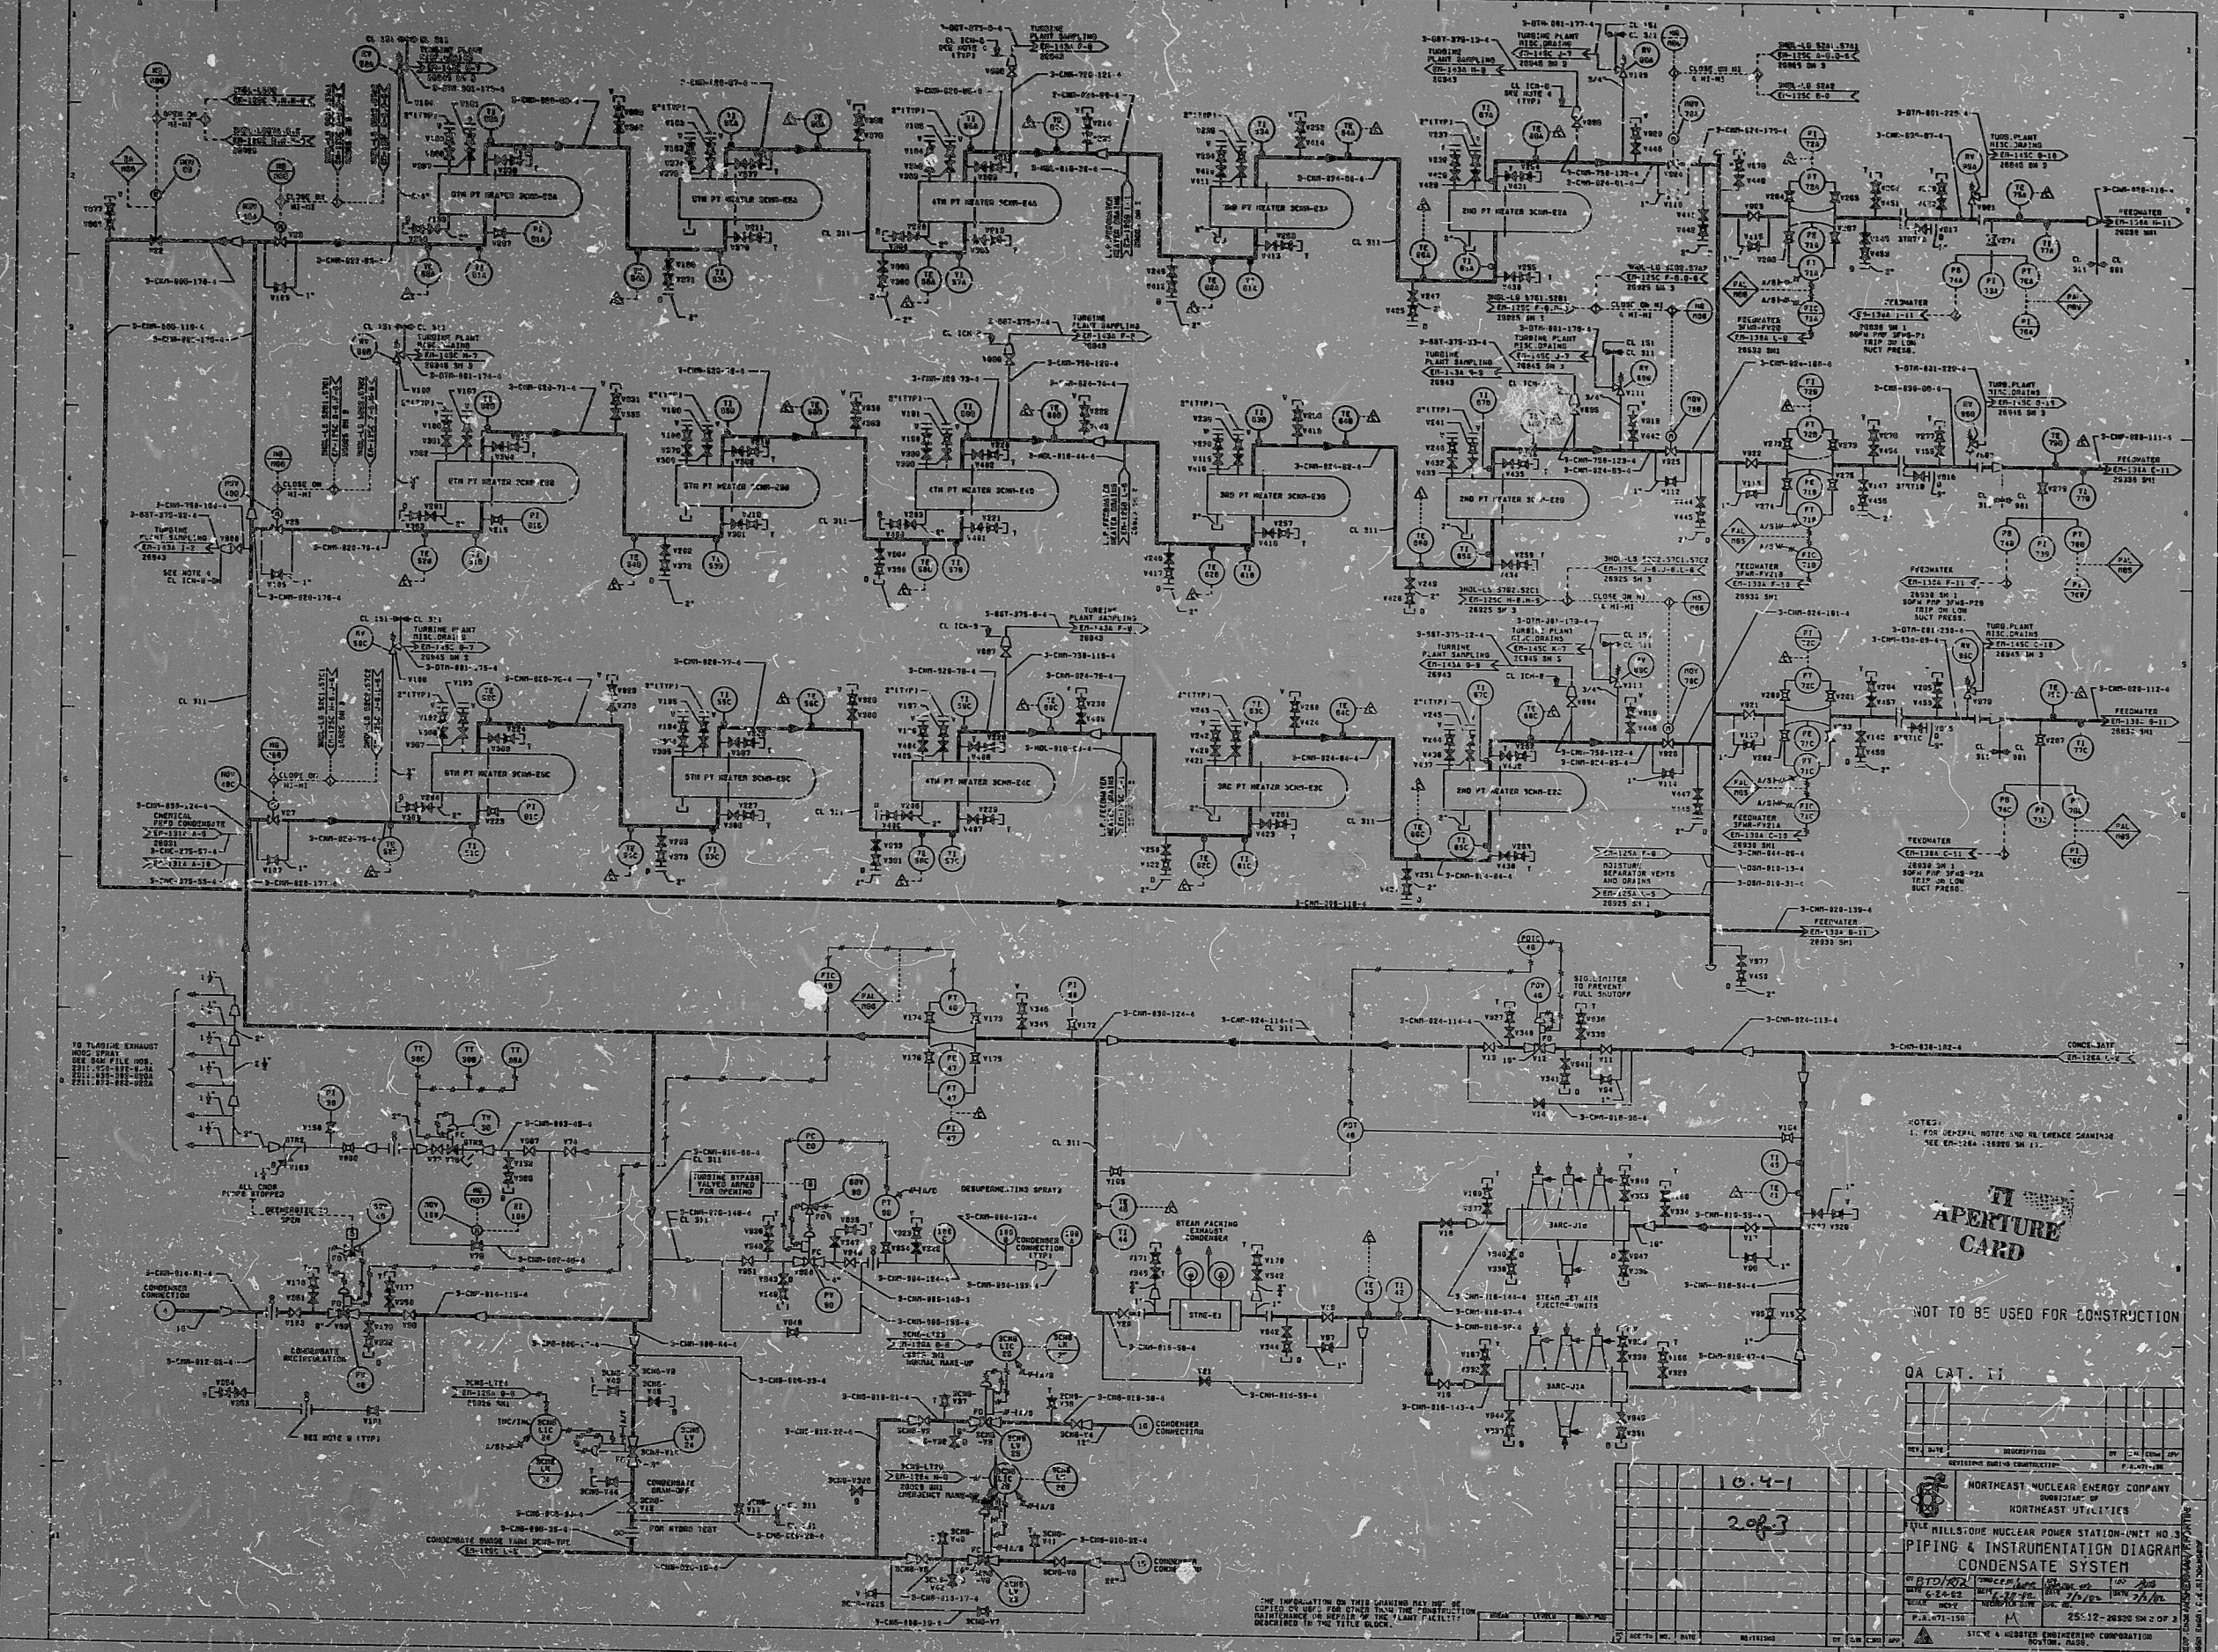

NOTES:
1. FOR GENERAL NOTES AND REERENCE DRAWINGS SEE EN-1268-10000 SHEET 11.

TI APERTURE CARD

NOT TO BE USED FOR CONSTRUCTION

QA CAT. 11

10-4-1
2083

NO.	REV.	DESCRIPTION	BY	IN	DATE

NORTHEAST NUCLEAR ENERGY COMPANY
NORTHEAST UTILITIES
WILLISTONE NUCLEAR POWER STATION-UNIT NO. 3
PIPING & INSTRUMENTATION DIAGRAM
CONDENSATE SYSTEM

SCALE: AS SHOWN
DATE: 10/18/68
BY: M
CHECKED BY: M
DATE: 10/25/68

S&W DWG NO 12179-EM-1268-1
DRAWN BY: R.F. JOHNSON
CHECKED BY: R.F. JOHNSON

THE INFORMATION ON THIS DRAWING HAS BEEN COPIED OR USED FOR OTHER THAN THE ORIGINAL PURPOSE OR FOR THE ORIGINAL FACILITY DESCRIBED IN THE TITLE BLOCK.

PDR RIDS

8406020436

