


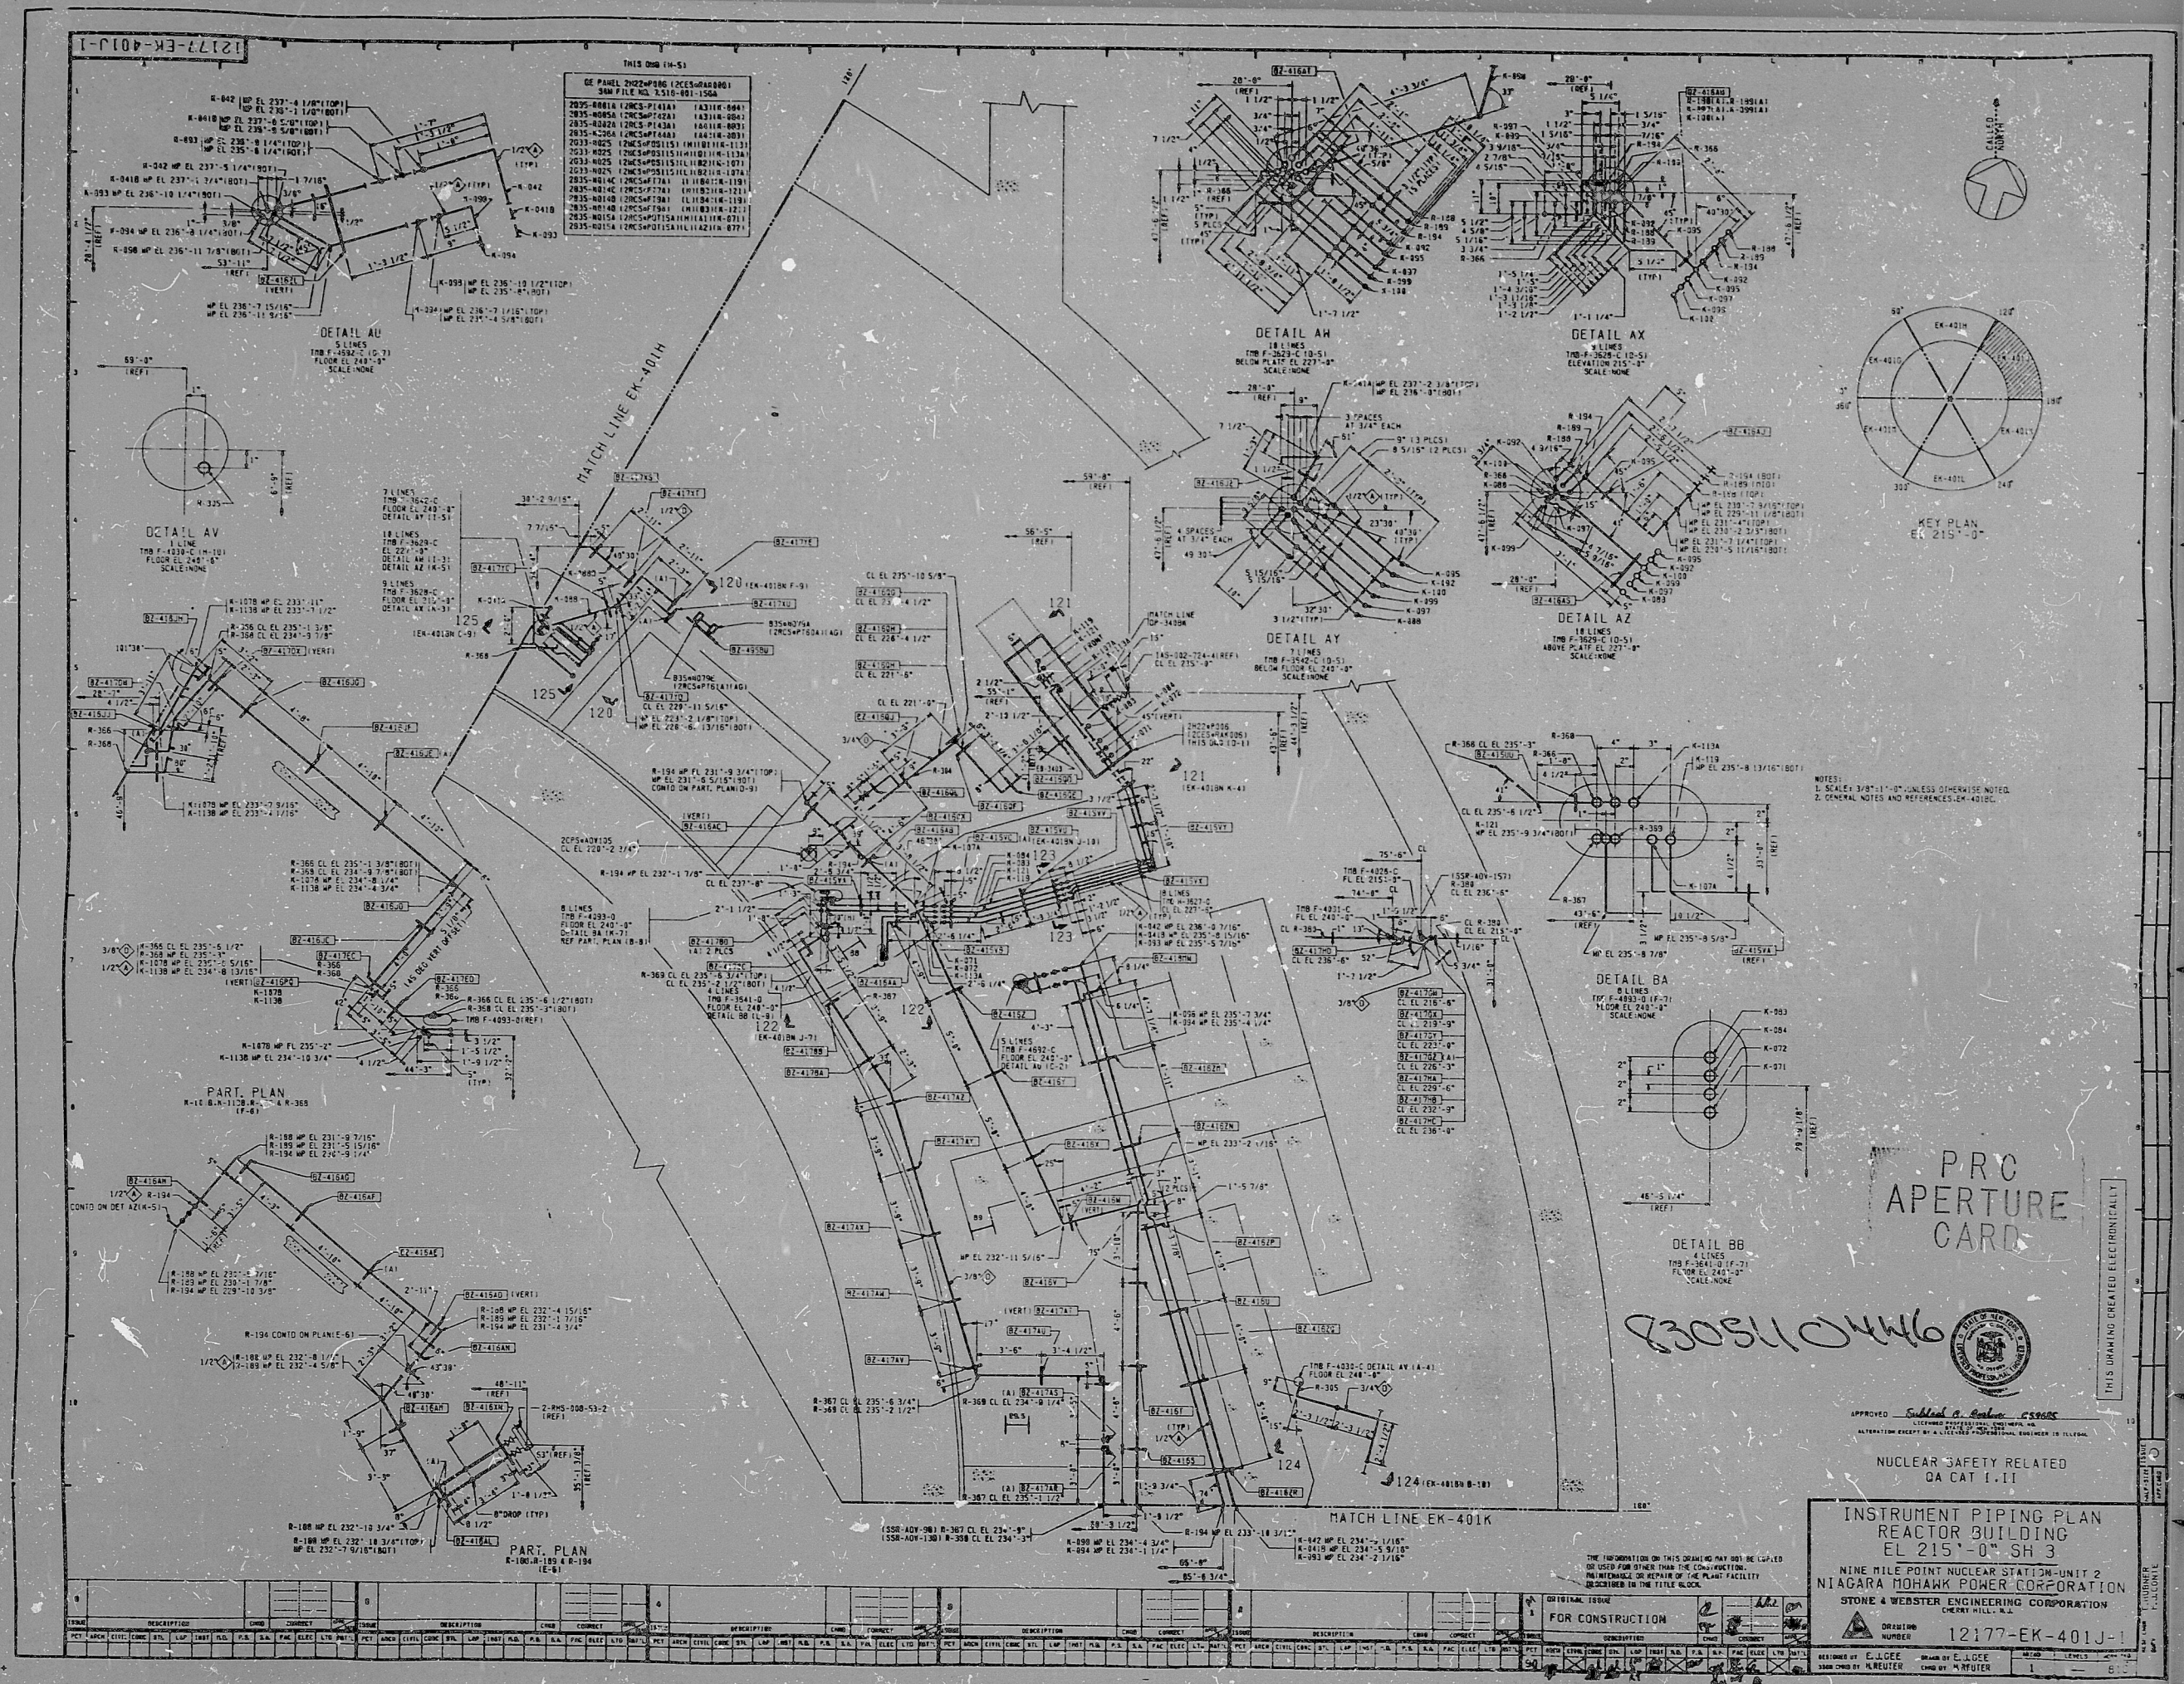

P.R.C.
APERTURE
CARD

APPROVED: *[Signature]* 12/26/68
NUCLEAR SAFETY RELATED
QA CAT. I, II

INSTRUMENT PIPING PLAN
REACTOR BUILDING
EL 215'-0" SH 3
NINE MILE POINT NUCLEAR STATION-UNIT 2
NIAGARA MOHAWK POWER CORPORATION
STONE & WEBSTER ENGINEERING CORPORATION

DRAWING NUMBER
12177-EK-401J-1
DESIGNED BY: E. L. JOE
CHECKED BY: R. REUTER

NO.	DESCRIPTION	QTY	UNIT	NO.	DESCRIPTION	QTY	UNIT
1	PIPE 1/2" SCH 40S	100	FT	11	PIPE 1/2" SCH 40S	100	FT
2	PIPE 1/2" SCH 40S	100	FT	12	PIPE 1/2" SCH 40S	100	FT
3	PIPE 1/2" SCH 40S	100	FT	13	PIPE 1/2" SCH 40S	100	FT
4	PIPE 1/2" SCH 40S	100	FT	14	PIPE 1/2" SCH 40S	100	FT
5	PIPE 1/2" SCH 40S	100	FT	15	PIPE 1/2" SCH 40S	100	FT
6	PIPE 1/2" SCH 40S	100	FT	16	PIPE 1/2" SCH 40S	100	FT
7	PIPE 1/2" SCH 40S	100	FT	17	PIPE 1/2" SCH 40S	100	FT
8	PIPE 1/2" SCH 40S	100	FT	18	PIPE 1/2" SCH 40S	100	FT
9	PIPE 1/2" SCH 40S	100	FT	19	PIPE 1/2" SCH 40S	100	FT
10	PIPE 1/2" SCH 40S	100	FT	20	PIPE 1/2" SCH 40S	100	FT

RIDS

8305110446

