


22  
17  
11  
8  
8.5  
11  
17  
22

22  
17  
11  
8  
8.5  
11  
17  
22

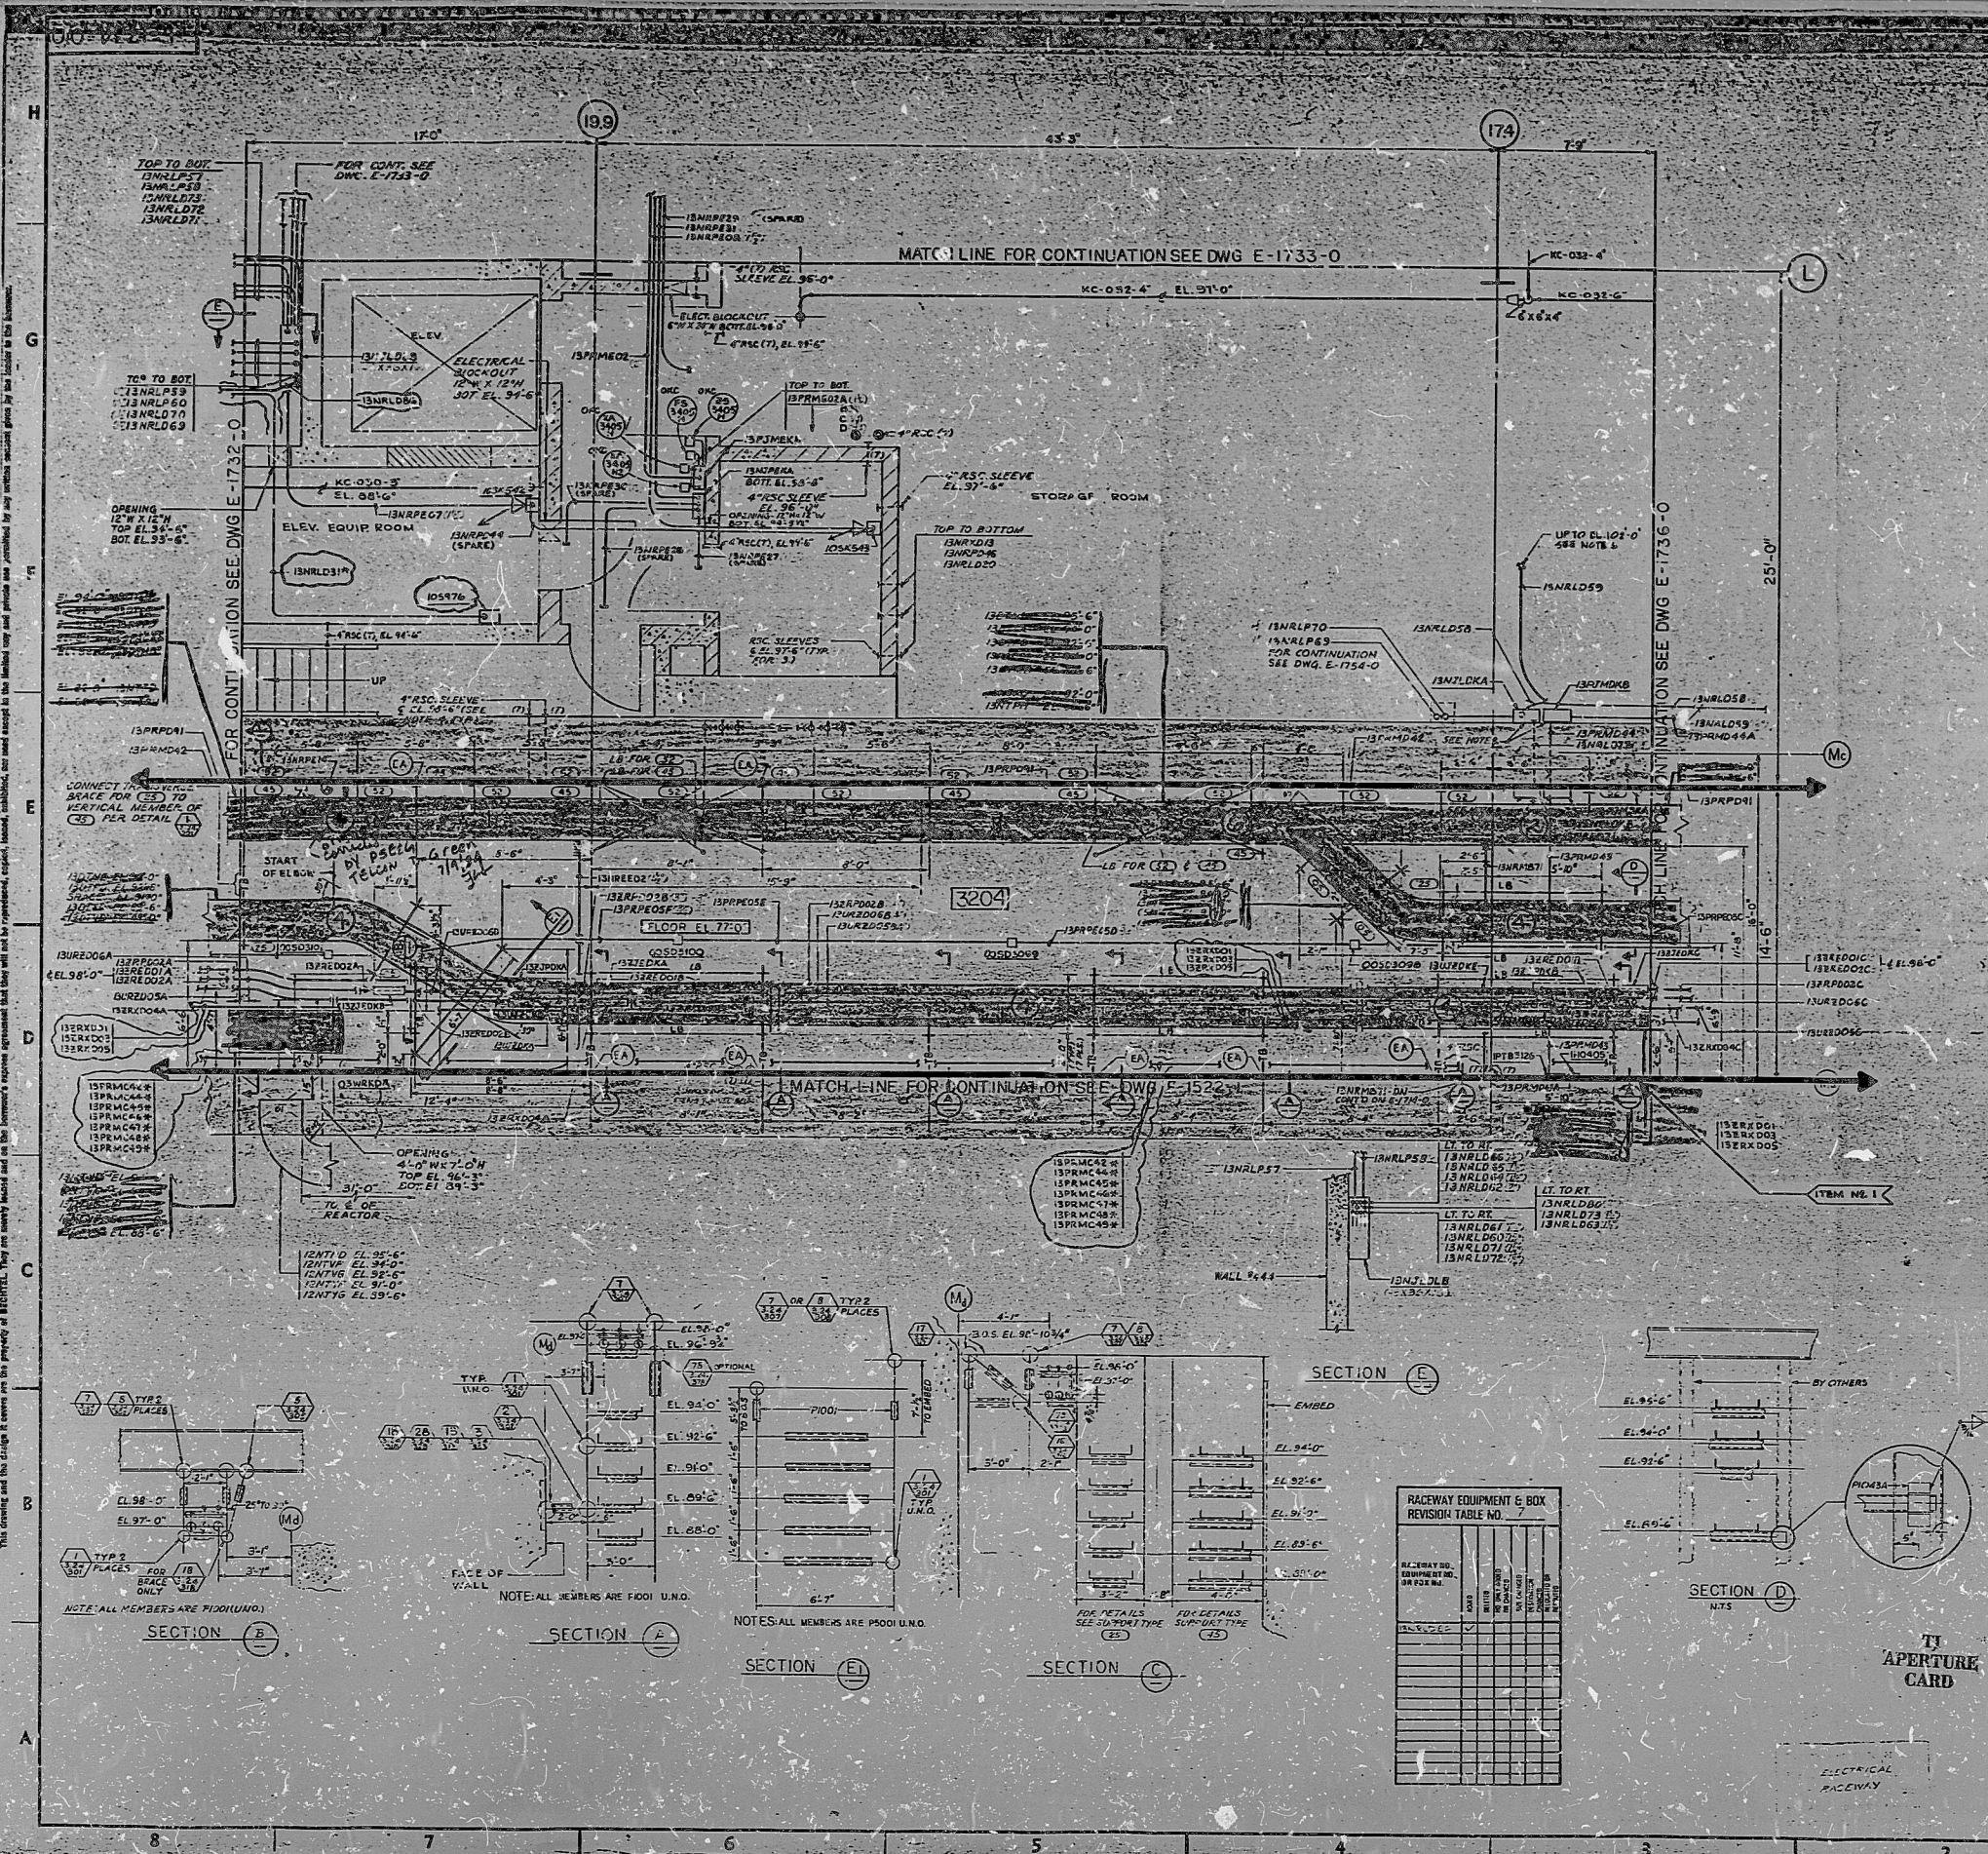

- NOTES:**
1. FOR RACEWAY SYMBOLS, NOTES & DETAILS & TRAY SUPPORTS SEE DWG. E-1733-0.
  2. FOR ELECTRICAL NUMBERING SYSTEM SEE DWG. E-1733-0.
  3. FOR EXACT LOCATION OF BLOCKOUTS IN CONG. BLOCK WALLS SEE ARCHITECTURAL DWG. 1401 FOR SLEEVES IN CONG. WALLS SEE CIVIL DWGS.
  4. (T) - DENOTES RIG. SLEEVE REQUESTED BY FIELD FOR TEMPORARY POWER.
  5. CLASS OF RACEWAY TRAY & CONDUIT ETC. ARE IDENTIFIED FOR LISTED INSTALLATION BY LETTERS A, B, C, D, E, F, G, H, I, J, K, L, M, N, O, P, Q, R, S, T, U, V, W, X, Y, Z, AA, AB, AC, AD, AE, AF, AG, AH, AI, AJ, AK, AL, AM, AN, AO, AP, AQ, AR, AS, AT, AU, AV, AW, AX, AY, AZ, BA, BB, BC, BD, BE, BF, BG, BH, BI, BJ, BK, BL, BM, BN, BO, BP, BQ, BR, BS, BT, BU, BV, BW, BX, BY, BZ, CA, CB, CC, CD, CE, CF, CG, CH, CI, CJ, CK, CL, CM, CN, CO, CP, CQ, CR, CS, CT, CU, CV, CW, CX, CY, CZ, DA, DB, DC, DD, DE, DF, DG, DH, DI, DJ, DK, DL, DM, DN, DO, DP, DQ, DR, DS, DT, DU, DV, DW, DX, DY, DZ, EA, EB, EC, ED, EE, EF, EG, EH, EI, EJ, EK, EL, EM, EN, EO, EP, EQ, ER, ES, ET, EU, EV, EW, EX, EY, EZ, FA, FB, FC, FD, FE, FF, FG, FH, FI, FJ, FK, FL, FM, FN, FO, FP, FQ, FR, FS, FT, FU, FV, FW, FX, FY, FZ, GA, GB, GC, GD, GE, GF, GG, GH, GI, GJ, GK, GL, GM, GN, GO, GP, GQ, GR, GS, GT, GU, GV, GW, GX, GY, GZ, HA, HB, HC, HD, HE, HF, HG, HH, HI, HJ, HK, HL, HM, HN, HO, HP, HQ, HR, HS, HT, HU, HV, HW, HX, HY, HZ, IA, IB, IC, ID, IE, IF, IG, IH, II, IJ, IK, IL, IM, IN, IO, IP, IQ, IR, IS, IT, IU, IV, IW, IX, IY, IZ, JA, JB, JC, JD, JE, JF, JG, JH, JI, JJ, JK, JL, JM, JN, JO, JP, JQ, JR, JS, JT, JU, JV, JW, JX, JY, JZ, KA, KB, KC, KD, KE, KF, KG, KH, KI, KJ, KK, KL, KM, KN, KO, KP, KQ, KR, KS, KT, KU, KV, KW, KX, KY, KZ, LA, LB, LC, LD, LE, LF, LG, LH, LI, LJ, LK, LL, LM, LN, LO, LP, LQ, LR, LS, LT, LU, LV, LW, LX, LY, LZ, MA, MB, MC, MD, ME, MF, MG, MH, MI, MJ, MK, ML, MN, MO, MP, MQ, MR, MS, MT, MU, MV, MW, MX, MY, MZ, NA, NB, NC, ND, NE, NF, NG, NH, NI, NJ, NK, NL, NM, NO, NP, NQ, NR, NS, NT, NU, NV, NW, NX, NY, NZ, OA, OB, OC, OD, OE, OF, OG, OH, OI, OJ, OK, OL, OM, ON, OO, OP, OQ, OR, OS, OT, OU, OV, OW, OX, OY, OZ, PA, PB, PC, PD, PE, PF, PG, PH, PI, PJ, PK, PL, PM, PN, PO, PP, PQ, PR, PS, PT, PU, PV, PW, PX, PY, PZ, QA, QB, QC, QD, QE, QF, QG, QH, QI, QJ, QK, QL, QM, QN, QO, QP, QQ, QR, QS, QT, QU, QV, QW, QX, QY, QZ, RA, RB, RC, RD, RE, RF, RG, RH, RI, RJ, RK, RL, RM, RN, RO, RP, RQ, RR, RS, RT, RU, RV, RW, RX, RY, RZ, SA, SB, SC, SD, SE, SF, SG, SH, SI, SJ, SK, SL, SM, SN, SO, SP, SQ, SR, SS, ST, SU, SV, SW, SX, SY, SZ, TA, TB, TC, TD, TE, TF, TG, TH, TI, TJ, TK, TL, TM, TN, TO, TP, TQ, TR, TS, TT, TU, TV, TW, TX, TY, TZ, UA, UB, UC, UD, UE, UF, UG, UH, UI, UJ, UK, UL, UM, UN, UO, UP, UQ, UR, US, UT, UY, UV, UW, UX, UY, UZ, VA, VB, VC, VD, VE, VF, VG, VH, VI, VJ, VK, VL, VM, VN, VO, VP, VQ, VR, VS, VT, VU, VV, VW, VX, VY, VZ, WA, WB, WC, WD, WE, WF, WG, WH, WI, WJ, WK, WL, WM, WN, WO, WP, WQ, WR, WS, WT, WU, WV, WW, WX, WY, WZ, XA, XB, XC, XD, XE, XF, XG, XH, XI, XJ, XK, XL, XM, XN, XO, XP, XQ, XR, XS, XT, XU, XV, XW, XX, XY, XZ, YA, YB, YC, YD, YE, YF, YG, YH, YI, YJ, YK, YL, YM, YN, YO, YP, YQ, YR, YS, YT, YU, YV, YW, YX, YY, YZ, ZA, ZB, ZC, ZD, ZE, ZF, ZG, ZH, ZI, ZJ, ZK, ZL, ZM, ZN, ZO, ZP, ZQ, ZR, ZS, ZT, ZU, ZV, ZW, ZX, ZY, ZZ.

- REFERENCE DRAWINGS:**
- C-1156-0 AUX. BLDG. R/W AND SERVICE AREA STRUCTURAL STEEL FLOOR FRAMING PLAN AT EL. 92'-0" AREA A
  - C-1013-0 AUX. BLDG. R/W AND SERVICE AREA FLOOR PLAN, 87'-0" AREA 7E
  - C-1125-0 AUX. BLDG. R/W AND SERVICE AREA INTERIOR WALL KEY PLANS (SHEET #2)
  - C-0675-1 REACTOR BLDG. EXTERIOR WALL ELEVATION - EAST SIDE, 11'-0" LIGHT #1
  - P-702-0 PLUMBING AREA DWG. AUX. BLDG. AREA 7E PLAN AT EL. 92'-0"
  - P-8723-0 PLUMBING & DRAINAGE AUX. BLDG. AREA 7E PLAN AT EL. 92'-0"
  - R-3722-0 HVAC R/W DRAWING AREA 7E PLAN AT EL. 92'-0"
  - C-1128-0 AUX. BLDG. RADWASTE & SERVICE AREA INTERIOR WALL ELEVATIONS WALL NOS. 608, 609, 610, 611
  - A-3525-0 AUX. BLDG. SERVICE RADWASTE INTERIOR ELEVATION - EL. 92'-0"
  - C-1125-1 AUX. BLDG. R/W AND SERVICE AREA - SOUTH AREA C-1125-0 EXTERIOR WALL ELEVATION - WEST WALL

NO.	DESCRIPTION	DATE	BY	CHECKED	APPROVED
1	ISSUED FOR CONSTRUCTION	11/73	J. W. HOGAN	A. E. V.	

**BECHTEL**  
SAN FRANCISCO


PUBLIC SERVICE ELECTRIC AND GAS COMPANY  
HOPE CREEK GENERATING STATION

RACEWAY PLAN  
AUX. BLDG. RADWASTE AREA 7E  
PLAN EL. 87'-0"

JOB NO.	DRAWING NO.	REV.
10855	E-1734-0	11

**RACEWAY EQUIPMENT & BOX REVISION TABLE NO. 7**

NO.	DESCRIPTION	DATE	BY	CHECKED	APPROVED

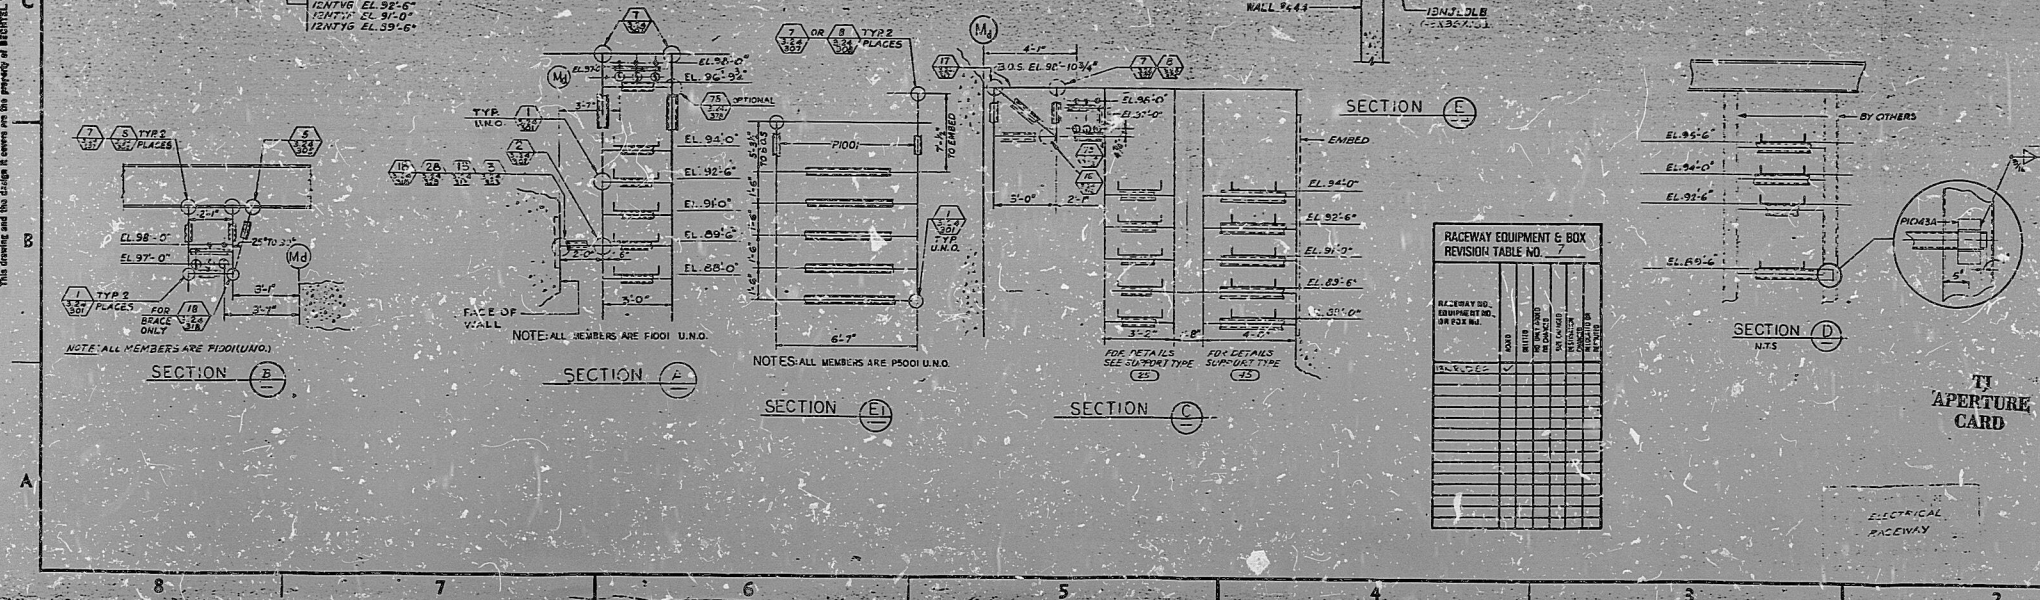

8  
7  
6  
5  
4  
3  
2  
1

**KEY PLAN**

10	11	12	13	14	15
16	17	18	19	20	21
22	23	24	25	26	27
28	29	30	31	32	33
34	35	36	37	38	39
40	41	42	43	44	45

UNIT NO. 2 PLAN UNIT NO. 1

22  
17  
11  
8  
8.5  
11  
17  
22

PDR RIDS

8409040234

