
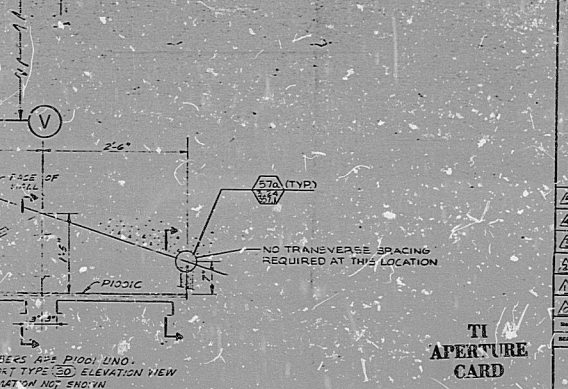
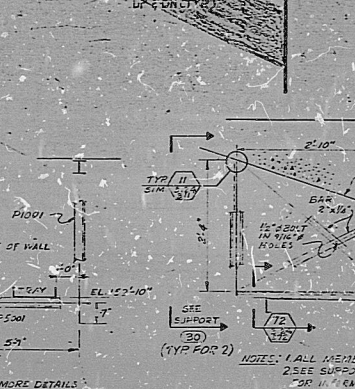
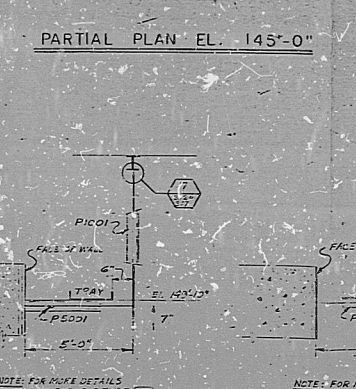
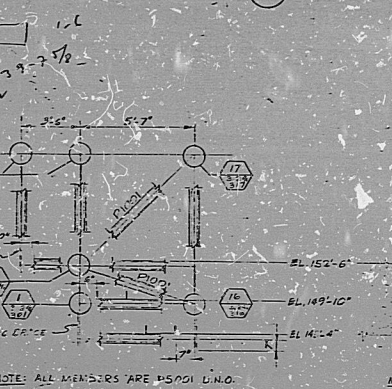
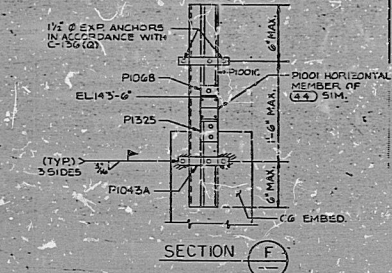
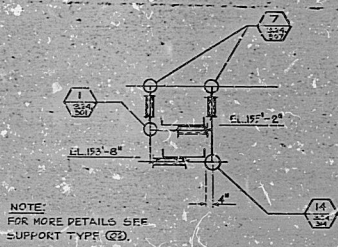
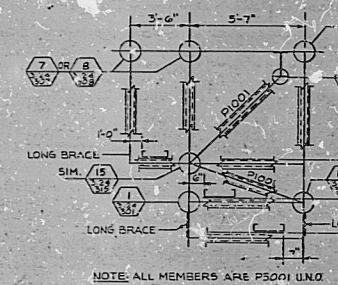


E-1575-1-0

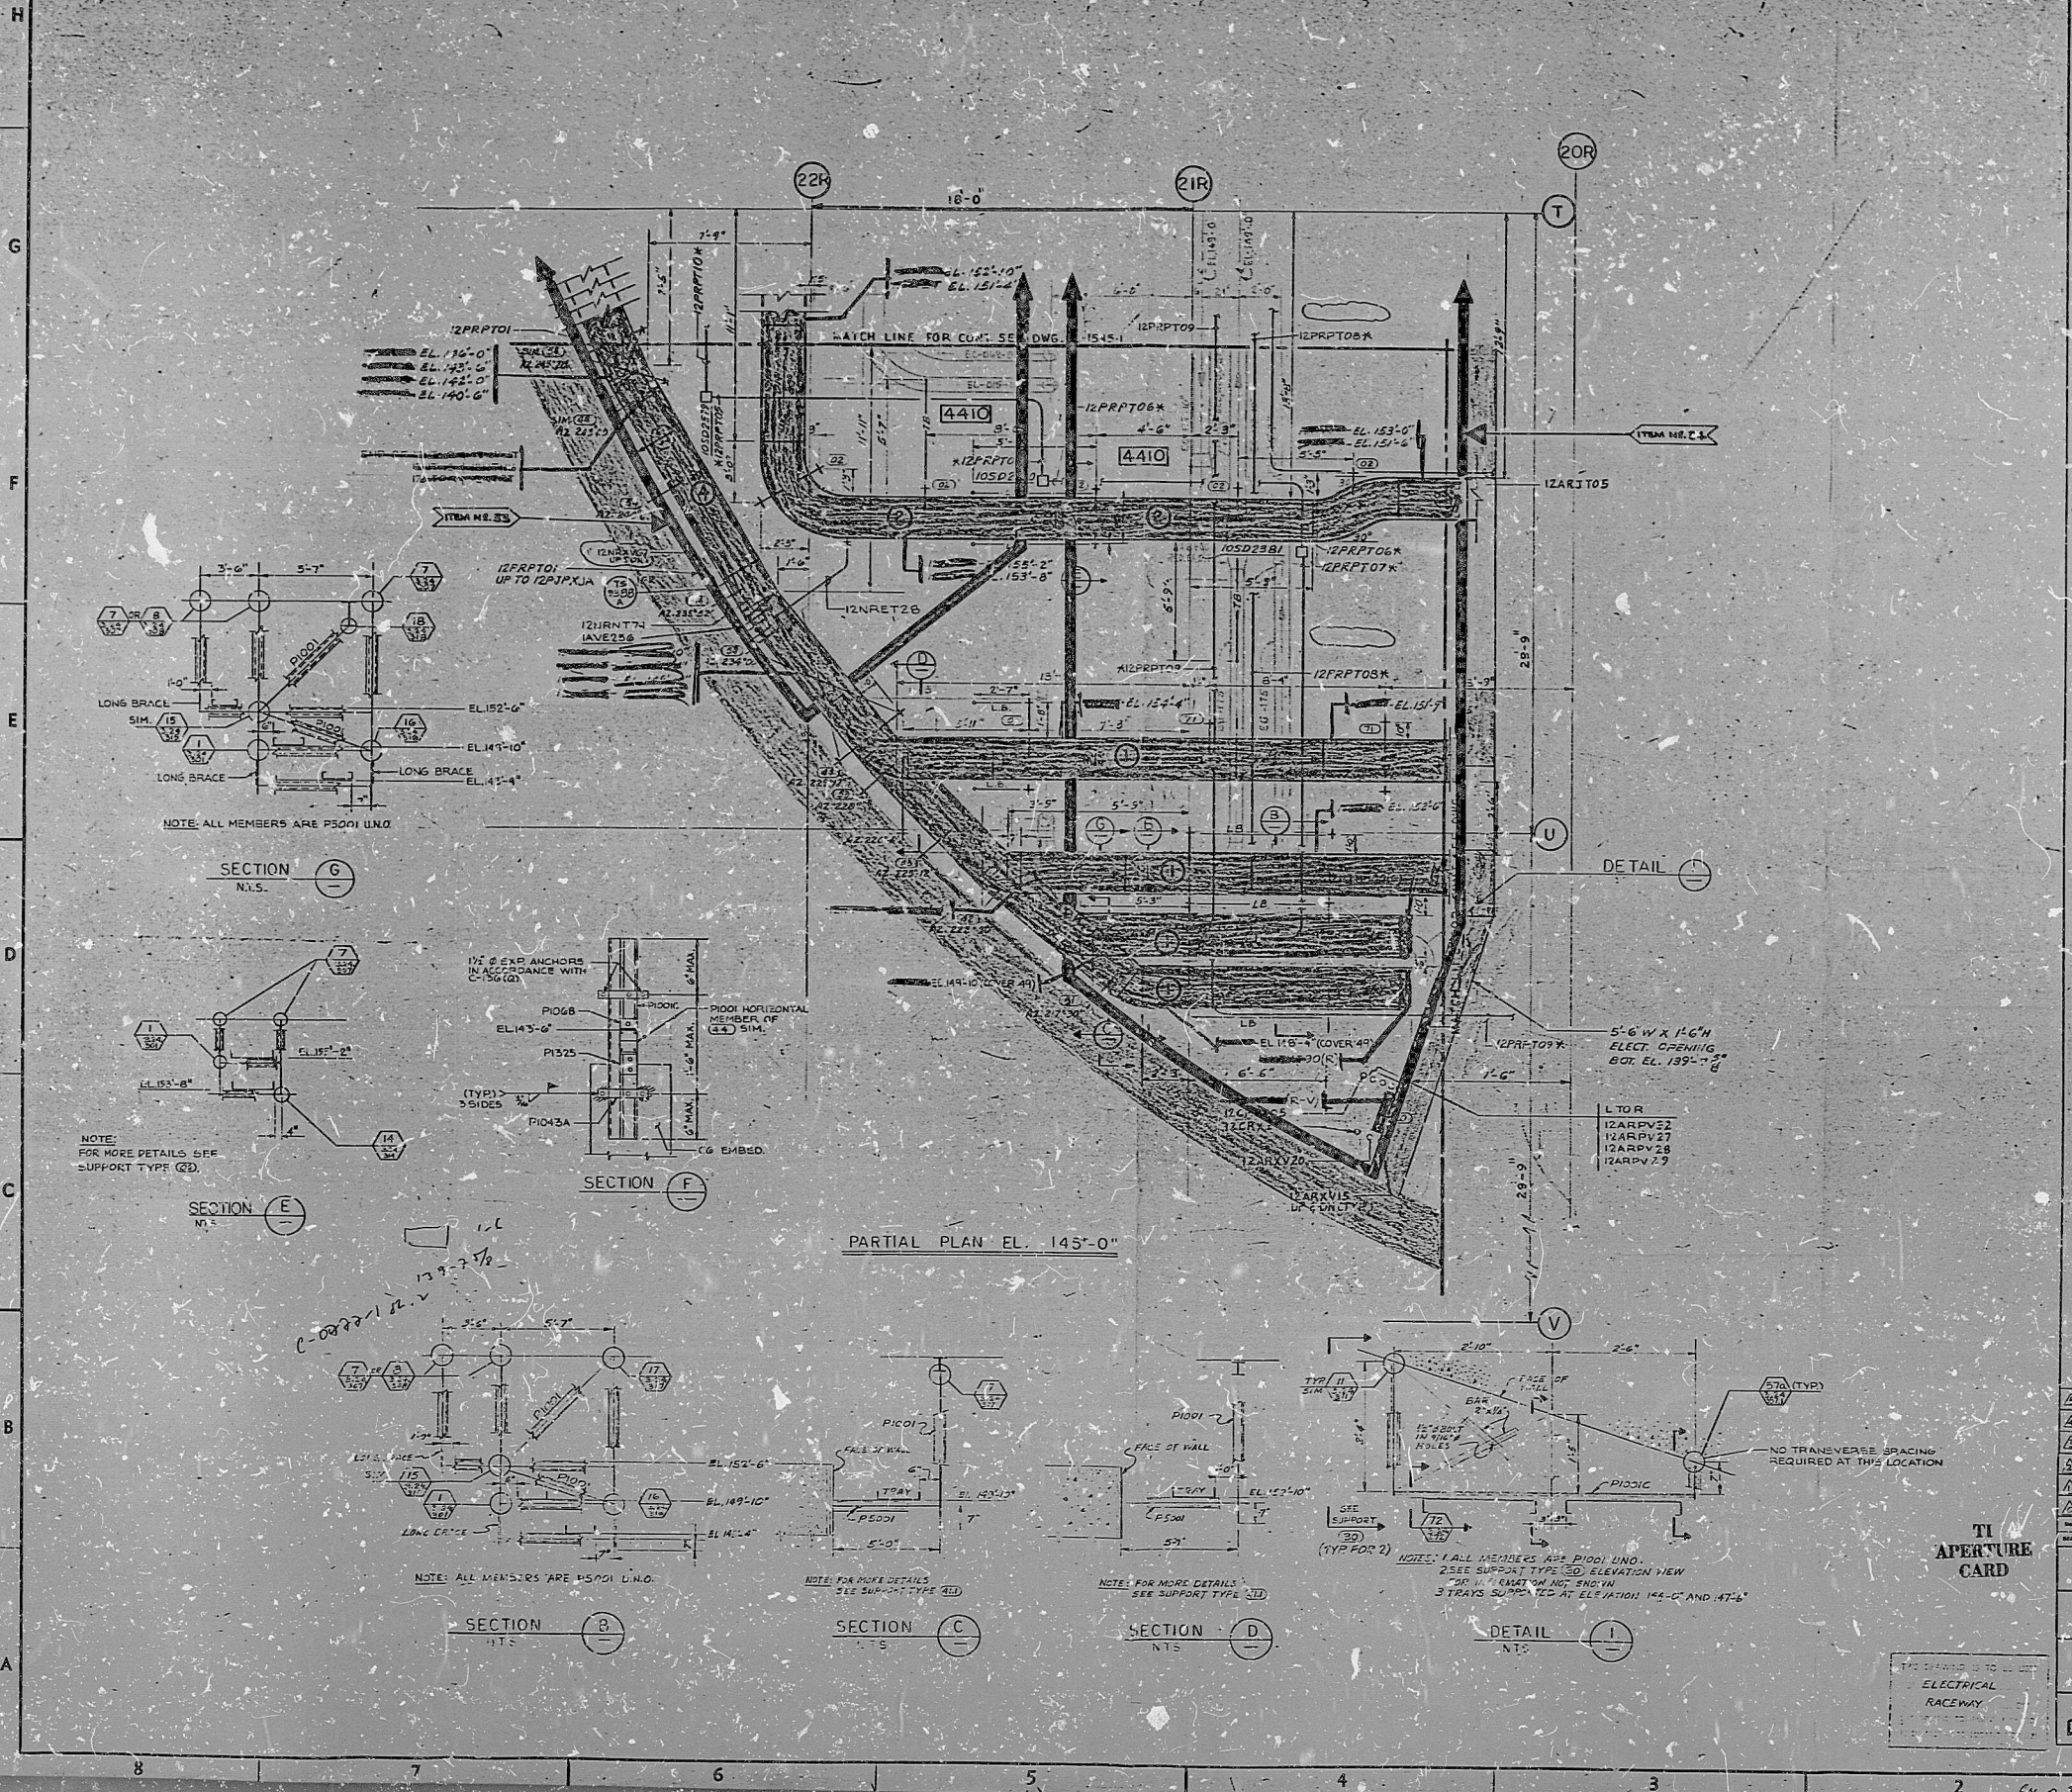

| OUTSIDE | 43 | 47 | 41 | 48 | 42 | 44 |
|---------|----|----|----|----|----|----|
| 45 | 47 | 45 | 43 | 41 | 39 | 37 |
| 39 | 37 | 35 | 33 | 31 | 29 | 27 |
| 27 | 25 | 23 | 21 | 19 | 17 | 15 |
| 15 | 13 | 11 | 9 | 7 | 5 | 3 |
| 3 | 1 | 1 | 1 | 1 | 1 | 1 |

PLANT KEY PLAN

- NOTES:
- ALL CABLE TRAYS ARE 24" UNLESS SHOWN OTHERWISE.
 - CLASS IE RACEWAY-TRAY & CONDUIT ETC. ARE IDENTIFIED FOR LISTED INSTALLATION BY LETTERS A, B, C, D, E, F, G, H, I, J, K, L, M, N, O, P, Q, R, S, T, U, V, W, X, Y, Z, IN THE THIRD CHARACTER OF THE RACEWAY NUMBER.
 - FOR INSTALLATION DETAIL OF NON-STANDARD ELBOWS FOR CABLE TRAYS, SEE DWG. E-1406-O, SH. 3.24.388.
 - ALL FIRE DETECTORS ARE MOUNTED ON THE CEILING.

- REFERENCE DRAWINGS:
- P-2105-1 - PIPING.
 - C-0833-1 - CIVIL-STRUCTURAL.
 - P-8215-1 - HEATING & VENTILATING.
 - F-8215-1 - PLUMBING.
 - E-1406-O - RACEWAY NOTES, SYMBOLS & DETAILS.
 - C-0809-1 - STRUCTURAL STEEL FLOOR FRAMING PLAN.

| NO. | DESCRIPTION | DATE | BY | CHECKED |
|-----|-------------------------|----------|--------------|--------------|
| 1 | ISSUED FOR CONSTRUCTION | 11/28/54 | J. H. HARRIS | J. H. HARRIS |
| 2 | REVISION | | | |
| 3 | REVISION | | | |
| 4 | REVISION | | | |
| 5 | REVISION | | | |

BECHTEL
SAN FRANCISCO

PUBLIC SERVICE ELECTRIC AND GAS COMPANY
HOPE CREEK GENERATING STATION

RACEWAY PLAN
REACTOR BUILDING-AREA 21
PLAN EL 145'-0"

JOB NO. 13855 DRAWING NO. E-1575-1-5

TI
APERTURE
CARD

22"
17"
11"
8.5"
11"
17"
22"

22"
17"
11"
8.5"
11"
17"
22"

5-A-1115 17.25.54

PDR RIDS

8409048366

