


No. 10080-RE-37BJ

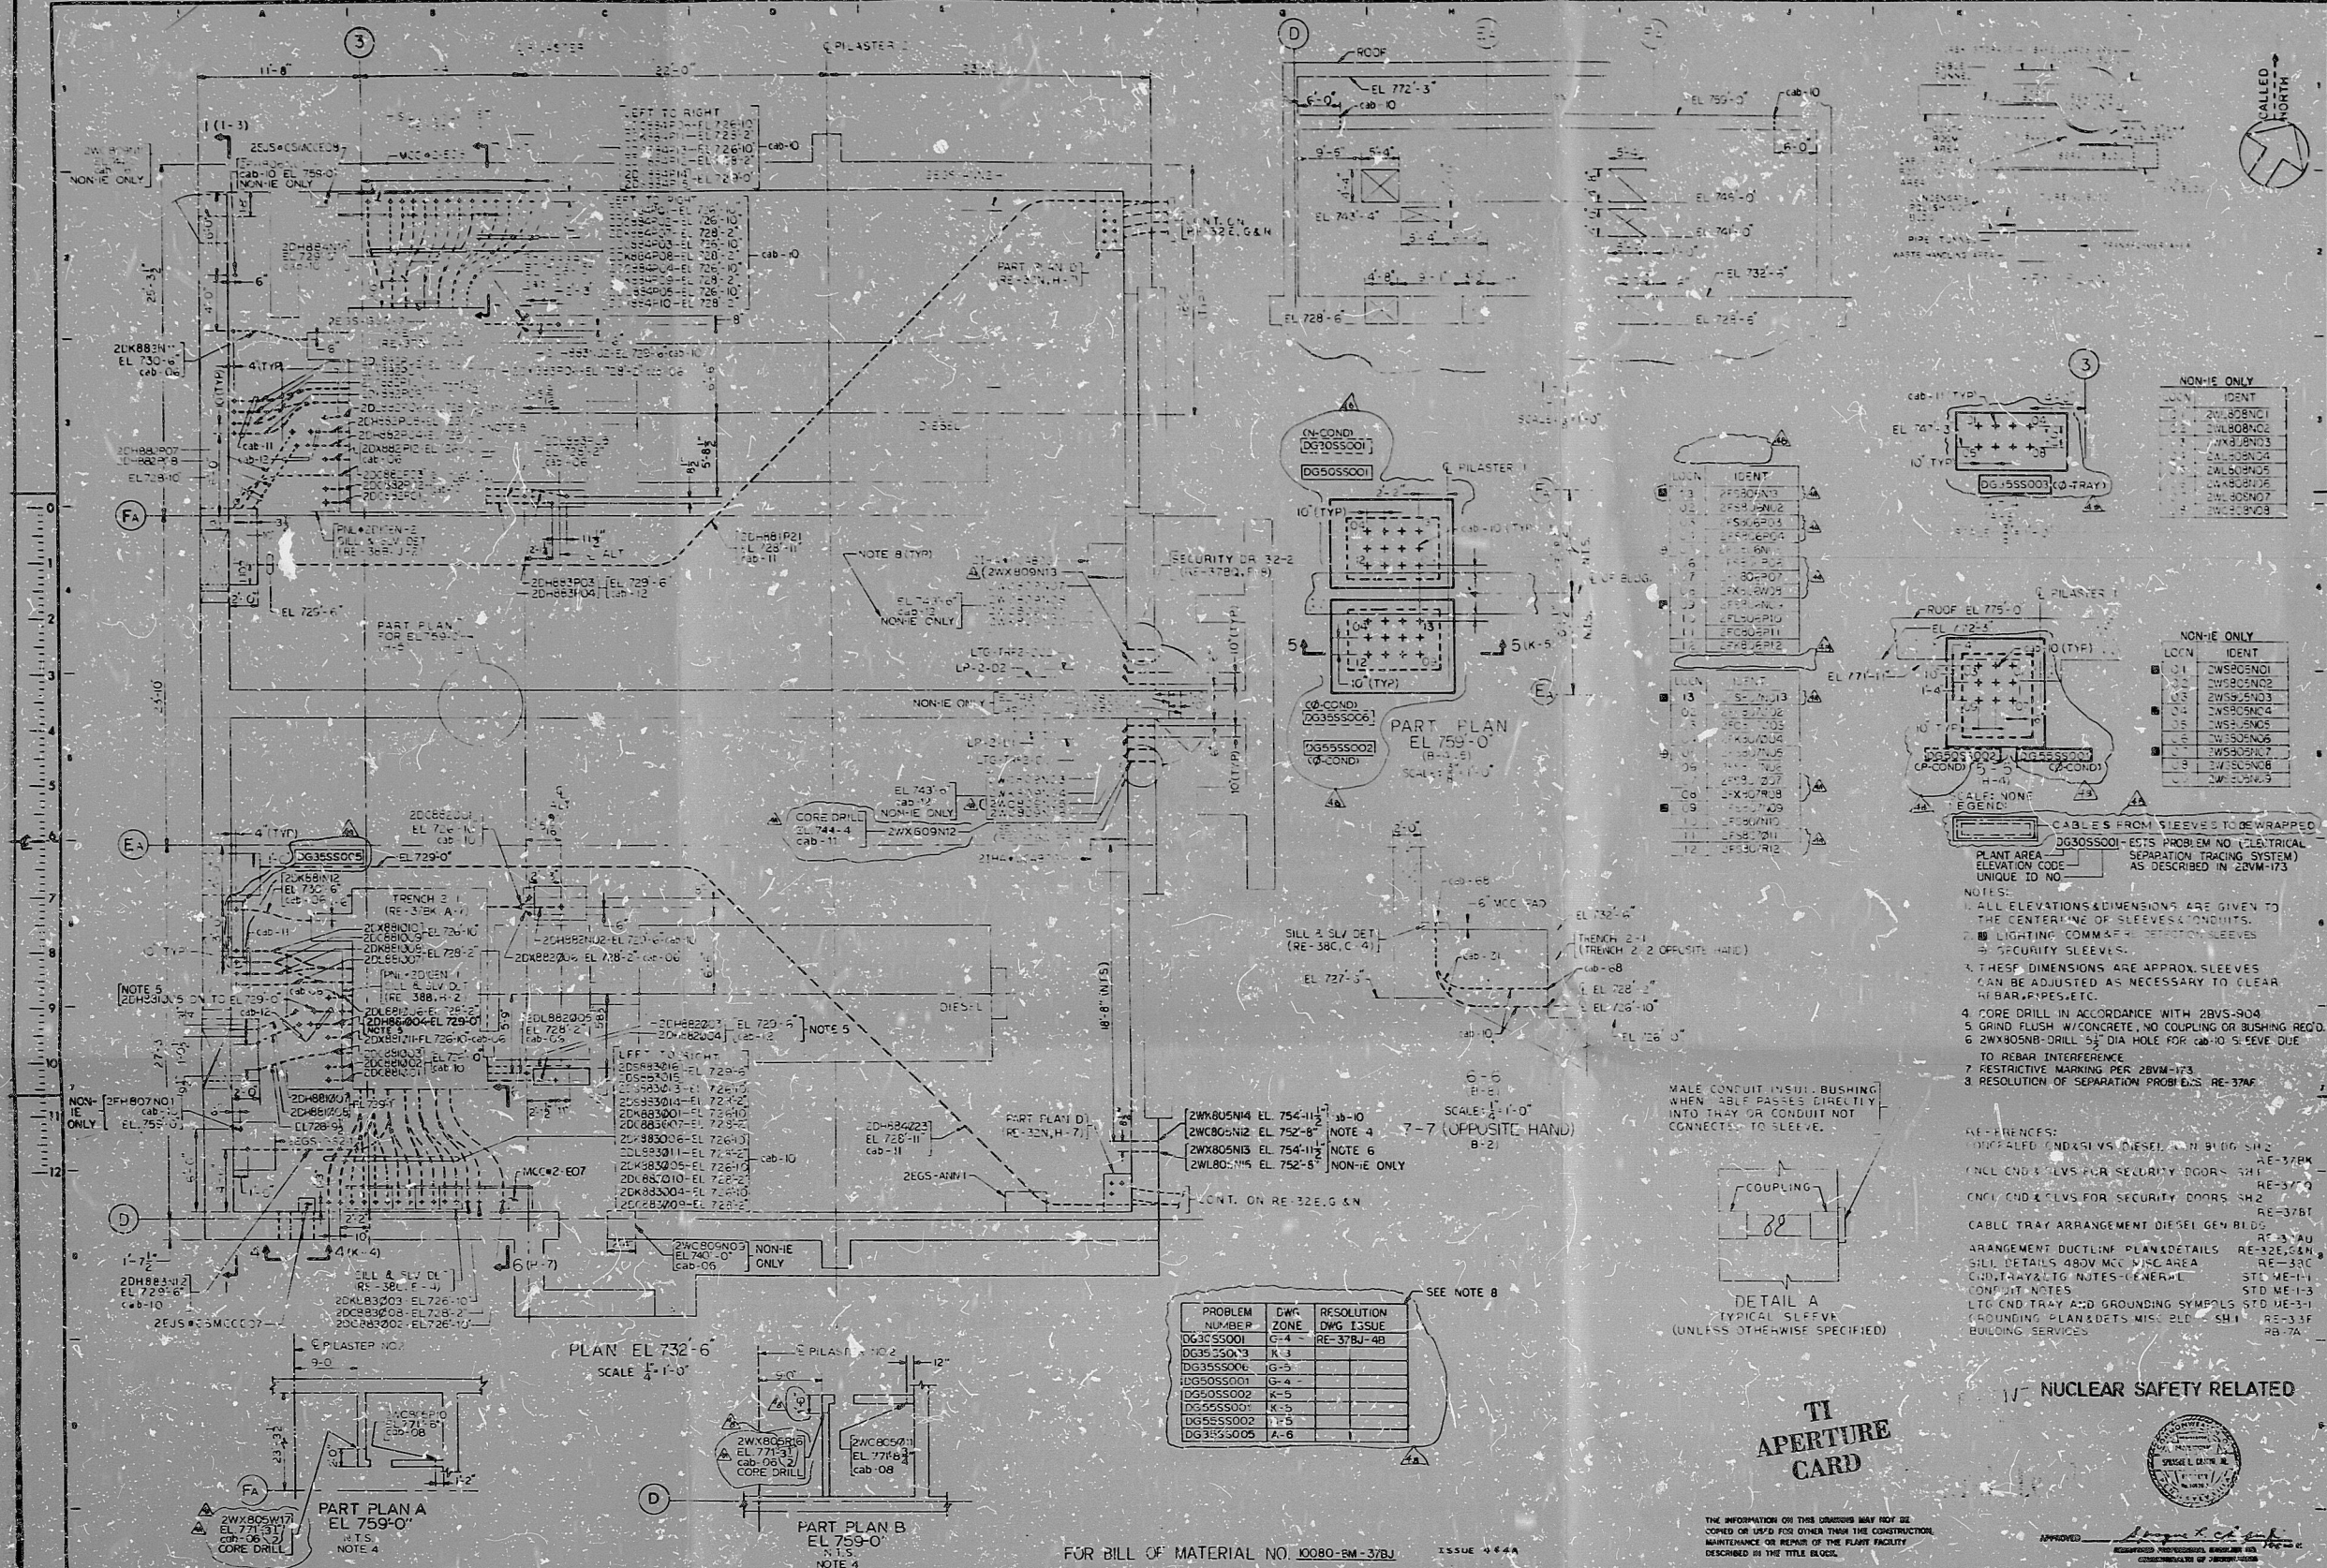

NON-IE ONLY

LOCN	IDENT
01	2WXB08N01
02	2WXB08N02
03	2WXB08N03
04	2WXB08N04
05	2WXB08N05
06	2WXB08N06
07	2WXB08N07

NON-IE ONLY

LOCN	IDENT
01	2WXB08N01
02	2WXB08N02
03	2WXB08N03
04	2WXB08N04
05	2WXB08N05
06	2WXB08N06
07	2WXB08N07

- PLANT AREA ELEVATION CODE UNIQUE ID NO.
- NOTES:
1. ALL ELEVATIONS AND DIMENSIONS ARE GIVEN TO THE CENTERLINE OF SLEEVES AND CONDUITS.
 2. LIGHTING COMM-FR DETECTION SLEEVES ARE SECURITY SLEEVES.
 3. THESE DIMENSIONS ARE APPROX. SLEEVES CAN BE ADJUSTED AS NECESSARY TO CLEAR REBAR, PIPES, ETC.
 4. CORE DRILL IN ACCORDANCE WITH 28VM-904
 5. GRIND FLUSH W/CONCRETE, NO COUPLING OR BUSHING REQD.
 6. 2WXB08N01-DRILL 5/8" DIA HOLE FOR CAB-10 S. SEVE DUE TO REBAR INTERFERENCE
 7. RESTRICTIVE MARKING PER 28VM-173
 8. RESOLUTION OF SEPARATION PROBLEMS RE-37AF

- REFERENCES:
- 1. 28VM-173 DIESEL GEN BLDG SH-2 RE-37BK
 - 2. INCL CONDUITS FOR SECURITY DOORS SH-1 RE-37C
 - 3. CND TRAY ARRANGEMENT DIESEL GEN BLDG RE-37BT
 - 4. CABLE TRAY ARRANGEMENT DIESEL GEN BLDG RE-37AU
 - 5. ARRANGEMENT DUCTLINE PLANS DETAILS RE-32E, G, H
 - 6. SILL DETAILS 480V MCC W/SC AREA RE-38C
 - 7. CND TRAY & LIG NOTES-GENERAL STD ME-14
 - 8. CONDUIT NOTES STD ME-13
 - 9. LIG CND TRAY AND GROUNDING SYMBOLS STD ME-31
 - 10. GROUNDING PLANS & DETS MIS. PLS. SH-1 RE-33F
 - 11. BUILDING SERVICES RB-7A

TI APERTURE CARD



APPROVED: [Signature]

FOR BILL OF MATERIAL NO. 10080-BM-37BJ ISSUE 444A

SEE NOTE B

PROBLEM NUMBER	DWG ZONE	RESOLUTION DWG ISSUE
DG355001	G-4	RE-37BU-4B
DG355003	K-3	
DG355004	G-5	
DG355005	G-6	
DG355006	K-5	
DG355007	K-5	
DG355008	K-5	
DG355009	A-6	

REV	NO	DATE	BY	CHKD	DESCRIPTION
1	1	12-17-76	AS	AS	ISSUE AS SHOWN
2	2	12-17-76	AS	AS	ISSUE AS SHOWN
3	3	12-17-76	AS	AS	ISSUE AS SHOWN
4	4	12-17-76	AS	AS	ISSUE AS SHOWN
5	5	12-17-76	AS	AS	ISSUE AS SHOWN
6	6	12-17-76	AS	AS	ISSUE AS SHOWN
7	7	12-17-76	AS	AS	ISSUE AS SHOWN
8	8	12-17-76	AS	AS	ISSUE AS SHOWN
9	9	12-17-76	AS	AS	ISSUE AS SHOWN
10	10	12-17-76	AS	AS	ISSUE AS SHOWN
11	11	12-17-76	AS	AS	ISSUE AS SHOWN
12	12	12-17-76	AS	AS	ISSUE AS SHOWN
13	13	12-17-76	AS	AS	ISSUE AS SHOWN
14	14	12-17-76	AS	AS	ISSUE AS SHOWN
15	15	12-17-76	AS	AS	ISSUE AS SHOWN
16	16	12-17-76	AS	AS	ISSUE AS SHOWN
17	17	12-17-76	AS	AS	ISSUE AS SHOWN
18	18	12-17-76	AS	AS	ISSUE AS SHOWN
19	19	12-17-76	AS	AS	ISSUE AS SHOWN
20	20	12-17-76	AS	AS	ISSUE AS SHOWN

5&W DWG. NO. 1221-RE-37BJ-4B

8409210286

PDR RIDS

8409210286

