



M-02DA02

This drawing and its design is the property of the design firm and shall not be reproduced, copied, or used in any way without the written consent of the design firm. It is intended for use in the design of the project only and shall not be used for any other purpose.

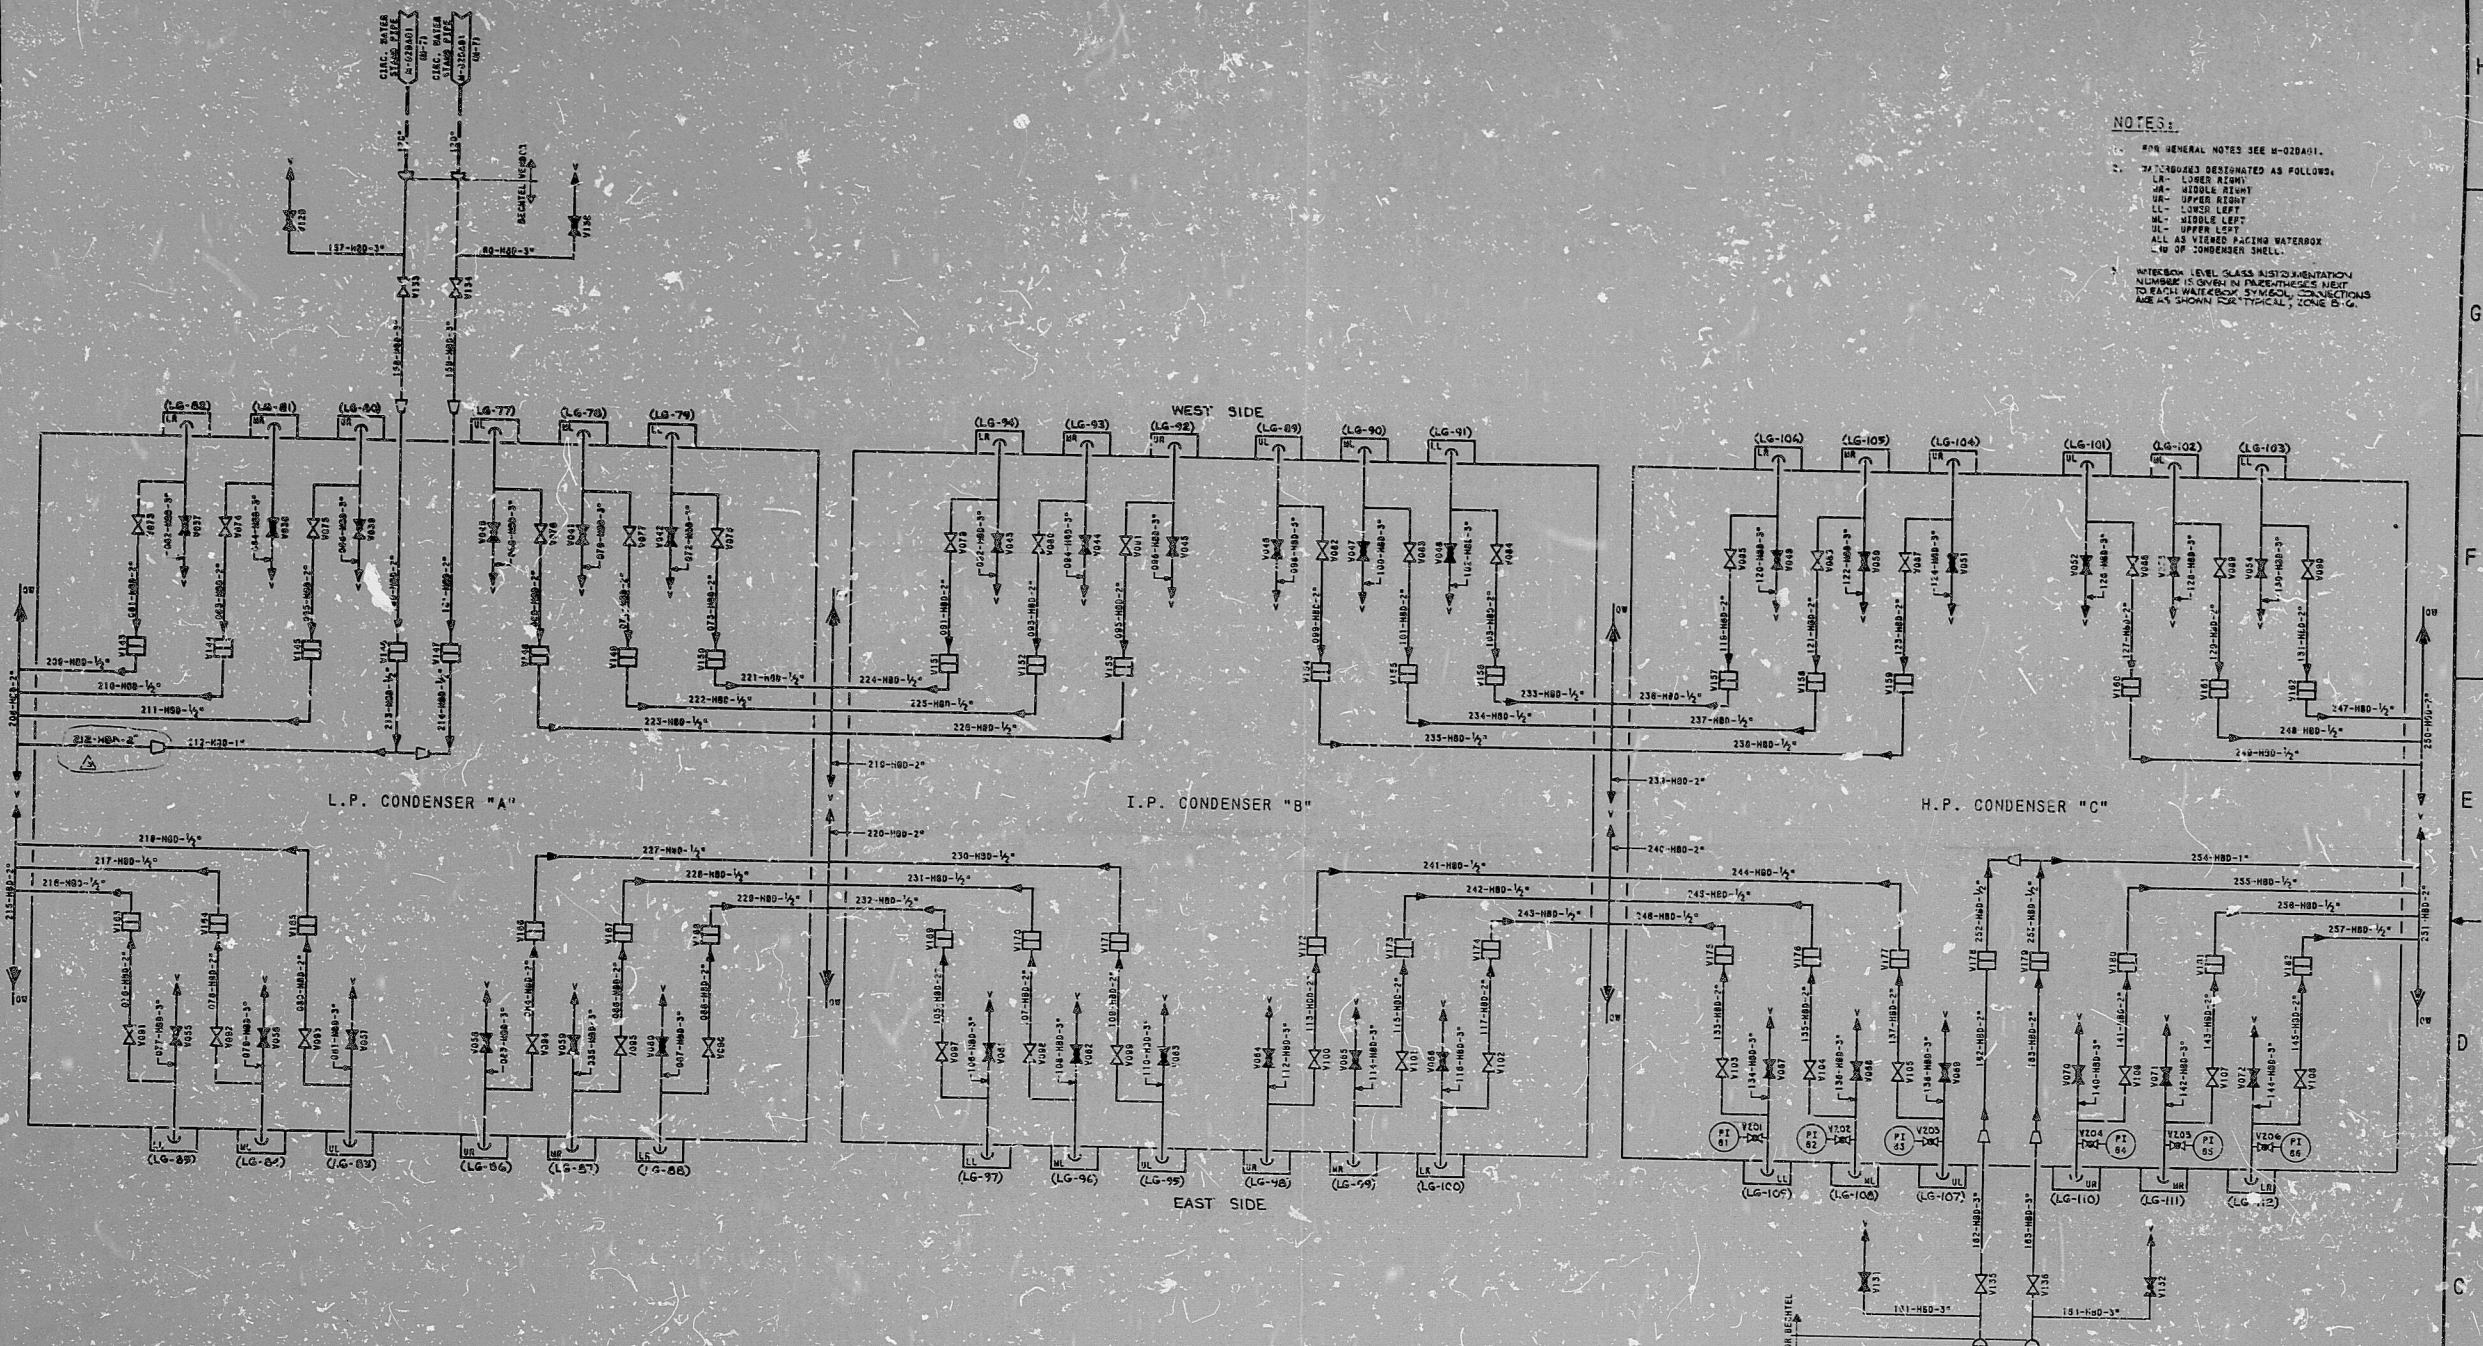

NOTES:
1. GENERAL NOTES SEE M-02DA01.
2. VALVES DESIGNATED AS FOLLOWS:
LR - LOWER RIGHT
UR - UPPER RIGHT
LL - LOWER LEFT
UL - UPPER LEFT
ALL AS VIEWED FACING WATERBOX
END OF CONDENSER SHELL.
3. WATERBOX LEVEL GLASS INSTRUMENTATION
NUMBER IS SHOWN IN PARENTHESIS NEXT
TO EACH WATERBOX SYMBOL. CONNECTIONS
ARE AS SHOWN FOR TYPICAL CASES.

CONDENSER	WATERBOX DESIGNATOR	VALVE NO.	LEVEL INSTRUMENT NO. (LG)	WATERBOX DESIGNATOR	VALVE NO.	LEVEL INSTRUMENT NO. (LG)
L.P. CONDENSER "A"	LR (W)	723.723	LG-81	LL (E)	723.723	LG-82
	MR (W)	723.723	LG-81	ML (E)	723.723	LG-83
	UR (W)	723.723	LG-81	UL (E)	723.723	LG-84
	UL (W)	723.723	LG-81	UR (E)	723.723	LG-85
I.P. CONDENSER "B"	LR (W)	723.723	LG-81	LL (E)	723.723	LG-82
	MR (W)	723.723	LG-81	ML (E)	723.723	LG-83
	UR (W)	723.723	LG-81	UL (E)	723.723	LG-84
	UL (W)	723.723	LG-81	UR (E)	723.723	LG-85
H.P. CONDENSER "C"	LR (W)	723.723	LG-81	LL (E)	723.723	LG-82
	MR (W)	723.723	LG-81	ML (E)	723.723	LG-83
	UR (W)	723.723	LG-81	UL (E)	723.723	LG-84
	UL (W)	723.723	LG-81	UR (E)	723.723	LG-85

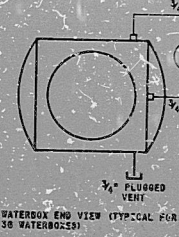


WATERBOX END VIEW (TYPICAL FOR
30 WATERBOXES)

COORDINATION SIGN	DATE	BY	CHKD
DESIGN	10/1/77	W. J. H.	W. J. H.
CHKD	10/1/77	W. J. H.	W. J. H.
APP'D	10/1/77	W. J. H.	W. J. H.

TI
APERTURE
CARD

NO.	DATE	REVISED	DATE	BY	CHKD
10466	10/1/77	1	10/1/77	W. J. H.	W. J. H.
SCALE: NO. 1:100 (DATE 10/1/77) DESIGNER: W. J. H. DRAWN: W. J. H.					
DECHTEL WATERBOX END VIEW					
SNUPPS					
PIPING AND INSTRUMENTATION DIAGRAM CIRCULATING WATER WATERBOX VENTING SYSTEM					
WATERBOX END VIEW NO.					
JOB NO.					
PROJECT NO.					
DRAWING NO.					
REVISIONS					
REVISION NO.					
DATE					
BY					
CHKD					

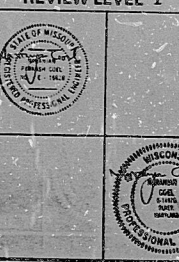

THE ENGINEER HEREBY CERTIFIES THAT HE IS A LICENSED PROFESSIONAL ENGINEER AND THAT HE HAS PREPARED THIS DRAWING AND THAT HE IS A MEMBER OF THE PROFESSIONAL ENGINEERS SOCIETY OF THE STATE OF CALIFORNIA.

I certify that the design contained on this drawing was made in the normal and regular course of business, on the date stated below and that it is a true and correct copy of the original design.

PDR RIDS

8409280194

