


2510H-H

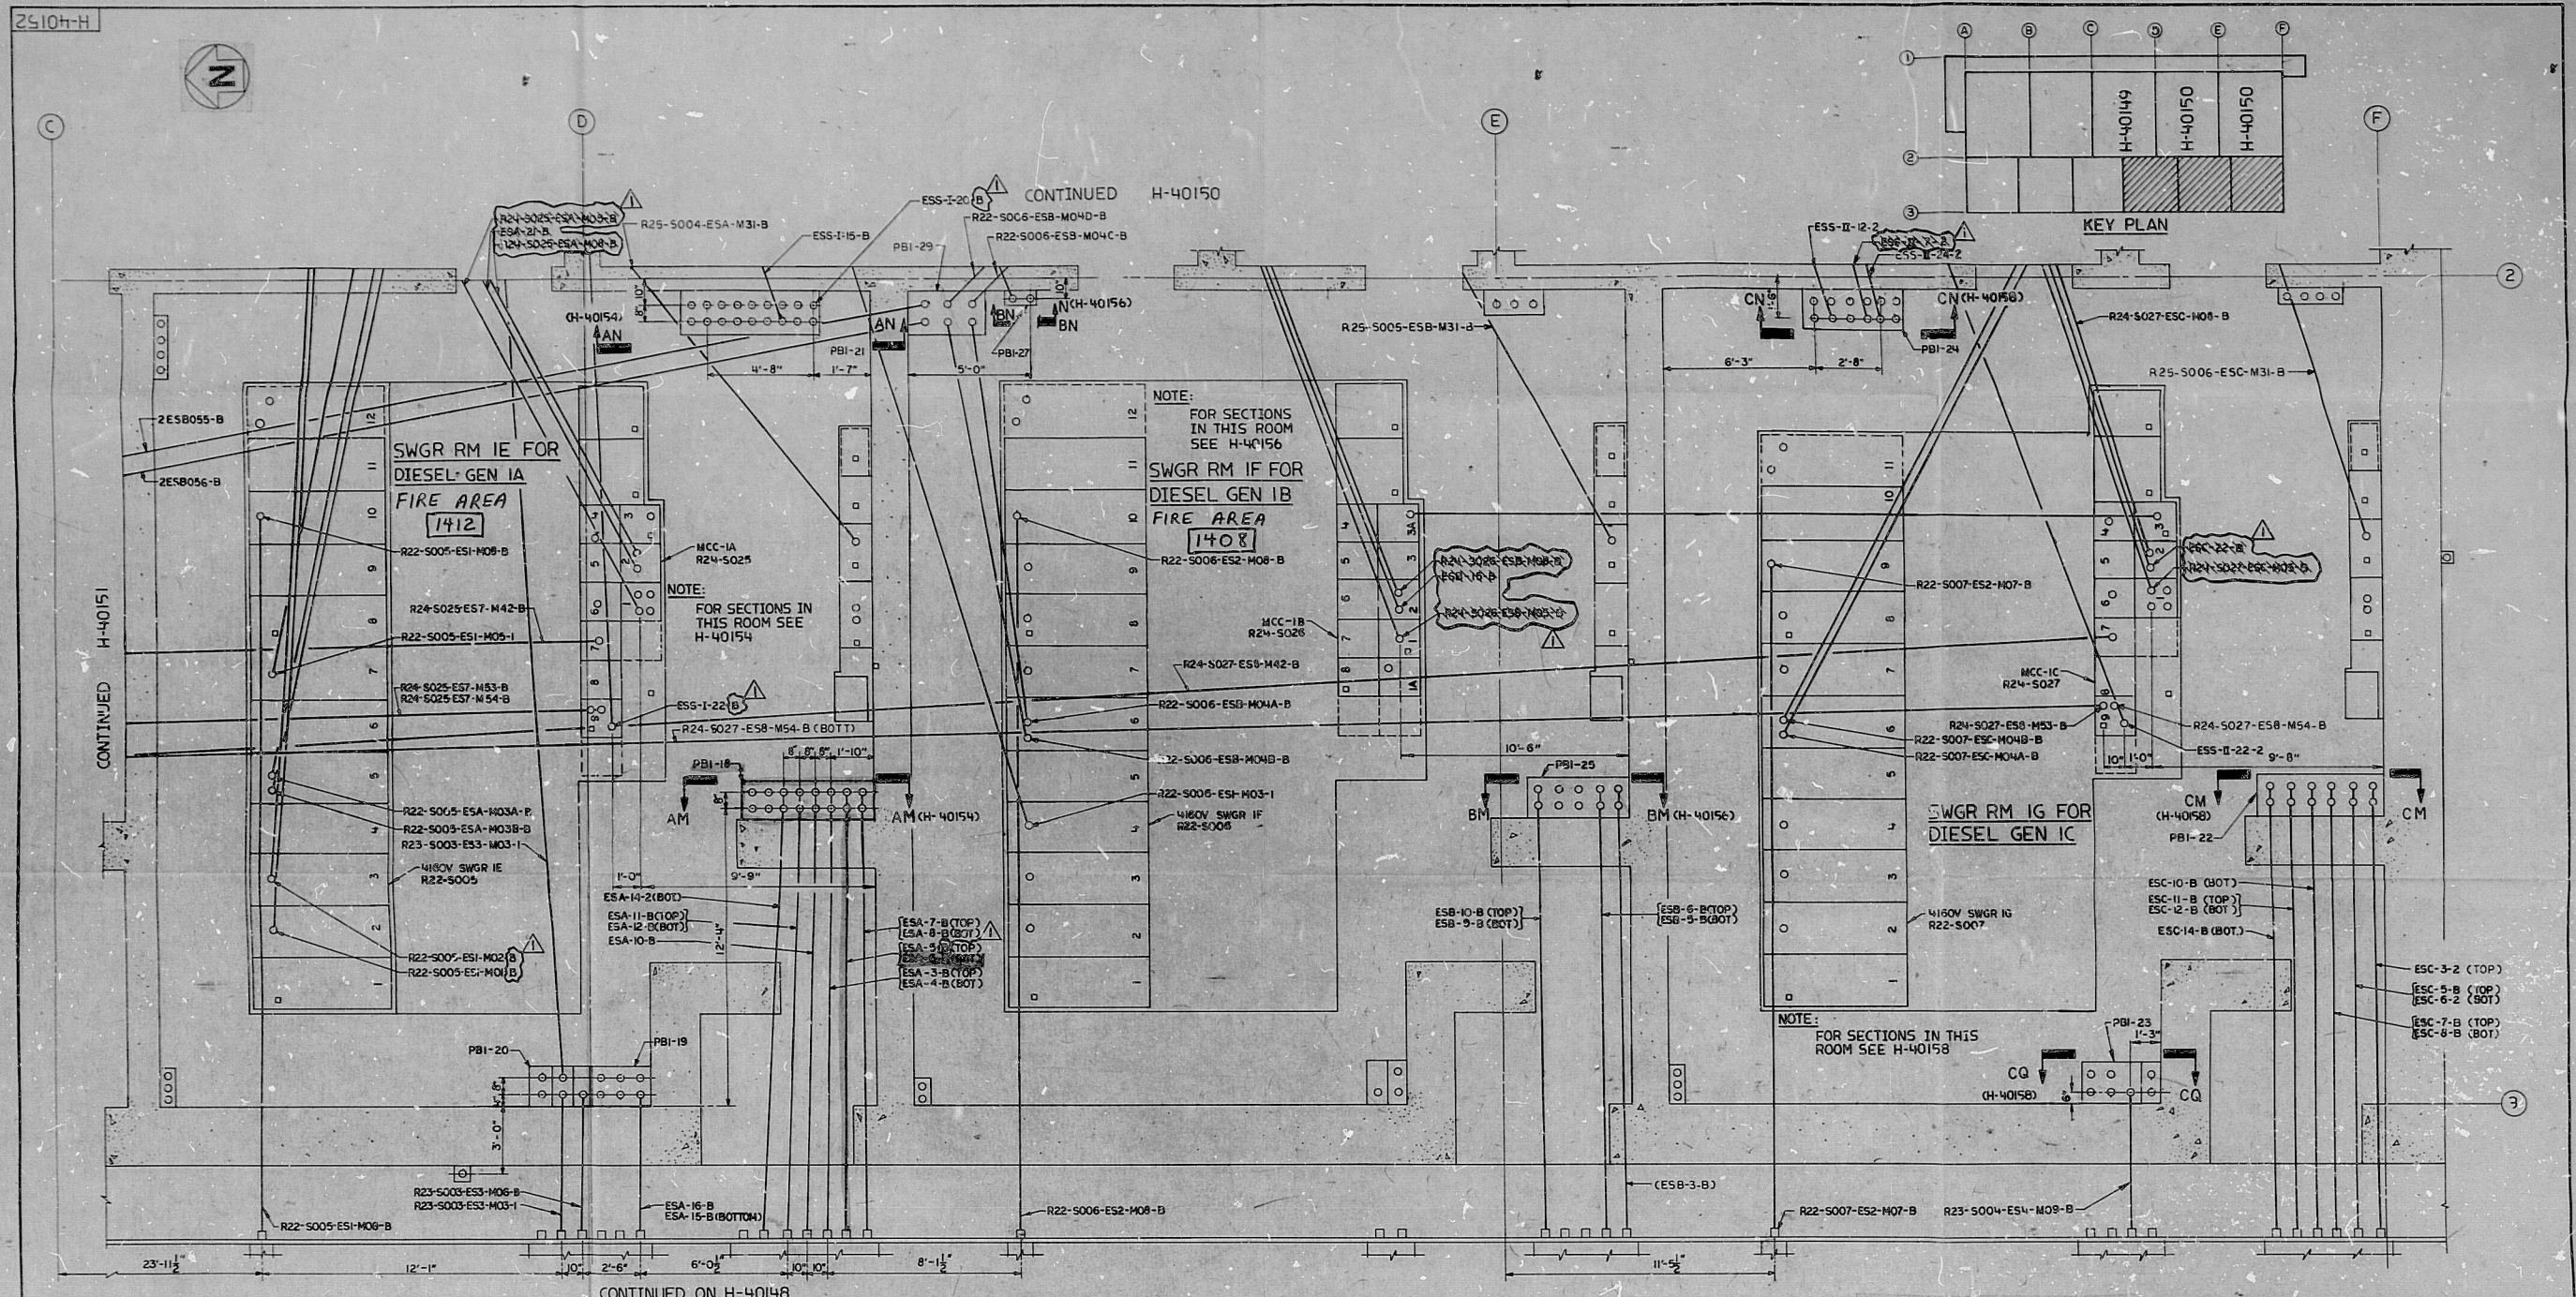

PRELIMINARY

APERTURE
CARD

CIRCUIT RACEWAYS
R22-5005-ES7-M08-B PBI-18 6 ESB-10-B

REVISION	DATE	REVISION	DATE
1	9-30-95	2	9-30-95
BY: SML	CK'D: RBN	BY: SML	CK'D: RBN
APPR: RBN	APPR: RBN	APPR: RBN	APPR: RBN

REFERENCES:

- H-40144 CONDUIT & GROUNDING-DIESEL GEN. BLDG. GEN. ROOM FLOOR PLAN
- H-40145 APPX "R" RACEWAYS-DIESEL GEN. 1A
- H-40146 " " " " 1B
- H-40147 " " " " 1C
- H-40148 " " " " 1A EMBEDDED
- H-40150 APPX "R" RACEWAYS-DIESEL GEN. 1B & 1C EMBEDDED
- H-40151 APPX "R" RACEWAYS-SWGR. ROOM DIESEL GEN. BLDG. EMBEDDED SH 1 OF 2
- H-40153-58 APPX "R" RACEWAYS-DIESEL GEN. 1A, 1B & 1C SECTIONS

MPL NO. R33
Southern Company Services, Inc. FOR
Georgia Power Company, Atlanta, Ga.
General Engineering Department

EDWIN I HATCH NUCLEAR PLANT-UNIT NO. 1
APPENDIX "R" PATH 1 & PATH 2 RACEWAYS
SWGR. RM. DSL. GEN. BLDG.-EMBEDDED SH2 OF 2

APPROVALS: *[Signature]* DATE: 9-30-95
SCALE: 3/8"=1'-0"
DRAWING NUMBER: 10-502 H-40152
SHEET NO.: 86111802B1

PDRIDS

8611180281

