




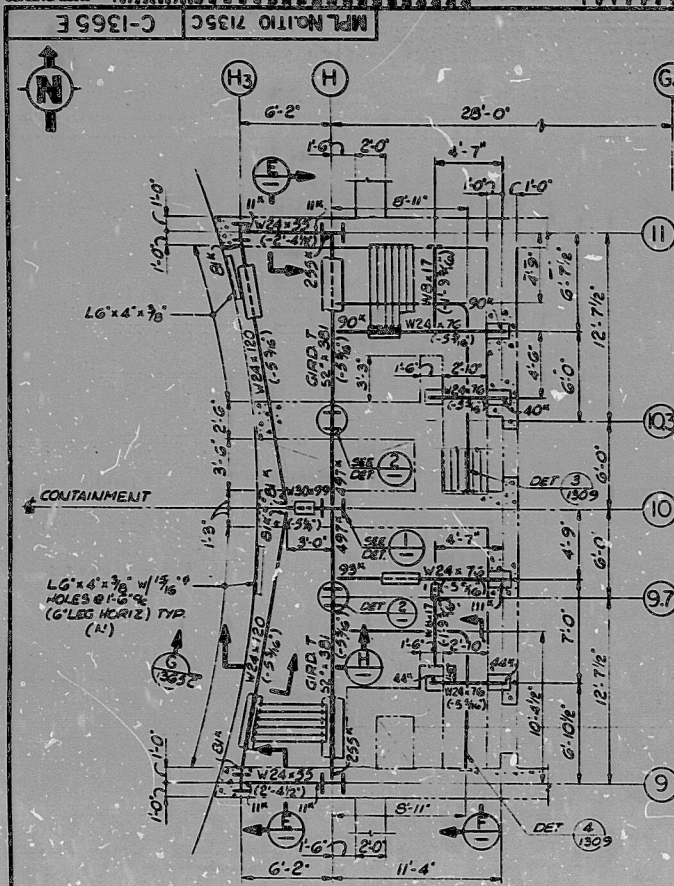

PARTIAL STEEL FRAMING PLAN - RVCU PUMP ROOF
EL 125'-0"
SCALE 1/8" = 1'-0"
SEE DWGS, C-1361, C-1362, C-1365A, C-1366

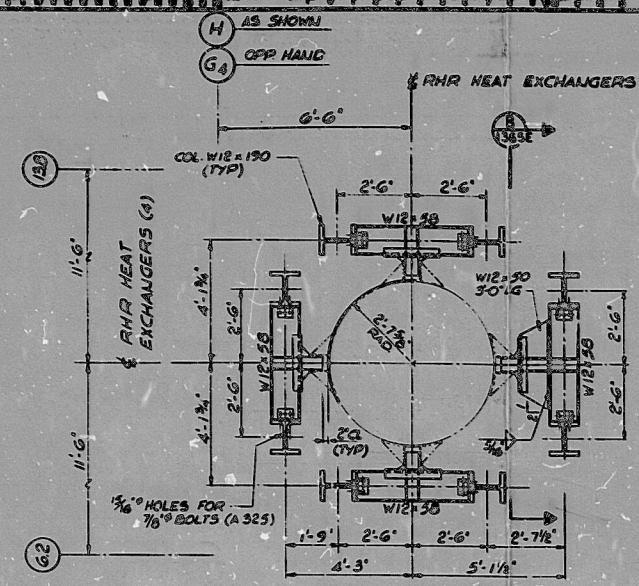


SECTION PLAN
SCALE 1/8" = 1'-0"
2 PLACES - AS SHOWN
2 PLACES - OFF HAND
SEE DWGS, C-1361, C-1362, C-1365A, C-1366

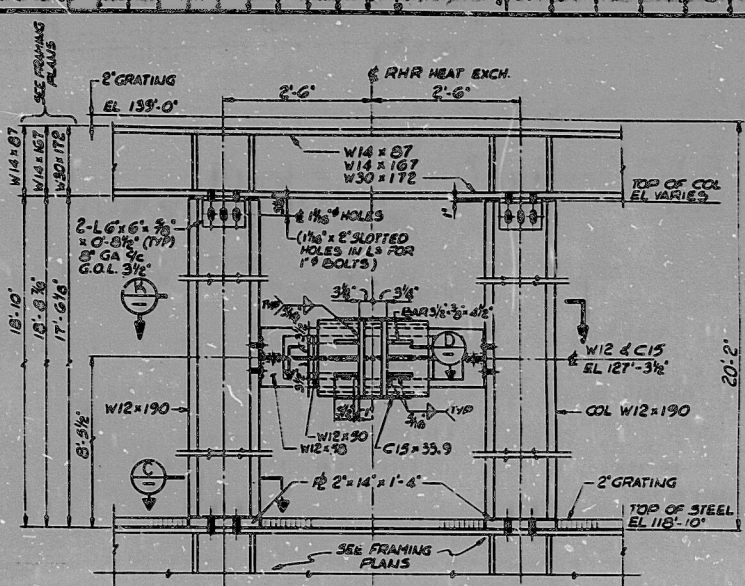


ELEVATION
SCALE 1/8" = 1'-0"
TYP 4 SIDES
SEE DWGS C-1361, C-1362, C-1365, C-1366


NOTES
1. FOR GENERAL NOTES SEE DWG C-1355 A
2. SEE NOTES #4, #5, #6, #7, #9, #10 ON DWG C-1361
3. ANY ATTACHMENT TO RHR HEAT EXCHANGER'S SUPPORT IS NOT PERMITTED WITHOUT PROJECT ENGINEERING APPROVAL.

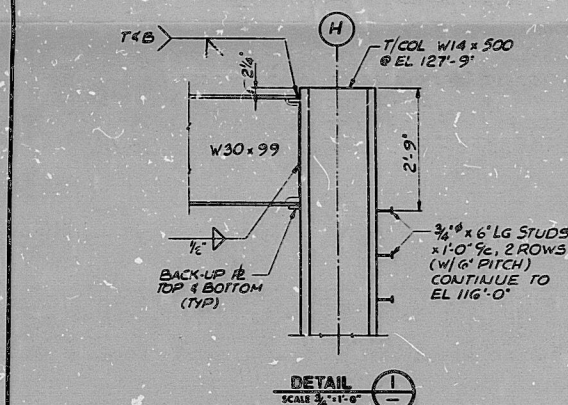


DETAIL
SCALE 3/8" = 1'-0"

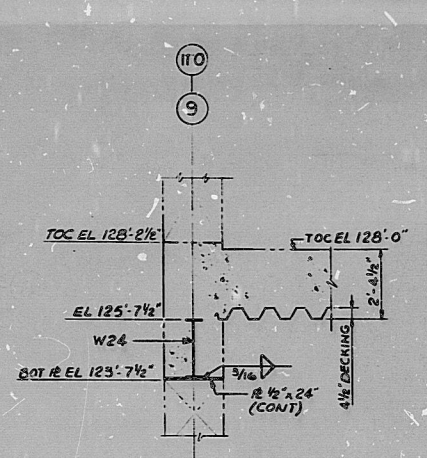


SECTION
SCALE 3/8" = 1'-0"

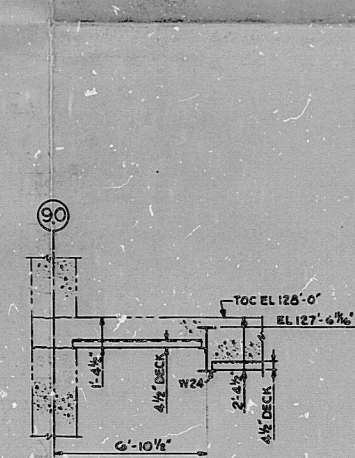


SECTION
SCALE 3/8" = 1'-0"

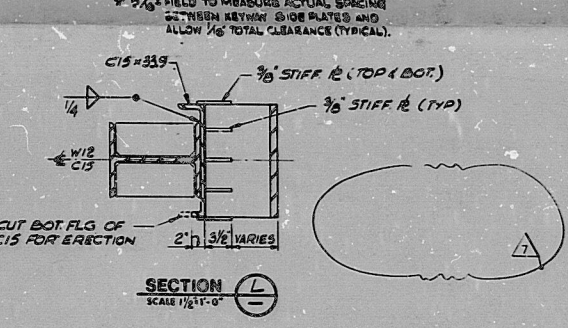


SECTION
SCALE 3/8" = 1'-0"

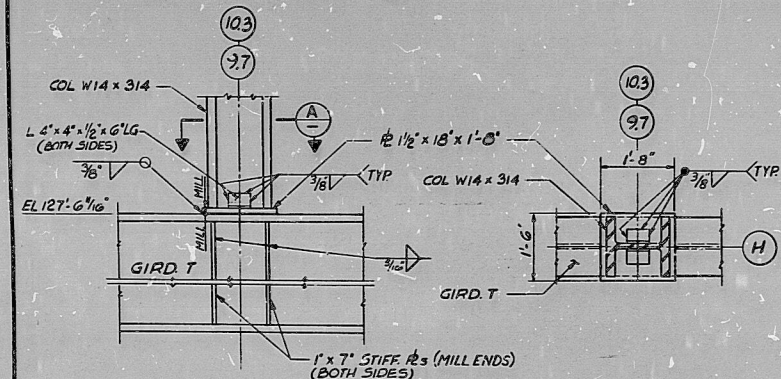

DETAIL
SCALE 3/8" = 1'-0"

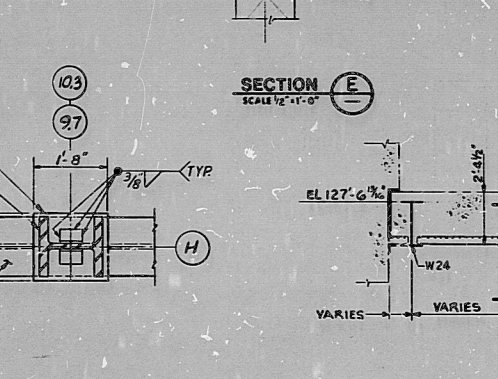

SECTION
SCALE 3/8" = 1'-0"

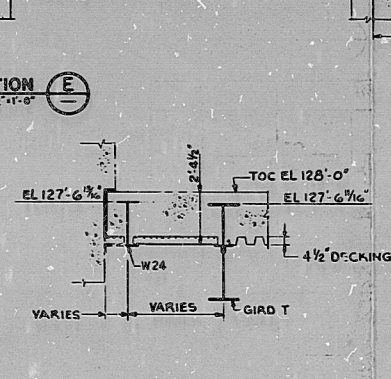

SECTION
SCALE 3/8" = 1'-0"

REFERENCE DRAWINGS
C-1355A COLUMN SCHEDULE
C-1361 FRAMING PLAN; EL 115'-0" AREA 7
C-1362 FRAMING PLAN; EL 115'-0" AREA 8
C-1365A FRAMING PLAN; EL 135'-0" AREA 7
C-1366 FRAMING PLAN; EL 135'-0" AREA 8

ALL STEEL DECKING IS NON 'Q'

NO.	DESCRIPTION	DATE	BY	CHKD
1	ADD NOTE #3 & 4, NOTE ON SECTION	7-1-75	RE	RE
2	REV EL 6 SECTS D&L	7-1-75	RE	RE
3	ADD SECT L RHY MEMBER	7-1-75	RE	RE
4	REV EL 6 SECT L	7-1-75	RE	RE
5	ADD SECT L RHY MEMBER	7-1-75	RE	RE
6	ADD SECT L RHY MEMBER	7-1-75	RE	RE
7	ADD SECT L RHY MEMBER	7-1-75	RE	RE
8	ADD SECT L RHY MEMBER	7-1-75	RE	RE
9	ADD SECT L RHY MEMBER	7-1-75	RE	RE
10	ADD SECT L RHY MEMBER	7-1-75	RE	RE
11	ADD SECT L RHY MEMBER	7-1-75	RE	RE
12	ADD SECT L RHY MEMBER	7-1-75	RE	RE
13	ADD SECT L RHY MEMBER	7-1-75	RE	RE
14	ADD SECT L RHY MEMBER	7-1-75	RE	RE
15	ADD SECT L RHY MEMBER	7-1-75	RE	RE
16	ADD SECT L RHY MEMBER	7-1-75	RE	RE
17	ADD SECT L RHY MEMBER	7-1-75	RE	RE
18	ADD SECT L RHY MEMBER	7-1-75	RE	RE
19	ADD SECT L RHY MEMBER	7-1-75	RE	RE
20	ADD SECT L RHY MEMBER	7-1-75	RE	RE

BECHTEL
BATHING, MARYLAND
MISSISSIPPI POWER & LIGHT COMPANY
GRAND OAK NUCLEAR STATION
UNIT 1 AUXILIARY BUILDING
STRUCTURAL STEEL
PLANS, SECTIONS AND DETAILS
JOB NO. 9645- DRAWING NO. C-1365 E REV. 7
3-6-75 1 3/4" 1" SIZE

SUPERVISOR APR 79 CAMERA OPERATOR J. N. Zuck

MPL No. 1710 7135 C

8701070093

PDR

8701070093

