


E-1863-1

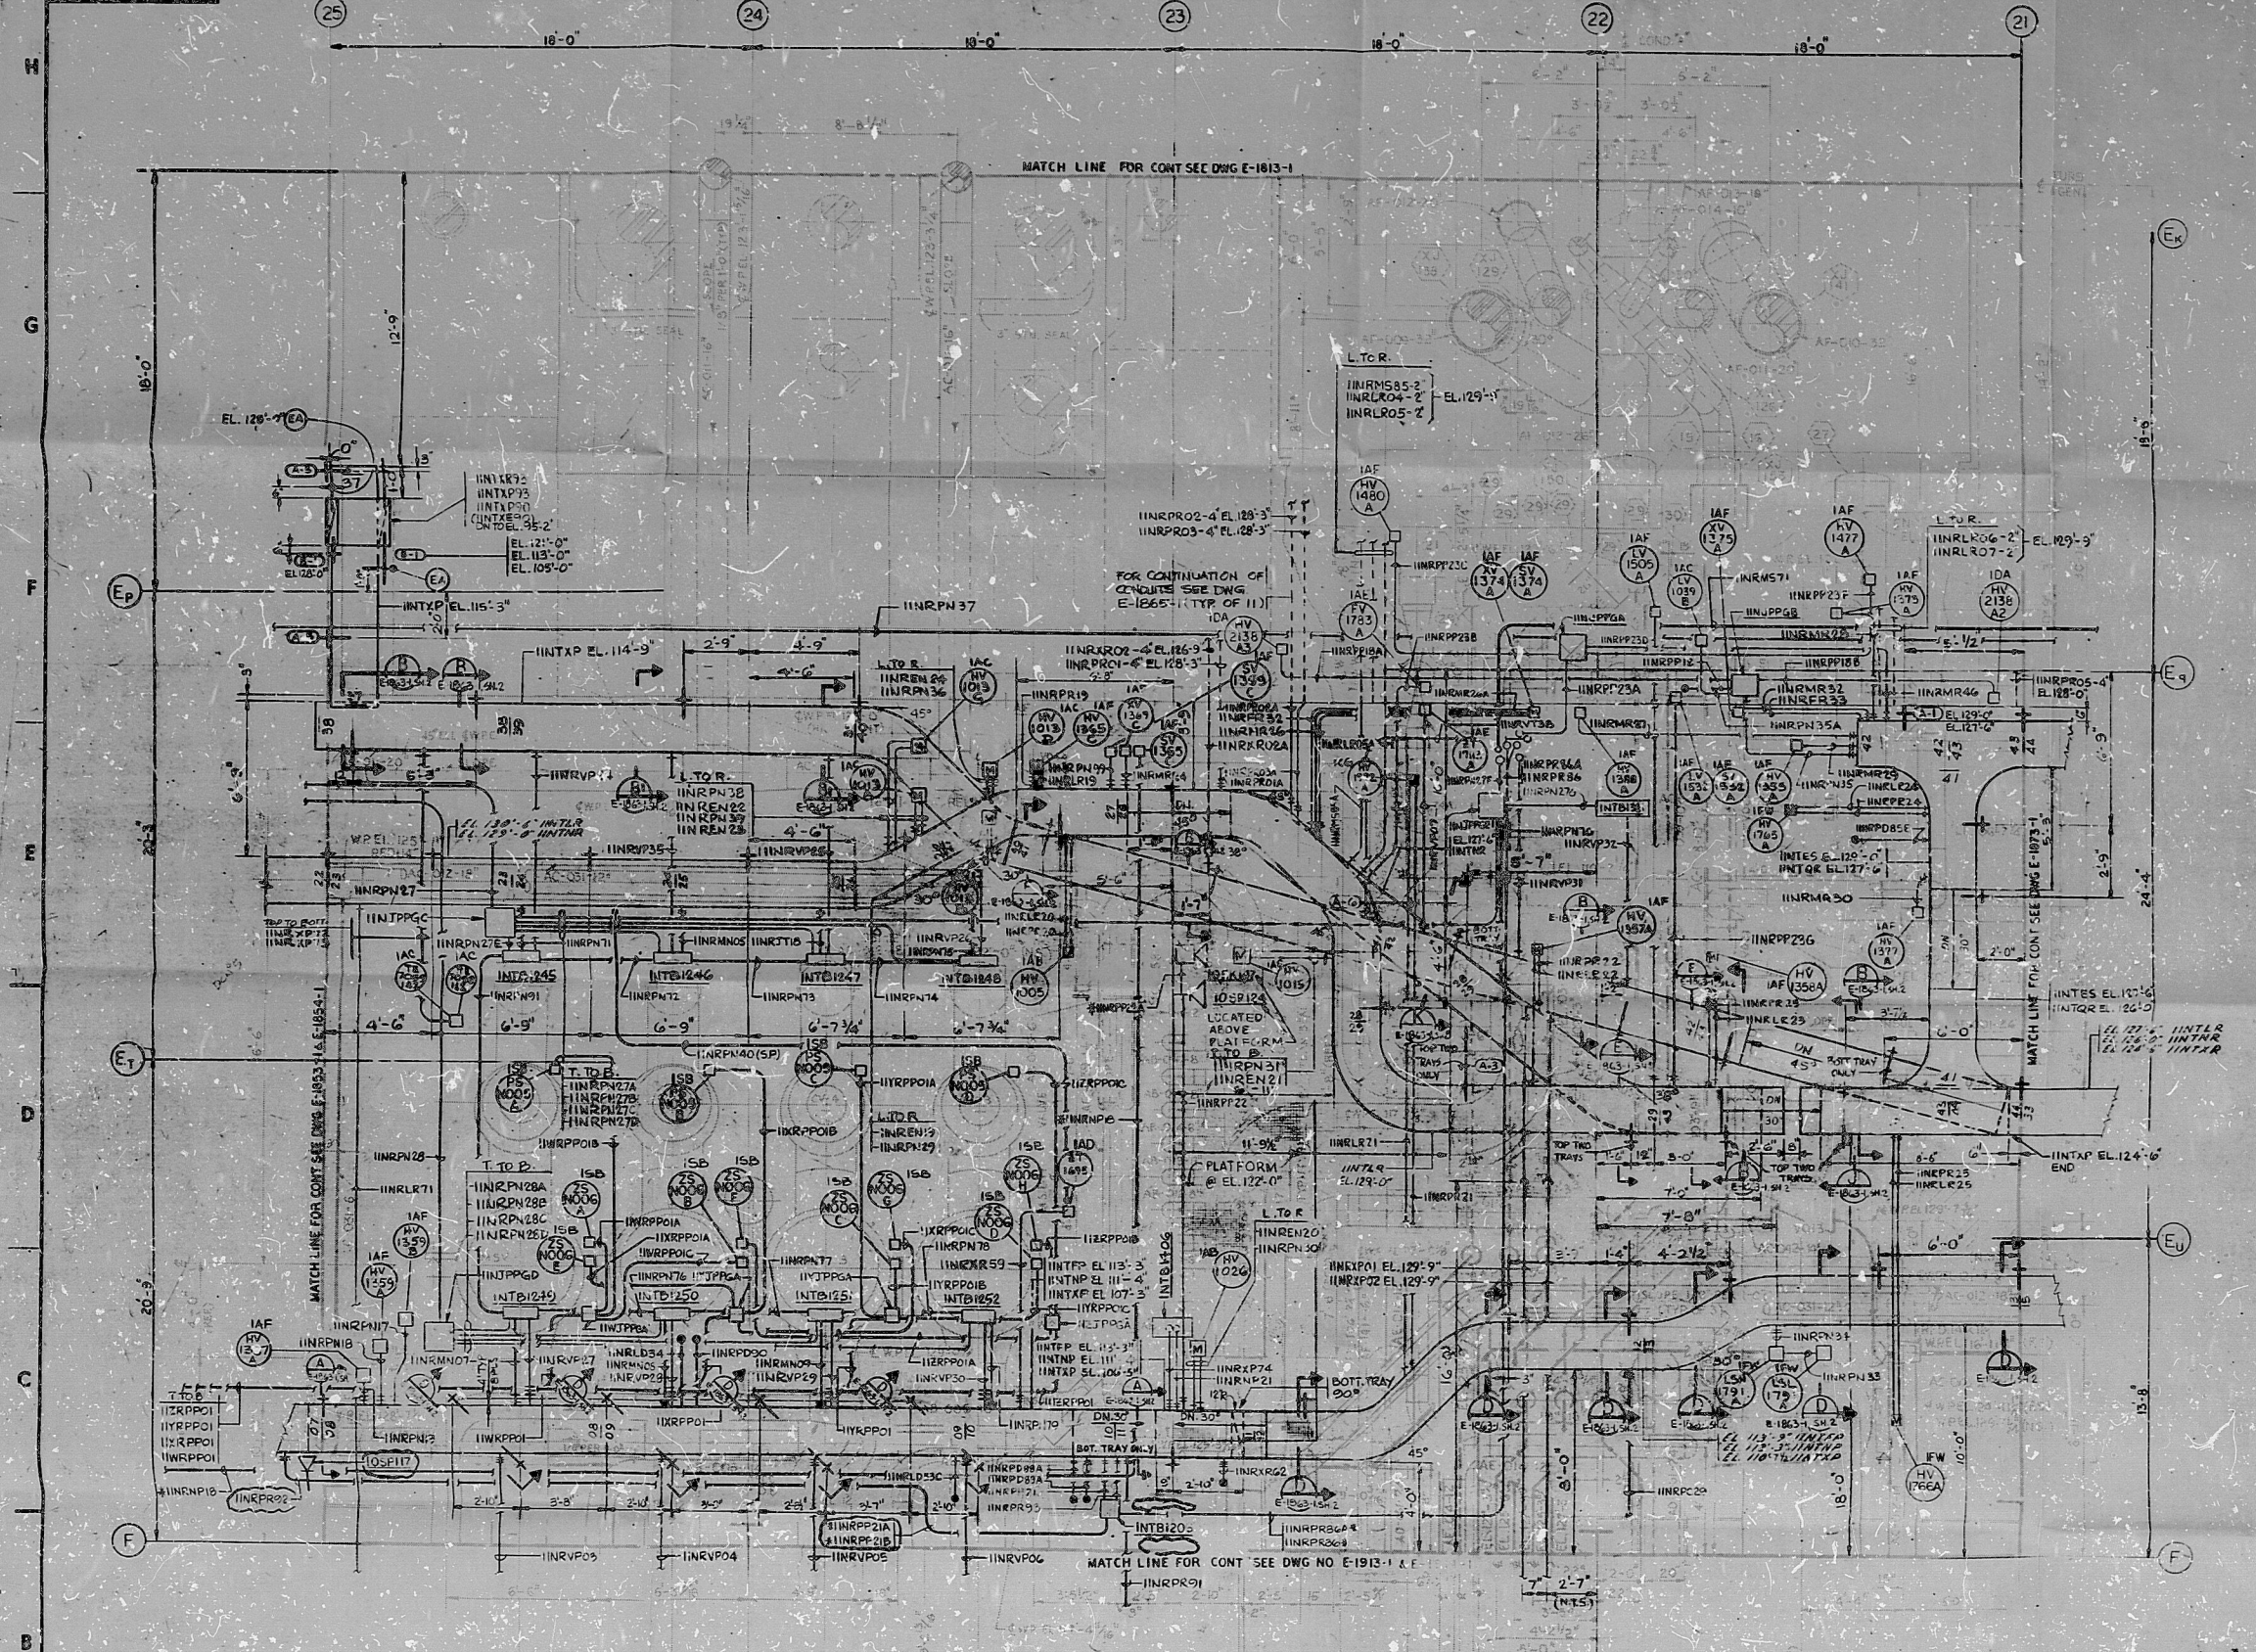

REVISIONS	
NO.	DATE
01	03 01 01 01 01 01
02	03 01 01 01 01 01
03	03 01 01 01 01 01
100	03 01 01 01 01 01

- NOTES**
1. ALL CABLE TRAYS ARE 24" UNLESS OTHERWISE NOTED.
 2. FOR CABLE TRAY SUPPORT DIMS, SEE DWG E-1406-0.
 3. ALL CABLE TRAY SUPPORTS ARE TYPE (SD) UNLESS OTHERWISE NOTED.
 4. FIELD CUT GRATING TO BEET CABLE TRAY SUPPORT, SEE DWG C-0017 FOR TYPICAL GRATING DETAIL.
 5. CLASS 'E' RACEWAY TRAY & CONDUIT, ETC. ARE IDENTIFIED FOR 'O' LISTED INSTALLATION BY LETTERS A, B, C, D, E, F, G, H, I, J, K, L, M, N, O, P, Q, R, S, T, U, V, W, X, Y, Z, OR 2, IN THE THIRD CHARACTER OF A RACEWAY NUMBER.

- REFERENCE DRAWINGS**
1. E-1863-1 TURBINE BUILDING GENERAL OVERALL PLAN & DIMS OF PLATFORM FROM EL. 102'-0" AREA 1 & 2.
 2. E-1863-1 TURBINE BUILDING AREA 7 TURBINE BUILDING PLAN AT EL. 102'-0" AREA 7.
 3. E-1863-1 TURBINE BUILDING AREA 7 TURBINE BUILDING AREA 7 PLAN AT EL. 102'-0" & EL. 120'-0".
 4. C-2054-1 TURBINE BUILDING STRUCTURAL STEEL C-2054-0, FL FRAMING PLAN EL. 102'-0" AREA 1 & 2.
 5. C-2054-1 TURBINE BLDG MISCELLANEOUS STEEL PLATFORM PLAN EL. 102'-0" SH. 1.
 6. J-10705-1 INSTRUMENT LOCATION DWG. TURB. BLDG. J-10704-1 AREA 07 PLAN AT EL. 102'-0" & 120'-0".

NO.	DATE	REVISION	BY	CHKD.
1	03 01 01	01		
2	03 01 01	02		
3	03 01 01	03		
100	03 01 01	100		

BECHTEL
SAN FRANCISCO

PUBLIC SERVICE ELECTRIC AND GAS COMPANY
HOPE CREEK GENERATING STATION

RACEWAY PLAN
TURBINE BLDG. AREA 07
PLAN AT EL. 102'-0" & 120'-0"

DATE: 03 01 01
DRAWN BY: [Signature]
CHECKED BY: [Signature]
SCALE: AS SHOWN

NOT TO BE USED
ELECT RACEWAY
INFORMATION ONLY

PDR RIDS

8512160411

