


11548-FE-1AA

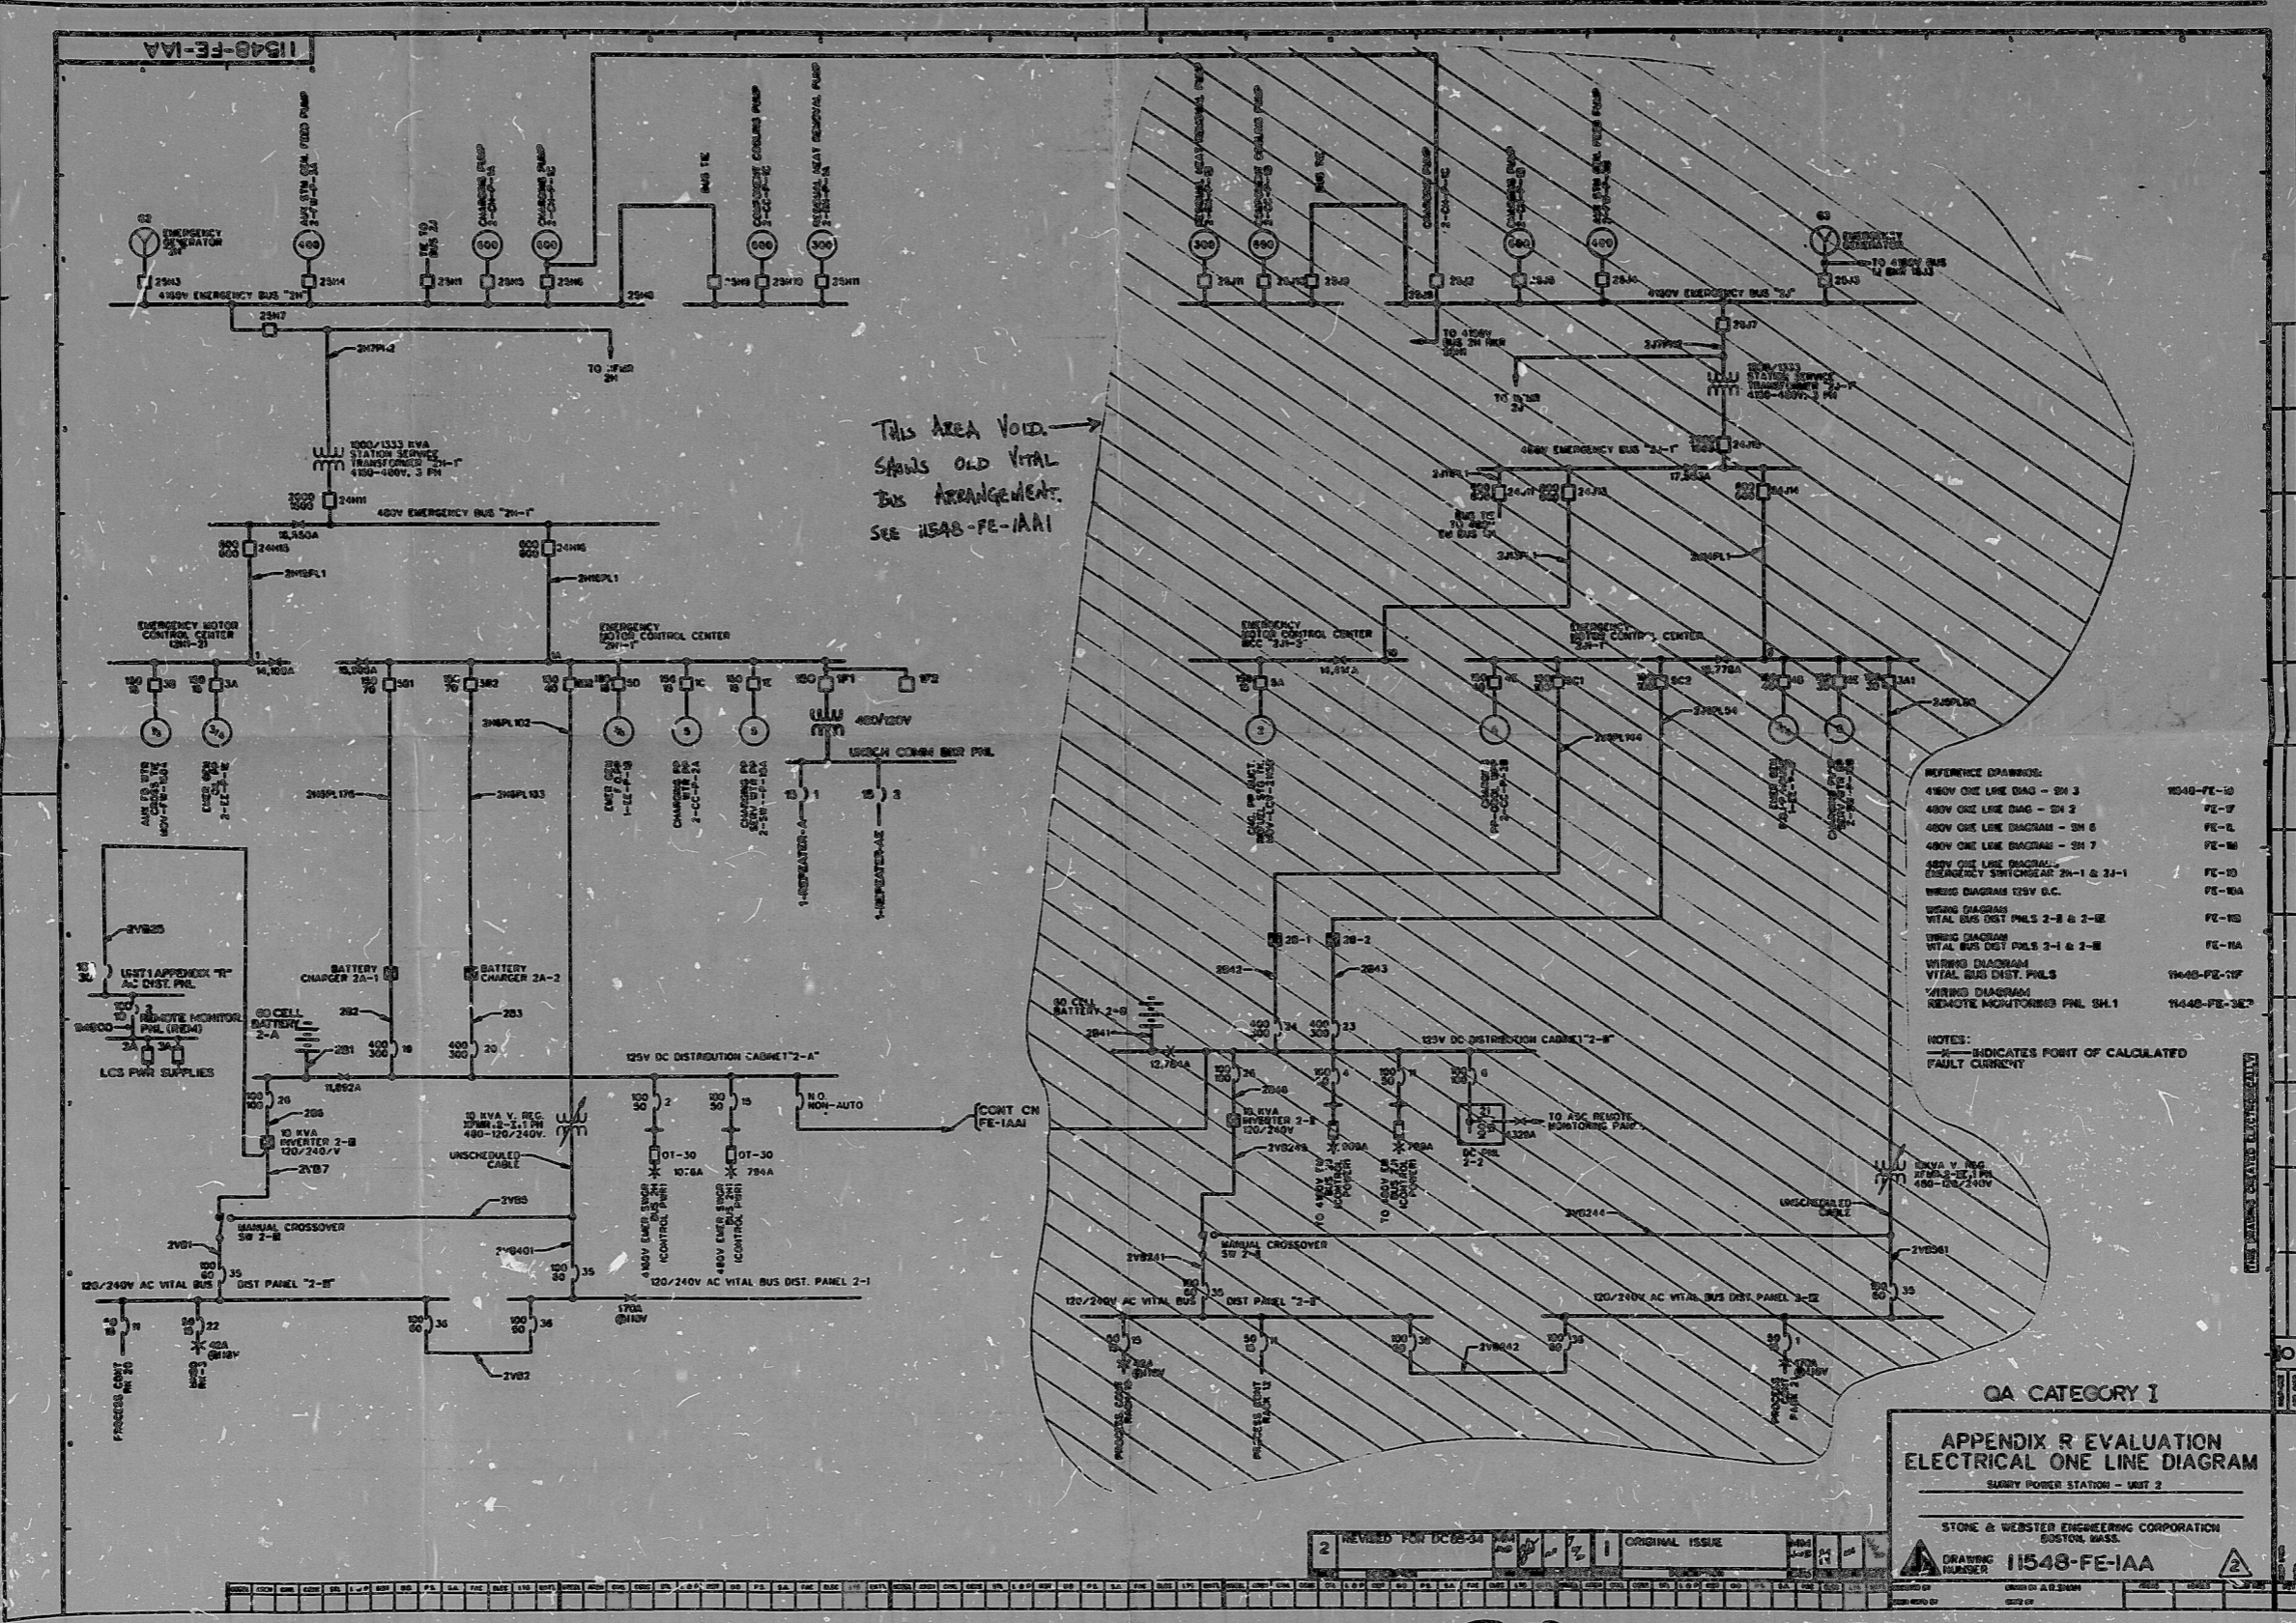

THIS AREA VOID  
SHOWS OLD VITAL  
BUS ARRANGEMENT.  
SEE 11548-FE-1AA1

- REFERENCE DRAWINGS:
- 480V ONE LINE DIAG - SH 3 11548-FE-1D
  - 480V ONE LINE DIAG - SH 2 11548-FE-1E
  - 480V ONE LINE DIAGRAM - SH 6 11548-FE-1F
  - 480V ONE LINE DIAGRAM - SH 7 11548-FE-1G
  - 480V ONE LINE DIAGRAM - EMERGENCY SWITCHGEAR 2A-1 & 2A-2 11548-FE-1H
  - WIRING DIAGRAM 125V D.C. 11548-FE-1I
  - WIRING DIAGRAM VITAL BUS DIST PNL 2-B & 2-1E 11548-FE-1J
  - WIRING DIAGRAM VITAL BUS DIST PNL 3-1 & 3-2 11548-FE-1K
  - WIRING DIAGRAM VITAL BUS DIST PNL 3-1 & 3-2 11548-FE-1L
  - WIRING DIAGRAM REDNOTE MOUNTING PNL SH.1 11548-FE-1M
- NOTES:
- X INDICATES POINT OF CALCULATED FAULT CURRENT

TI  
APERTURE  
CARD  
Also Available On  
Aperture Card

QA CATEGORY I

APPENDIX R EVALUATION  
ELECTRICAL ONE LINE DIAGRAM  
SLURRY POWER STATION - UNIT 2

STONE & WEBSTER ENGINEERING CORPORATION  
BOSTON, MASS.

DRAWING NUMBER 11548-FE-1AA

2	REVISED FOR DC68-34	1	ORIGINAL ISSUE
---	---------------------	---	----------------

8801280612

PDR RIDS

8801280612

