


This drawing and the design it covers are the property of BECHTEL. They are merely loaned and on the borrower's express agreement that they will not be reproduced, copied, loaned, exhibited, or used except in the private use permitted by any written consent given by the lender to the borrower.

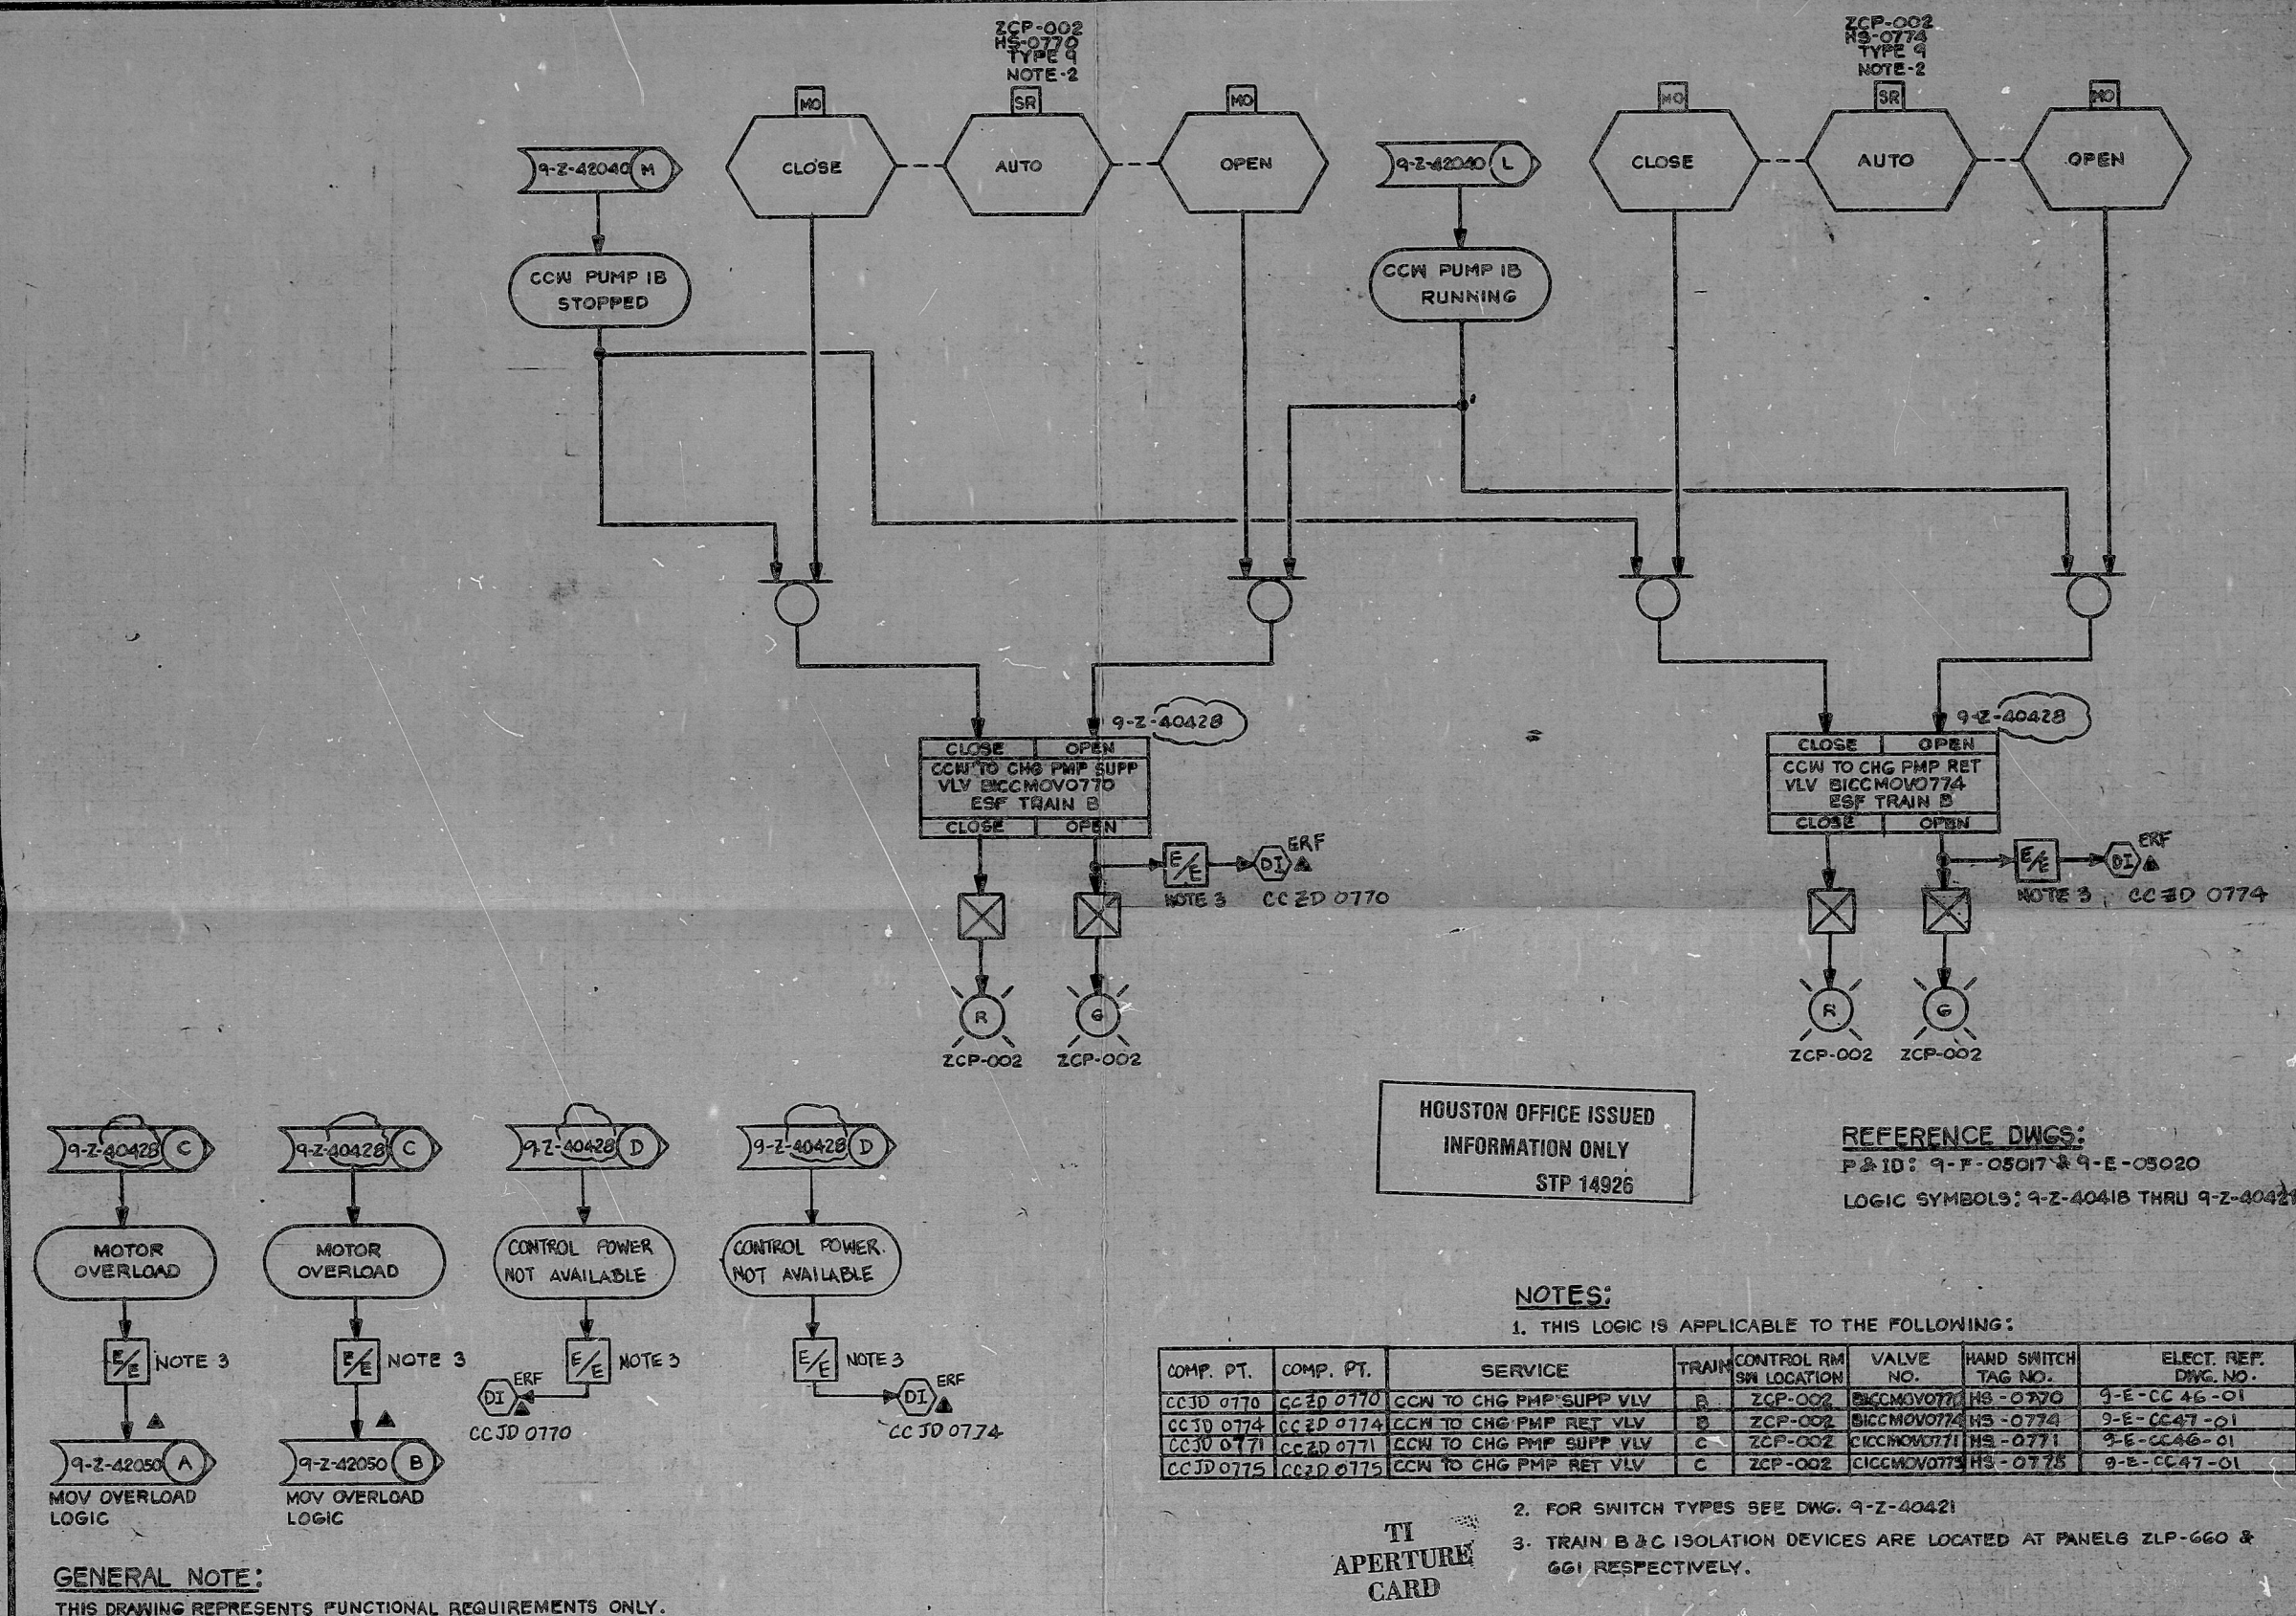

HOUSTON OFFICE ISSUED
INFORMATION ONLY
STP 14926

REFERENCE DWGS:
P&ID: 9-F-05017 & 9-E-05020
LOGIC SYMBOLS: 9-Z-40418 THRU 9-Z-40421

NOTES:
1. THIS LOGIC IS APPLICABLE TO THE FOLLOWING:

COMP. PT.	COMP. PT.	SERVICE	TRAIN	CONTROL RM SW LOCATION	VALVE NO.	HAND SWITCH TAG NO.	ELECT. REF. DWG. NO.
CC3D 0770	CC3D 0770	CCW TO CHG PMP SUPP VLV	B	ZCP-002	9-Z-40428	HS-0770	9-E-CC 46-01
CC3D 0774	CC3D 0774	CCW TO CHG PMP RET VLV	B	ZCP-002	9-Z-40429	HS-0774	9-E-CC 47-01
CC3D 0771	CC3D 0771	CCW TO CHG PMP SUPP VLV	C	ZCP-002	9-Z-40428	HS-0771	9-E-CC 46-01
CC3D 0775	CC3D 0775	CCW TO CHG PMP RET VLV	C	ZCP-002	9-Z-40429	HS-0775	9-E-CC 47-01

2. FOR SWITCH TYPES SEE DWG. 9-Z-40421
3. TRAIN B & C ISOLATION DEVICES ARE LOCATED AT PANELS ZLP-660 & 661 RESPECTIVELY.

TI
APERTURE
CARD

NUCLEAR SAFETY RELATED										Q
BECHTEL POWER CORPORATION HOUSTON, TEXAS										
HOUSTON LIGHTING & POWER CO. SOUTH TEXAS PROJECT										
SCALE: 1/4" = 1'-0"										
DATE: 11-11-80										
DRAWING NO.: 5R-20-9Z-42065										
REV. 1										

8741160343

Mather 8701150168

PDR RIDS

8701160343

