

REACTOR VESSEL LEVEL


NEW YORK POWER AUTHORITY
FITZPATRICK STATION UNIT I

NEW YORK DWG NO 5256 1733 808-039-4

IEC LOOP DIAGRAM
REACTOR VESSEL LEVEL

DATE	CHKD	DRAWING NO.	SH. NO.	REV		
11/23/83	JEV	11825-LP-023-2B		3A		
BY	ENGR	GILBERT ASSOCIATES, INC. ENGINEERS AND CONSULTANTS READING, PA				
DATE	CHKD	REV	MADE	CH	APP	DATE
11/23/83	JEV	3	RUL	JEV	JEV	11/23/83
REVISION	BY	DATE	DESCRIPTION	DATE	BY	DATE
3A	JEV	11/23/83	REVISED INTERLOCK			
AS NOTED						

ISSUED WITH PACKAGE FI-85-053
FOR REFERENCE ONLY

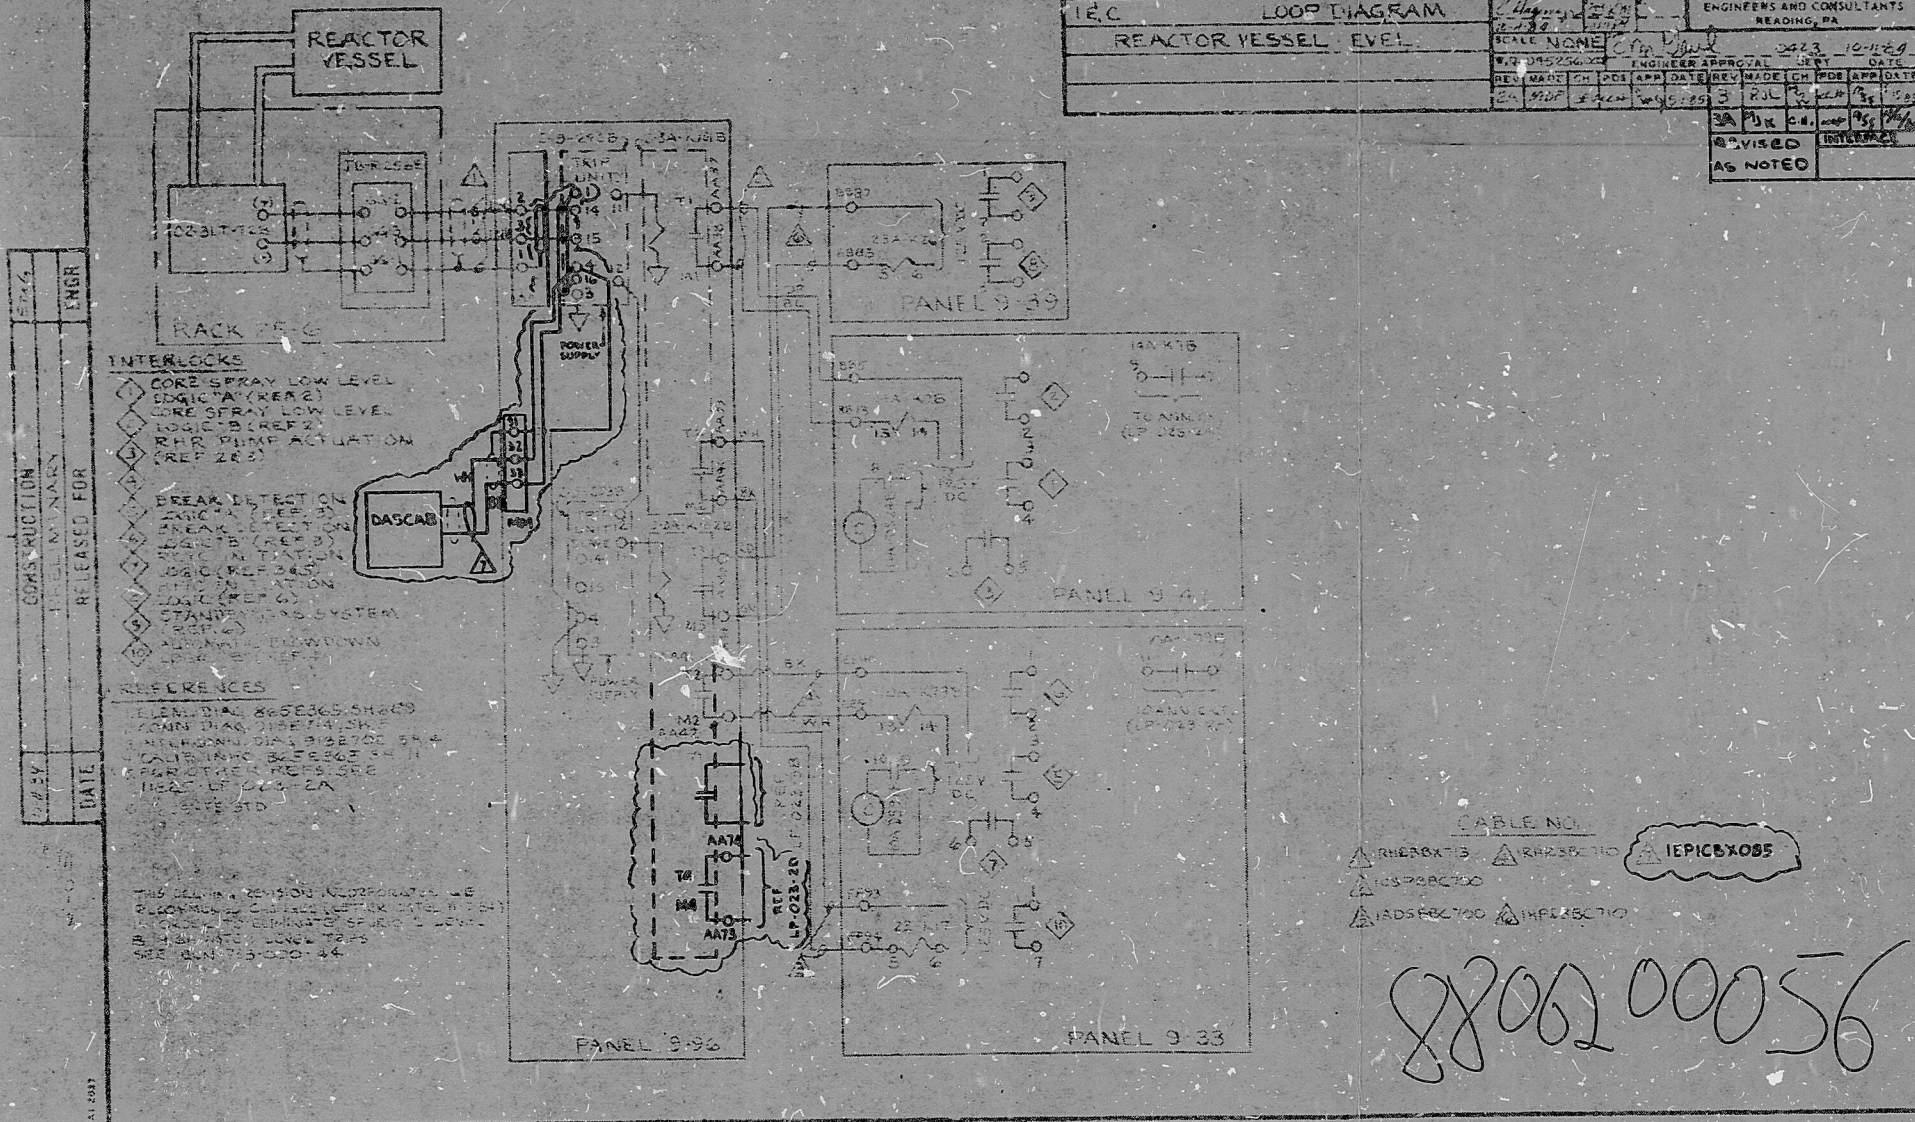

THE DRAWING NUMBER OF THIS REPRODUCIBLE
IS 11825-LP-023-2B REV. 3A

THIS DRAWING IS A REPRODUCIBLE REVISED
FOR MODIFICATION ATTS
MODIFICATION NO. #1-86-053 ORIGINAL
WILL BE REVISED UPON COMPLETION AND
VERIFICATION OF MODIFICATION.

TI APERTURE CARD			
3	AS-BUILT PER MOD N° FI-82-053	JEV	JEV
REV.	DESCRIPTION	DRWN BY	ENG VERIF APPR. DATE
REVISION BY NYPA			
JAMES A FITZPATRICK NUCLEAR POWER PLANT POWER AUTHORITY OF THE STATE OF NEW YORK			
TITLE: REACTOR VESSEL LEVEL			
COMPONENT I.D. N°			
VENDOR: GILBERT ASSOCIATES, INC.			
VENDOR DWG. N° 5256 1733 808-039-3			
FILE N°	11825-LP-023-2B	REV.	3A

PDR RIDS

8806200056

