

DRAWING NUMBER

1.60-23

1.60-23

1.60-23


1.60-23

1.60-23

1.60-23

1.60-23

ANALOG TRIP SYSTEM

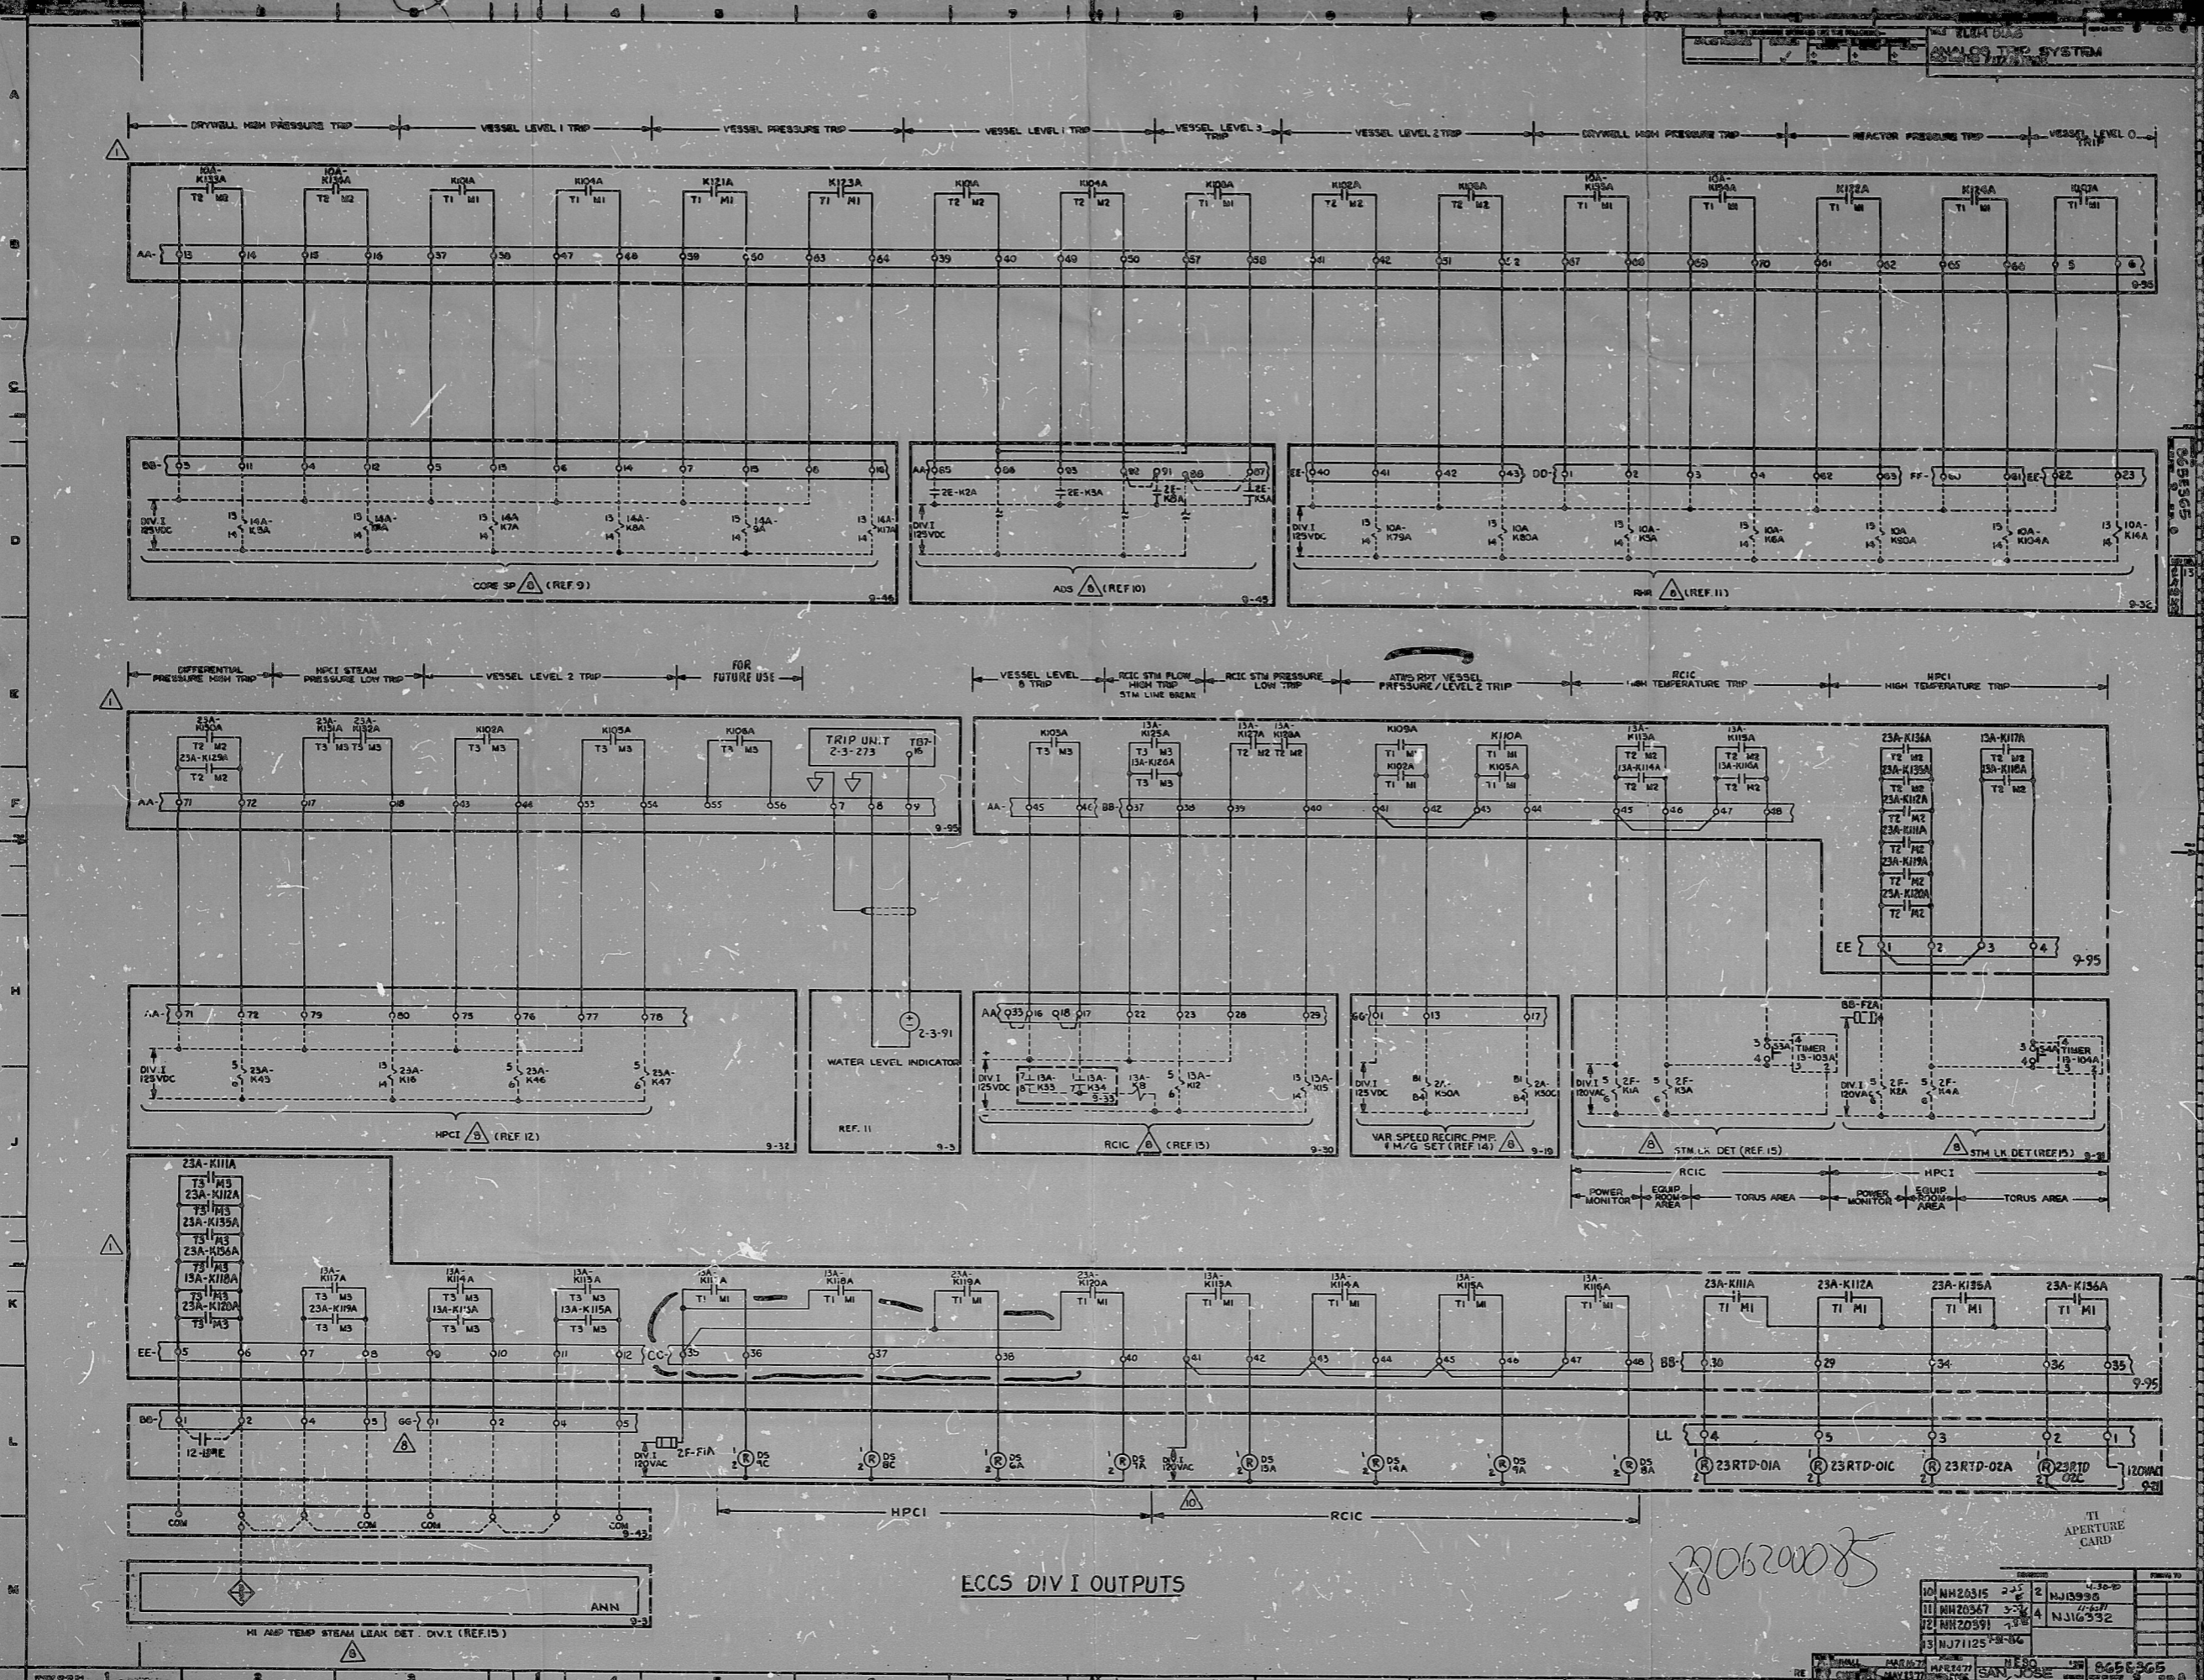

REV	DESCRIPTION	DATE	BY	CHKD BY	APP'D BY
1	REVISION BY NYPA				
2	JAMES A FITZPATRICK NUCLEAR POWER PLANT POWER AUTHORITY OF THE STATE OF NEW YORK				
3	TITLE: ELFA DIAG ANALOG TRIP SYS ATTS				
4	CONTRACT NO. NYPA 09-91 THRU -96				
5	VENDOR C.O.F.				
6	VENDOR ORG. NO. 865E365 3H 0				
7	FILE NO.				
8	1.60-23				
9					

8806200085

8806200085

NO.	DESCRIPTION	DATE	BY	CHKD BY	APP'D BY
10	NH20315	2-25	2	NJ18996	
11	NH20367	3-24	4	NJ16252	
12	NH20591	7-8			
13	NJ71125	8-8			

TITLE: ELFA DIAG ANALOG TRIP SYS ATTS
 PROJECT: JAMES A FITZPATRICK NUCLEAR POWER PLANT
 DRAWING NO.: 1.60-23
 SHEET NO.: 13
 DATE: 11/13/73
 DESIGNED BY: SAN JOSE
 CHECKED BY: [Signature]
 APPROVED BY: [Signature]

PDR RIDS

8806200085

