


06-02-N

NOTE 15 ON  
M-60-1

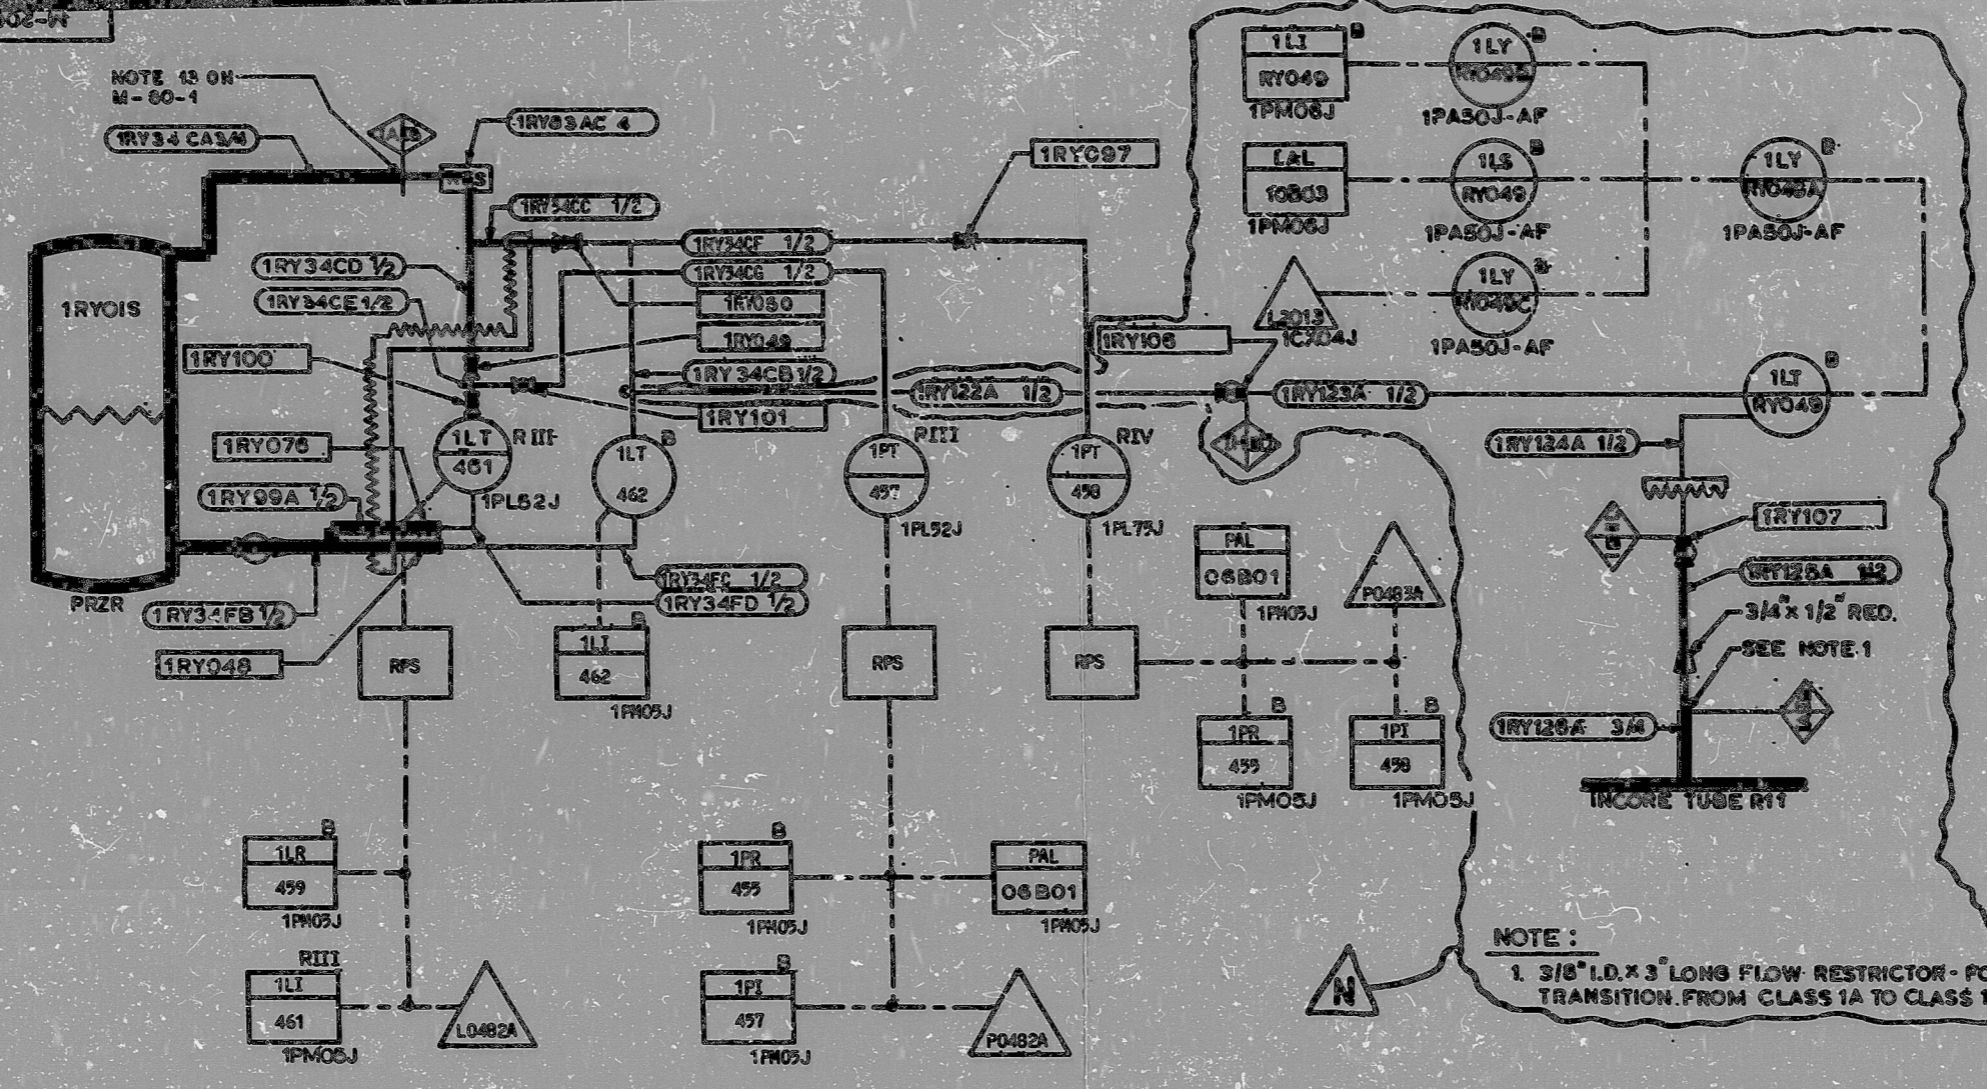


NOTE:  
1 3/8" I.D. x 3' LONG FLOW RESTRICTOR - FOR  
TRANSITION FROM CLASS 1A TO CLASS 1B.

P2R PRESS & LEVEL



**NUCLEAR SAFETY RELATED**  
ITEMS ARE SHOWN ON THIS DRAWING  
(FOR SAFETY CLASSIFICATION SEE PIPING,  
EQUIPMENT, VALVE, OR INSTRUMENT LISTS.)

REV.	DATE	BY	CHKD	DESCRIPTION
M	03-01-67	E. Carter	W. Saltwell	F-2908 FOR RECORD (DRN-P&ID-7301)
M				(DRN-P&ID-7303) (DRN-P&ID-7310)
N	07-20-67	D. Long	W. Saltwell	F-2739 FOR RECORD (DCR 90-179)
N				PECN P-1347, MOD & M6-1-69, 009)

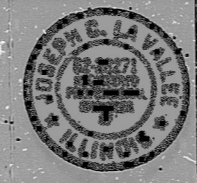

2-23-76  
PROJECT NUMBER  
4951

P&ID/CR1 DIAGRAM  
REACTOR COOLANT SYSTEM - RC  
BYRON STATION  
UNIT 1  
COMMONWEALTH EDISON CO.  
CHICAGO, ILLINOIS

DRAWING NO.	REV.
H-2060	N



PDR RIDS

9603280023

