


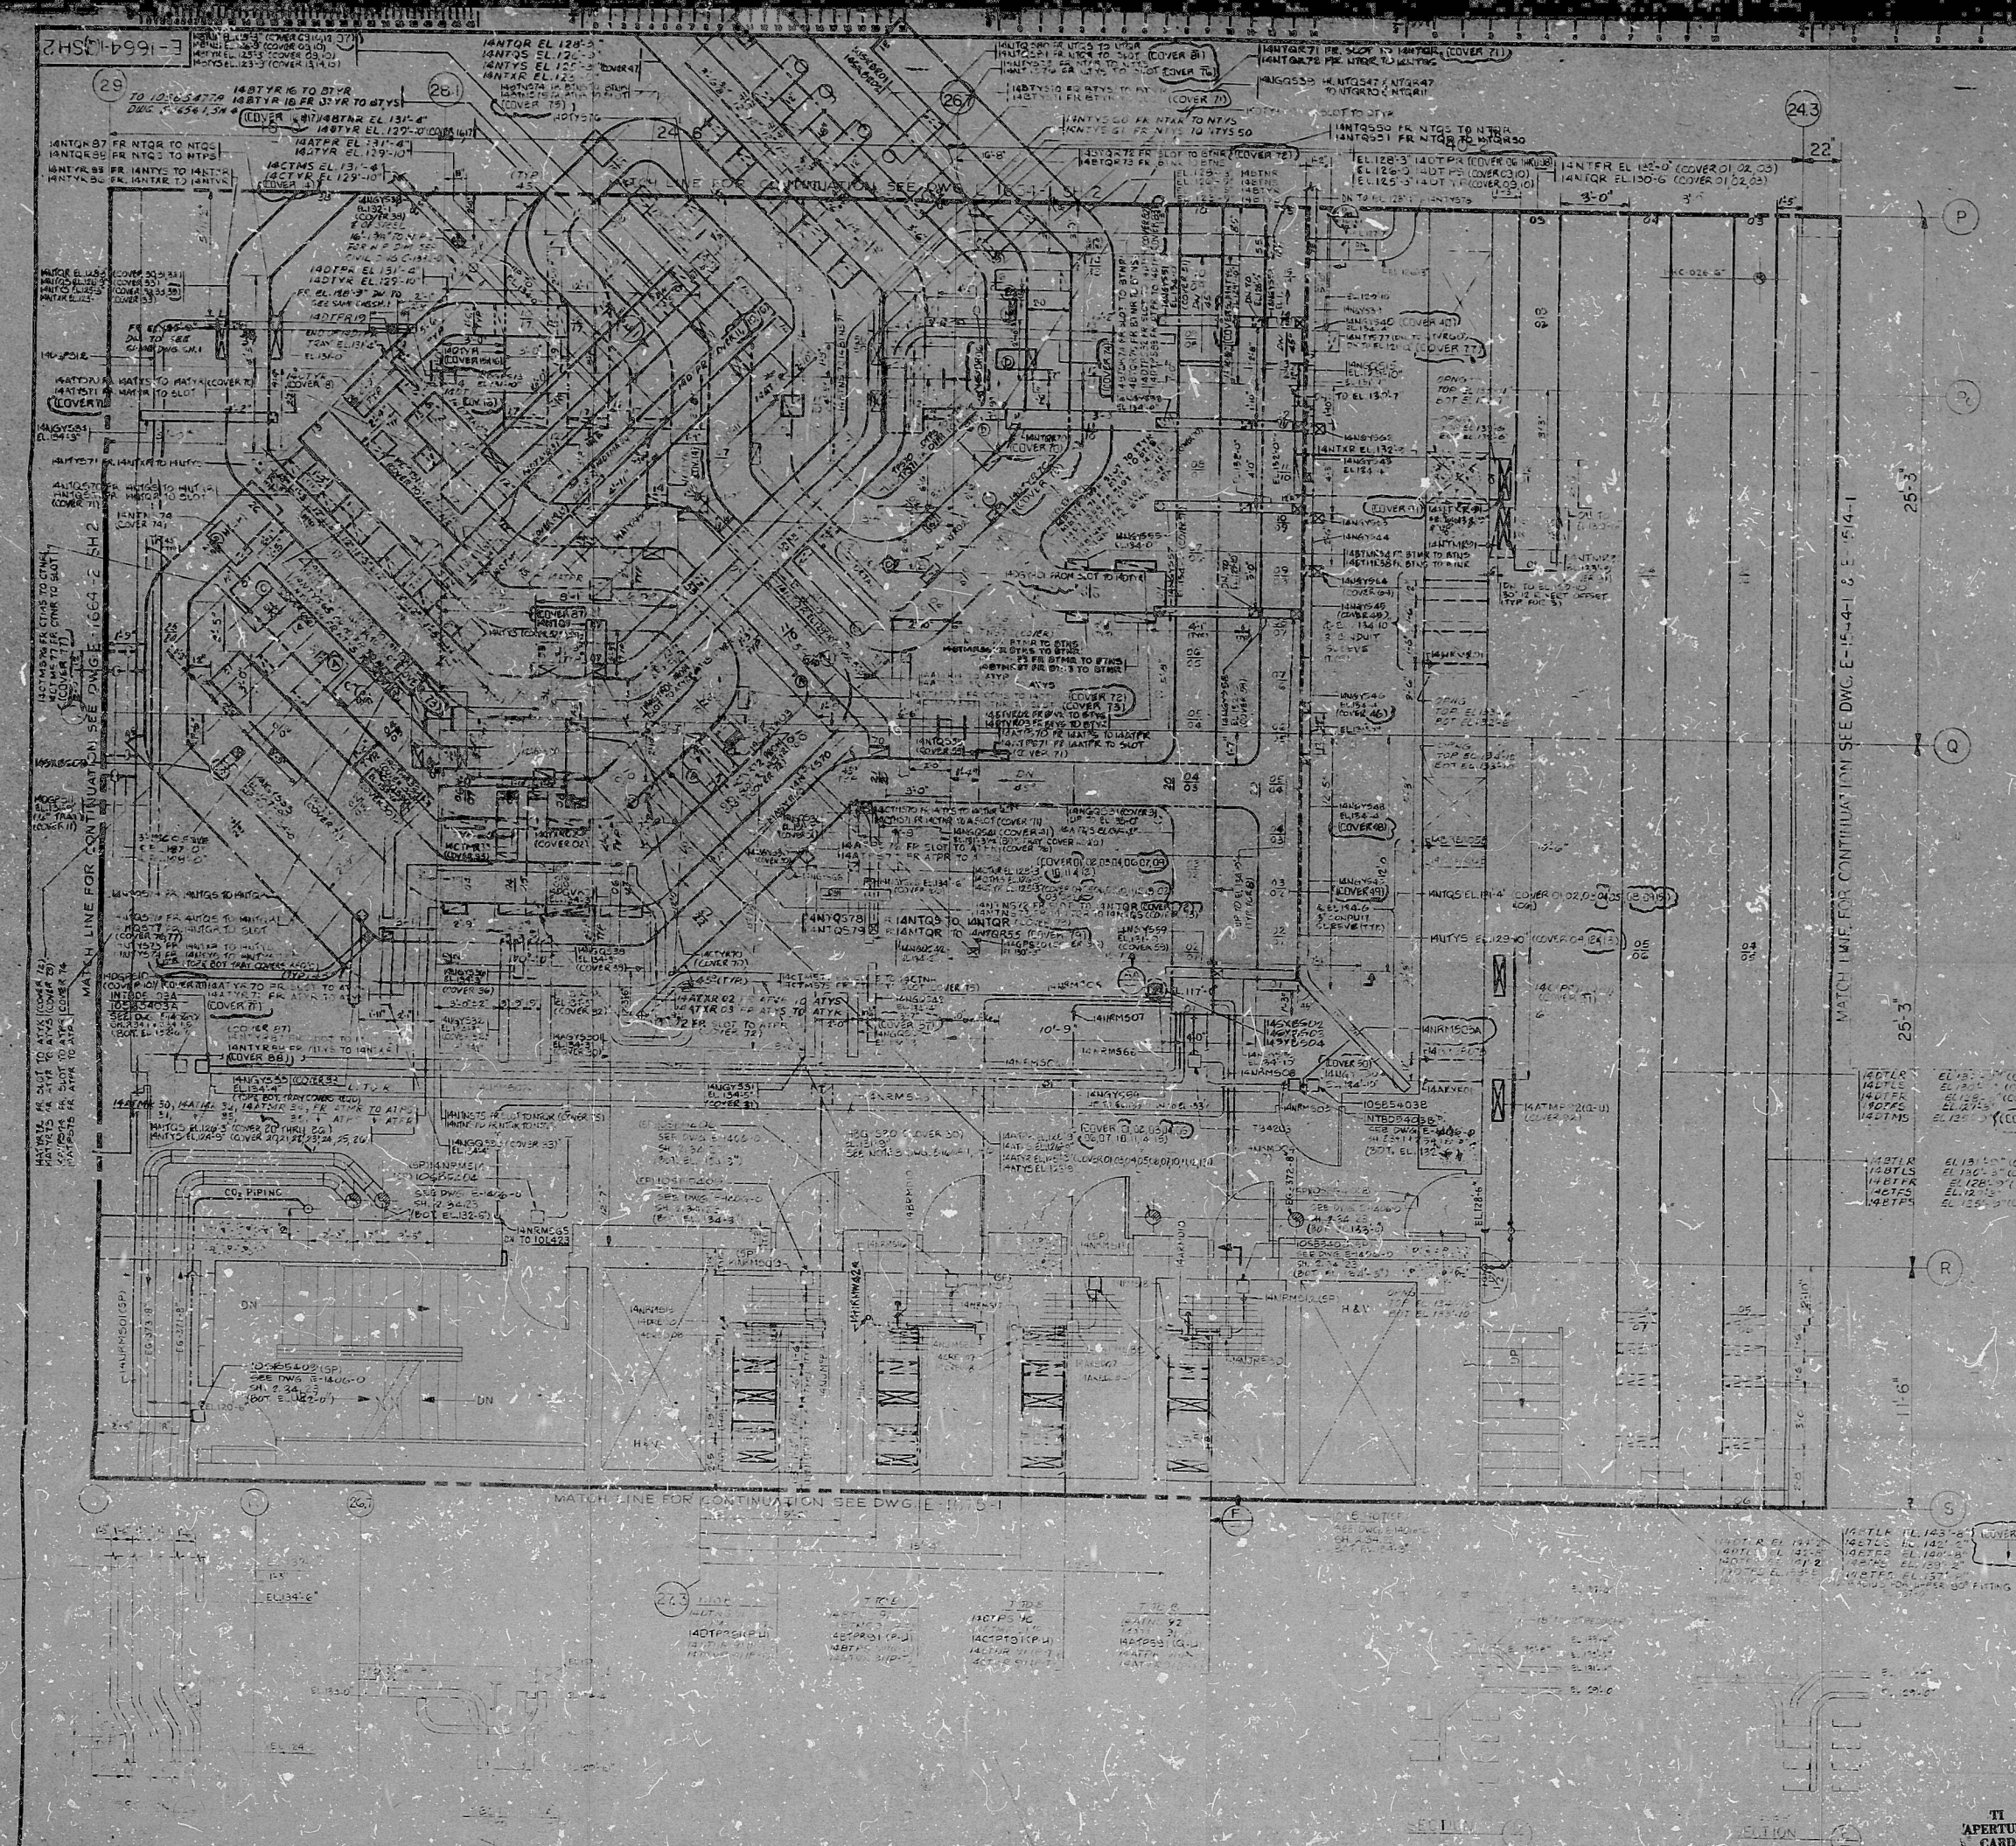

REVISIONS											
NO.	1	2	3	4	5	6	7	8	9	10	11
DATE											
BY											
CHKD											
APP'D											

- NOTES:
1. CLASS 'A' RACEWAY TRAYS, ETC., ARE IDENTIFIED FOR 10' CIRCUMFERENCE BY LETTERS A, B, C, D, E, F, G, H, I, J, K, L, M, N, O, P, Q, R, S, T, U, V, W, X, Y, AND Z, IN THE THIRD CHARACTER OF THE RACEWAY NUMBER.
 2. ALL GROUND TRAYS, UNLESS OTHERWISE SHOWN.
 3. FOR ELEC. RACEWAY NOTED SYMBOLS & DETAILS, SEE DWG. E-154-1.
 4. 12" RADIUS FOR ALL VERTICAL ELBOWS AND CROSS FITTINGS.
 5. FOR HANGER DETAIL, SEE DWG. E-154-1, SHEET 1.
 6. FOR HANGER INFORMATION, SEE THIS DWG.

- REFERENCE DRAWINGS
- C-1329-0 AUX ELEC. CONT. AREA PL. PLAN EL. 117'-6" AREA 26
 - C-1350-0 AUX ELEC. CONT. AREA STRUCTURAL STEEL FLOOR FRAMING PLAN EL. 117'-0" AREA 5
 - C-1355-0 AUX ELEC. CONT. AREA STRUCTURAL STEEL FLOOR FRAMING PLAN EL. 124'-0" AREA 5
 - C-1356-0 AUX ELEC. CONT. AREA STRUCTURAL STEEL FLOOR FRAMING PLAN EL. 137'-0" AREA 5
 - C-1357-0 HVAC AREA DRAWING AUX ELEC. CONT. AREA PL. PLAN AT EL. 117'-6" AREA 26
 - C-1358-0 HVAC AREA DRAWING AUX ELEC. CONT. AREA PL. PLAN AT EL. 124'-0" AREA 5
 - C-1359-0 HVAC AREA DRAWING AUX ELEC. CONT. AREA PL. PLAN AT EL. 137'-0" AREA 5

NO.	DATE	REVISION	BY	CHKD	APP'D
1					
2					
3					
100					

DECHTEL
SAN FRANCISCO
PUBLIC SERVICE ELECTRIC AND GAS COMPANY
HOPE CREEK GENERATING STATION

RACEWAY PLAN
AUX BLDG. CONTROL AREA 26
PLAN AT EL. 124'-0"

DATE: 10/26/55
DRAWN BY: E-154-1 (19)
CHECKED BY: SH 2 OF 16

TI
APERTURE
CARD

PDR RIDS

8602270433

