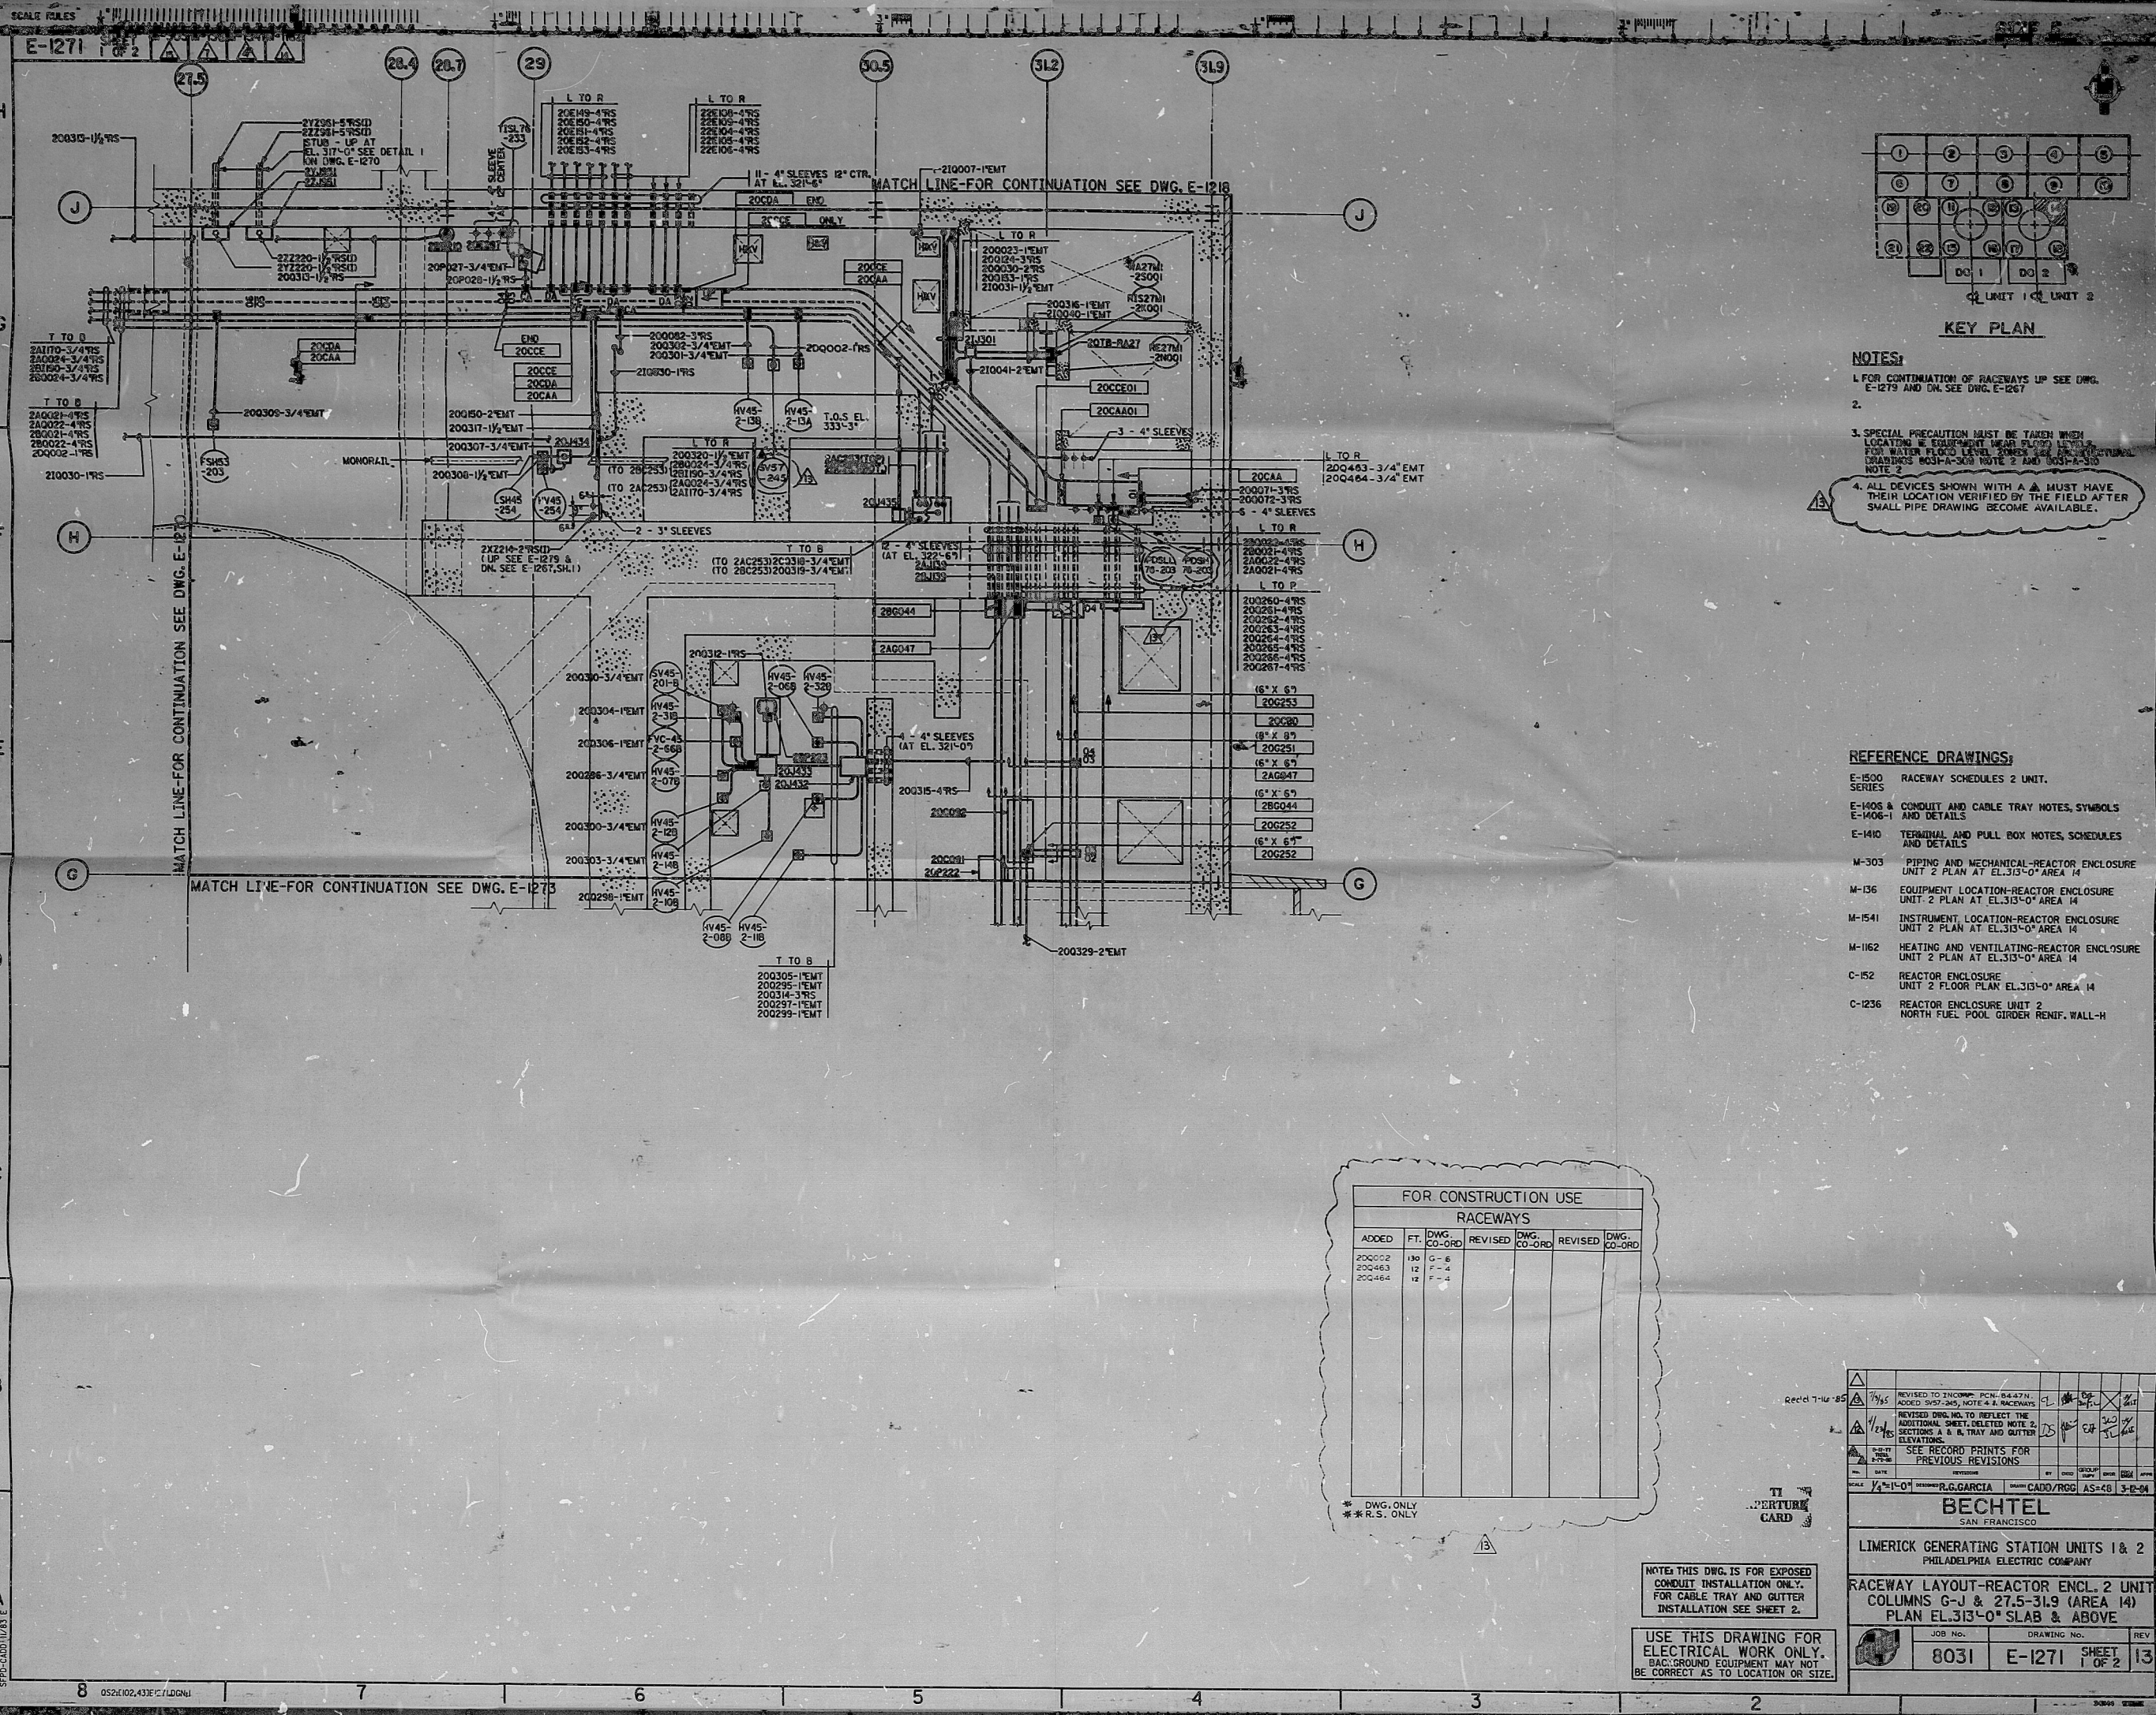


- NOTES:**
- 1. FOR CONTINUATION OF RACEWAYS UP SEE DWG. E-1273 AND DN SEE DWG. E-1267.
 - 2.
 - 3. SPECIAL PRECAUTION MUST BE TAKEN WHEN LOCATING E. EQUIPMENT NEAR FLOOR LEVELS FOR WATER FLOOD LEVELS. SEE ELECTRICAL DRAWINGS 8031-A-308 NOTE 2 AND 8031-A-310 NOTE 2.
 - 4. ALL DEVICES SHOWN WITH A Δ MUST HAVE THEIR LOCATION VERIFIED BY THE FIELD AFTER SMALL PIPE DRAWING BECOME AVAILABLE.

- REFERENCE DRAWINGS:**
- E-1500 RACEWAY SCHEDULES 2 UNIT.
 - E-1406 & CONDUIT AND CABLE TRAY NOTES, SYMBOLS AND DETAILS.
 - E-1410 TERMINAL AND PULL BOX NOTES, SCHEDULES AND DETAILS.
 - M-303 PIPING AND MECHANICAL-REACTOR ENCLOSURE UNIT 2 PLAN AT EL. 313'-0" AREA 14.
 - M-136 EQUIPMENT LOCATION-REACTOR ENCLOSURE UNIT 2 PLAN AT EL. 313'-0" AREA 14.
 - M-1541 INSTRUMENT LOCATION-REACTOR ENCLOSURE UNIT 2 PLAN AT EL. 313'-0" AREA 14.
 - M-1162 HEATING AND VENTILATING-REACTOR ENCLOSURE UNIT 2 PLAN AT EL. 313'-0" AREA 14.
 - C-152 REACTOR ENCLOSURE UNIT 2 FLOOR PLAN EL. 313'-0" AREA 14.
 - C-1236 REACTOR ENCLOSURE UNIT 2 NORTH FUEL POOL GIRDER RENOV. WALL-H.

FOR CONSTRUCTION USE					
RACEWAYS					
ADDED	FT.	DWG.	REVISED	DWG.	REVISED
200022	180	G-6			
200463	12	F-4			
200464	12	F-4			

REVISION	DATE	BY	CHKD	GROUP	REASON
1	1/4-1-01	R. GARCIA		CAD/ROG	AS-48 3-E-04

BECHTEL
SAN FRANCISCO

NOTE: THIS DWG. IS FOR EXPOSED CONDUIT INSTALLATION ONLY. FOR CABLE TRAY AND GUTTER INSTALLATION SEE SHEET 2.

USE THIS DRAWING FOR ELECTRICAL WORK ONLY. BAC: GROUND EQUIPMENT MAY NOT BE CORRECT AS TO LOCATION OR SIZE.

LIMERICK GENERATING STATION UNITS 1 & 2 PHILADELPHIA ELECTRIC COMPANY			
RACEWAY LAYOUT-REACTOR ENCL. 2 UNIT COLUMNS G-J & 27.5-31.9 (AREA 14) PLAN EL. 313'-0" SLAB & ABOVE			
JOB NO.	DRAWING NO.	REV	
8031	E-1271	SHEET 1 OF 2	13

This drawing and the design it covers are the property of BECHTEL. They are hereby loaned and are to be returned to BECHTEL. They are not to be reproduced, copied, loaned, sold, or otherwise used without the written consent of BECHTEL. They are not to be used in any way that would reflect unfavorably on BECHTEL or its services.

PDR RIDS

8702200454

