


ANSTEC APERTURE CARD

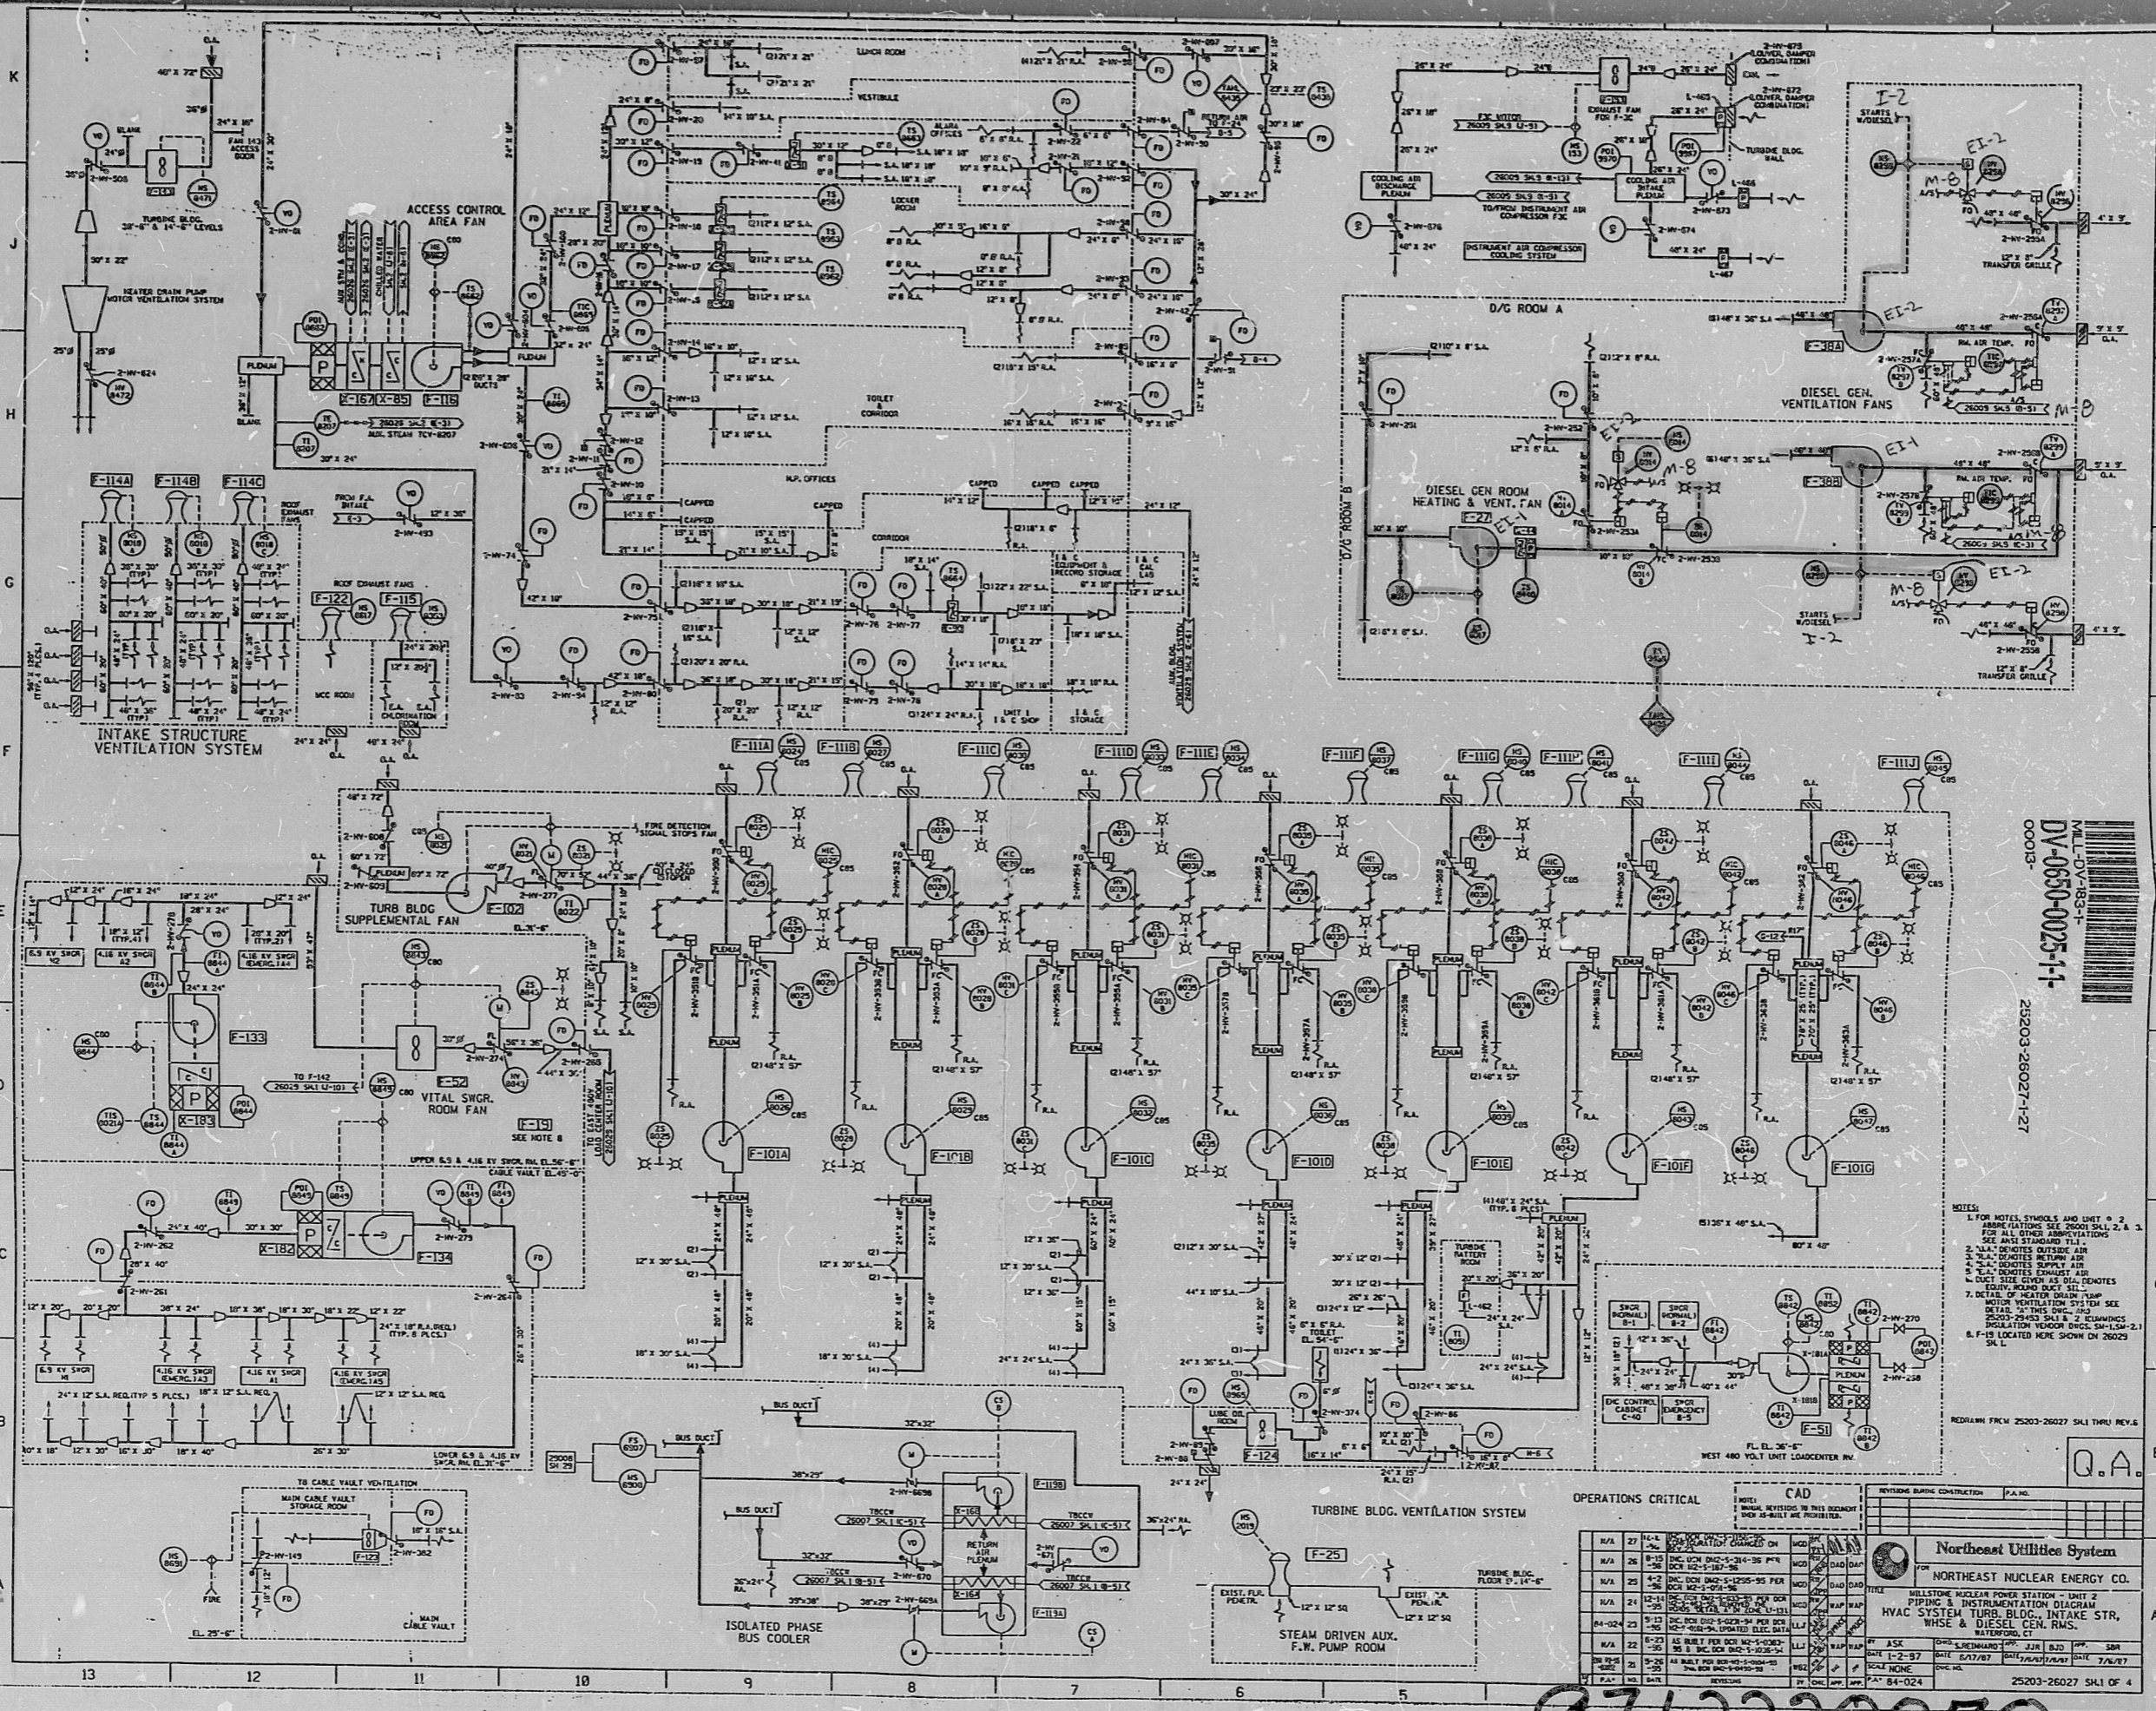

MILL-DV-183-1  
 DV-0650-0025-1-1  
 00013-  
 212203-28027-1-27

- NOTES:
- FOR NOTES, SYMBOLS AND UNIT # 2 APPROPRIATIONS SEE 25001 SKI 2, 2 & 3 FOR ALL OTHER APPROPRIATIONS. SEE ANSI STANDARD T1.1.
  - ALL DIMENSIONS OUTSIDE AIR.
  - ALL DIMENSIONS RETURN AIR.
  - ALL DIMENSIONS SUPPLY AIR.
  - DUCT SIZE GIVEN AS DIA. NOTES.
  - DETAIL OF HEATER DRAIN PUMP MOTOR W/HEATER DRAIN SYSTEM SEE DETAIL. THIS DUC. #2.
  - ROOMS 25001 SKI 2 & 3 DIMENSIONS ISOLATION VENDOR DWGS. SM-15W-2.1 & F-18 LOCATED HERE SHOWN ON 25023 SKI 1.

Q.A.

OPERATIONS CRITICAL

NO.	DATE	BY	DESCRIPTION
1	11-14-68	W.D.	ISSUED FOR CONSTRUCTION
2	11-14-68	W.D.	ISSUED FOR CONSTRUCTION
3	11-14-68	W.D.	ISSUED FOR CONSTRUCTION
4	11-14-68	W.D.	ISSUED FOR CONSTRUCTION
5	11-14-68	W.D.	ISSUED FOR CONSTRUCTION
6	11-14-68	W.D.	ISSUED FOR CONSTRUCTION
7	11-14-68	W.D.	ISSUED FOR CONSTRUCTION
8	11-14-68	W.D.	ISSUED FOR CONSTRUCTION
9	11-14-68	W.D.	ISSUED FOR CONSTRUCTION
10	11-14-68	W.D.	ISSUED FOR CONSTRUCTION
11	11-14-68	W.D.	ISSUED FOR CONSTRUCTION
12	11-14-68	W.D.	ISSUED FOR CONSTRUCTION
13	11-14-68	W.D.	ISSUED FOR CONSTRUCTION
14	11-14-68	W.D.	ISSUED FOR CONSTRUCTION
15	11-14-68	W.D.	ISSUED FOR CONSTRUCTION
16	11-14-68	W.D.	ISSUED FOR CONSTRUCTION
17	11-14-68	W.D.	ISSUED FOR CONSTRUCTION
18	11-14-68	W.D.	ISSUED FOR CONSTRUCTION
19	11-14-68	W.D.	ISSUED FOR CONSTRUCTION
20	11-14-68	W.D.	ISSUED FOR CONSTRUCTION
21	11-14-68	W.D.	ISSUED FOR CONSTRUCTION
22	11-14-68	W.D.	ISSUED FOR CONSTRUCTION
23	11-14-68	W.D.	ISSUED FOR CONSTRUCTION
24	11-14-68	W.D.	ISSUED FOR CONSTRUCTION
25	11-14-68	W.D.	ISSUED FOR CONSTRUCTION
26	11-14-68	W.D.	ISSUED FOR CONSTRUCTION
27	11-14-68	W.D.	ISSUED FOR CONSTRUCTION
28	11-14-68	W.D.	ISSUED FOR CONSTRUCTION
29	11-14-68	W.D.	ISSUED FOR CONSTRUCTION
30	11-14-68	W.D.	ISSUED FOR CONSTRUCTION
31	11-14-68	W.D.	ISSUED FOR CONSTRUCTION
32	11-14-68	W.D.	ISSUED FOR CONSTRUCTION
33	11-14-68	W.D.	ISSUED FOR CONSTRUCTION
34	11-14-68	W.D.	ISSUED FOR CONSTRUCTION
35	11-14-68	W.D.	ISSUED FOR CONSTRUCTION
36	11-14-68	W.D.	ISSUED FOR CONSTRUCTION
37	11-14-68	W.D.	ISSUED FOR CONSTRUCTION
38	11-14-68	W.D.	ISSUED FOR CONSTRUCTION
39	11-14-68	W.D.	ISSUED FOR CONSTRUCTION
40	11-14-68	W.D.	ISSUED FOR CONSTRUCTION
41	11-14-68	W.D.	ISSUED FOR CONSTRUCTION
42	11-14-68	W.D.	ISSUED FOR CONSTRUCTION
43	11-14-68	W.D.	ISSUED FOR CONSTRUCTION
44	11-14-68	W.D.	ISSUED FOR CONSTRUCTION
45	11-14-68	W.D.	ISSUED FOR CONSTRUCTION
46	11-14-68	W.D.	ISSUED FOR CONSTRUCTION
47	11-14-68	W.D.	ISSUED FOR CONSTRUCTION
48	11-14-68	W.D.	ISSUED FOR CONSTRUCTION
49	11-14-68	W.D.	ISSUED FOR CONSTRUCTION
50	11-14-68	W.D.	ISSUED FOR CONSTRUCTION

NORTH EAST UTILITIES SYSTEM  
 NORTH EAST NUCLEAR ENERGY CO.  
 MILLSTONE NUCLEAR POWER STATION - UNIT 2  
 PIPING & INSTRUMENTATION DIAGRAM  
 HVAC SYSTEM TURBINE BLDG., INTAKE STR.,  
 WHSE & DIESEL GEN. RM.  
 WATERFORD, CT.  
 DRAWN BY: W.D. DATE: 11-14-68  
 CHECKED BY: W.D. DATE: 11-14-68  
 SCALE: NONE  
 SHEET NO. 25203-26027-1-27 OF 4

9712220070

9712220070

PDR RIDS

9712220070

