
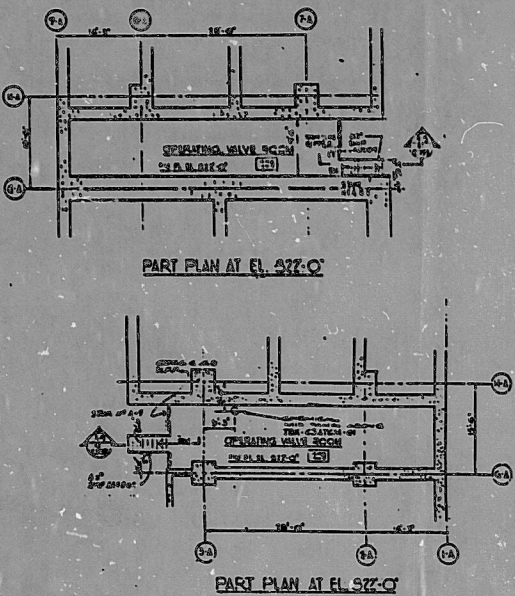


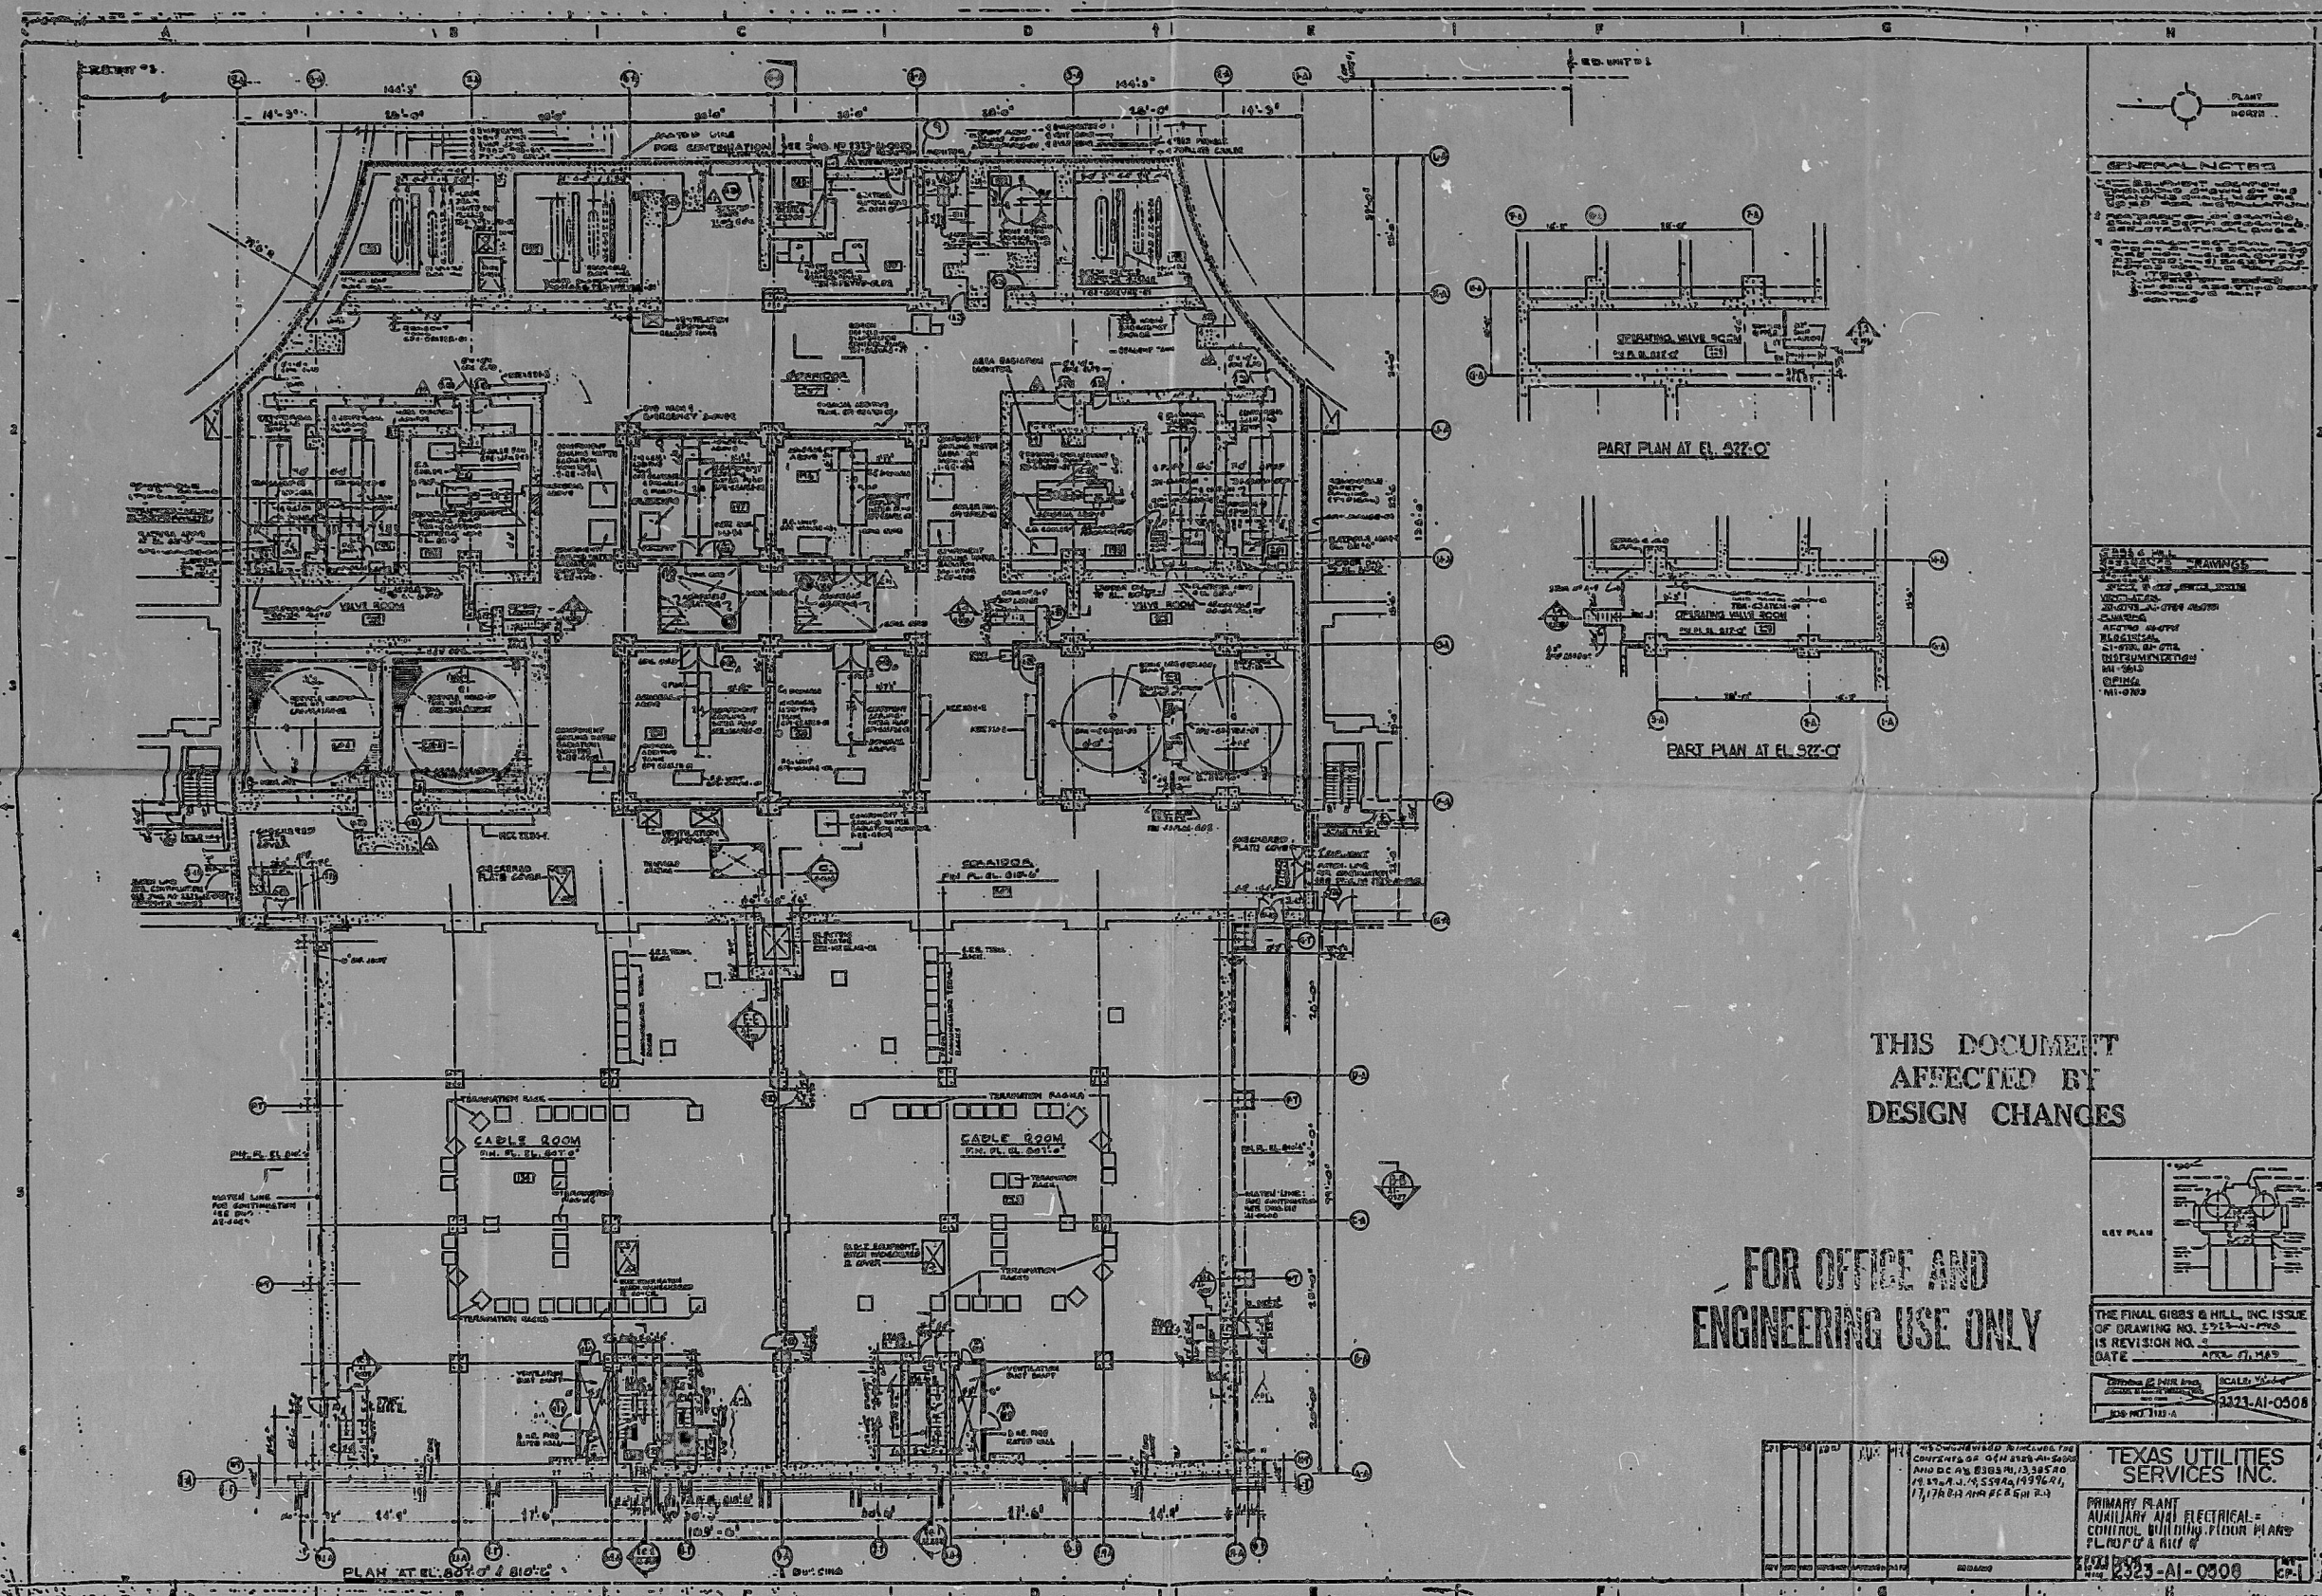

GENERAL NOTES

1. ALL WORK SHALL BE IN ACCORDANCE WITH THE LATEST EDITIONS OF THE NATIONAL ELECTRICAL CODE (NEC) AND THE NATIONAL FIRE PROTECTION ASSOCIATION (NFPA) CODES.
2. ALL MATERIALS SHALL BE OF THE BEST QUALITY AND SHALL BE APPROVED BY THE ENGINEER.
3. ALL WORK SHALL BE DONE IN ACCORDANCE WITH THE LATEST EDITIONS OF THE NATIONAL ELECTRICAL CODE (NEC) AND THE NATIONAL FIRE PROTECTION ASSOCIATION (NFPA) CODES.
4. ALL WORK SHALL BE DONE IN ACCORDANCE WITH THE LATEST EDITIONS OF THE NATIONAL ELECTRICAL CODE (NEC) AND THE NATIONAL FIRE PROTECTION ASSOCIATION (NFPA) CODES.
5. ALL WORK SHALL BE DONE IN ACCORDANCE WITH THE LATEST EDITIONS OF THE NATIONAL ELECTRICAL CODE (NEC) AND THE NATIONAL FIRE PROTECTION ASSOCIATION (NFPA) CODES.

REVISIONS

NO.	DATE	DESCRIPTION
1	11-19-63	ISSUED FOR CONSTRUCTION

THIS DOCUMENT
AFFECTED BY
DESIGN CHANGES

FOR OFFICE AND
ENGINEERING USE ONLY

KEY PLAN

THE FINAL GIBBS & HILL, INC. ISSUE
OF DRAWING NO. 2323-AI-0908
IS REVISION NO. 1
DATE 11-19-63

NO.	DATE	DESCRIPTION
1	11-19-63	ISSUED FOR CONSTRUCTION

TEXAS UTILITIES SERVICES INC.

PRIMARY PLANT
ELECTRICAL
CONTROL BUILDING FLOOR PLANS
EL. 572'-0" & 572'-0"

2323-AI-0908

TI
APERTURE
CARD

8605230184

PDR

8605230184

