


C-18021-C  
SHEET 3 OF 3

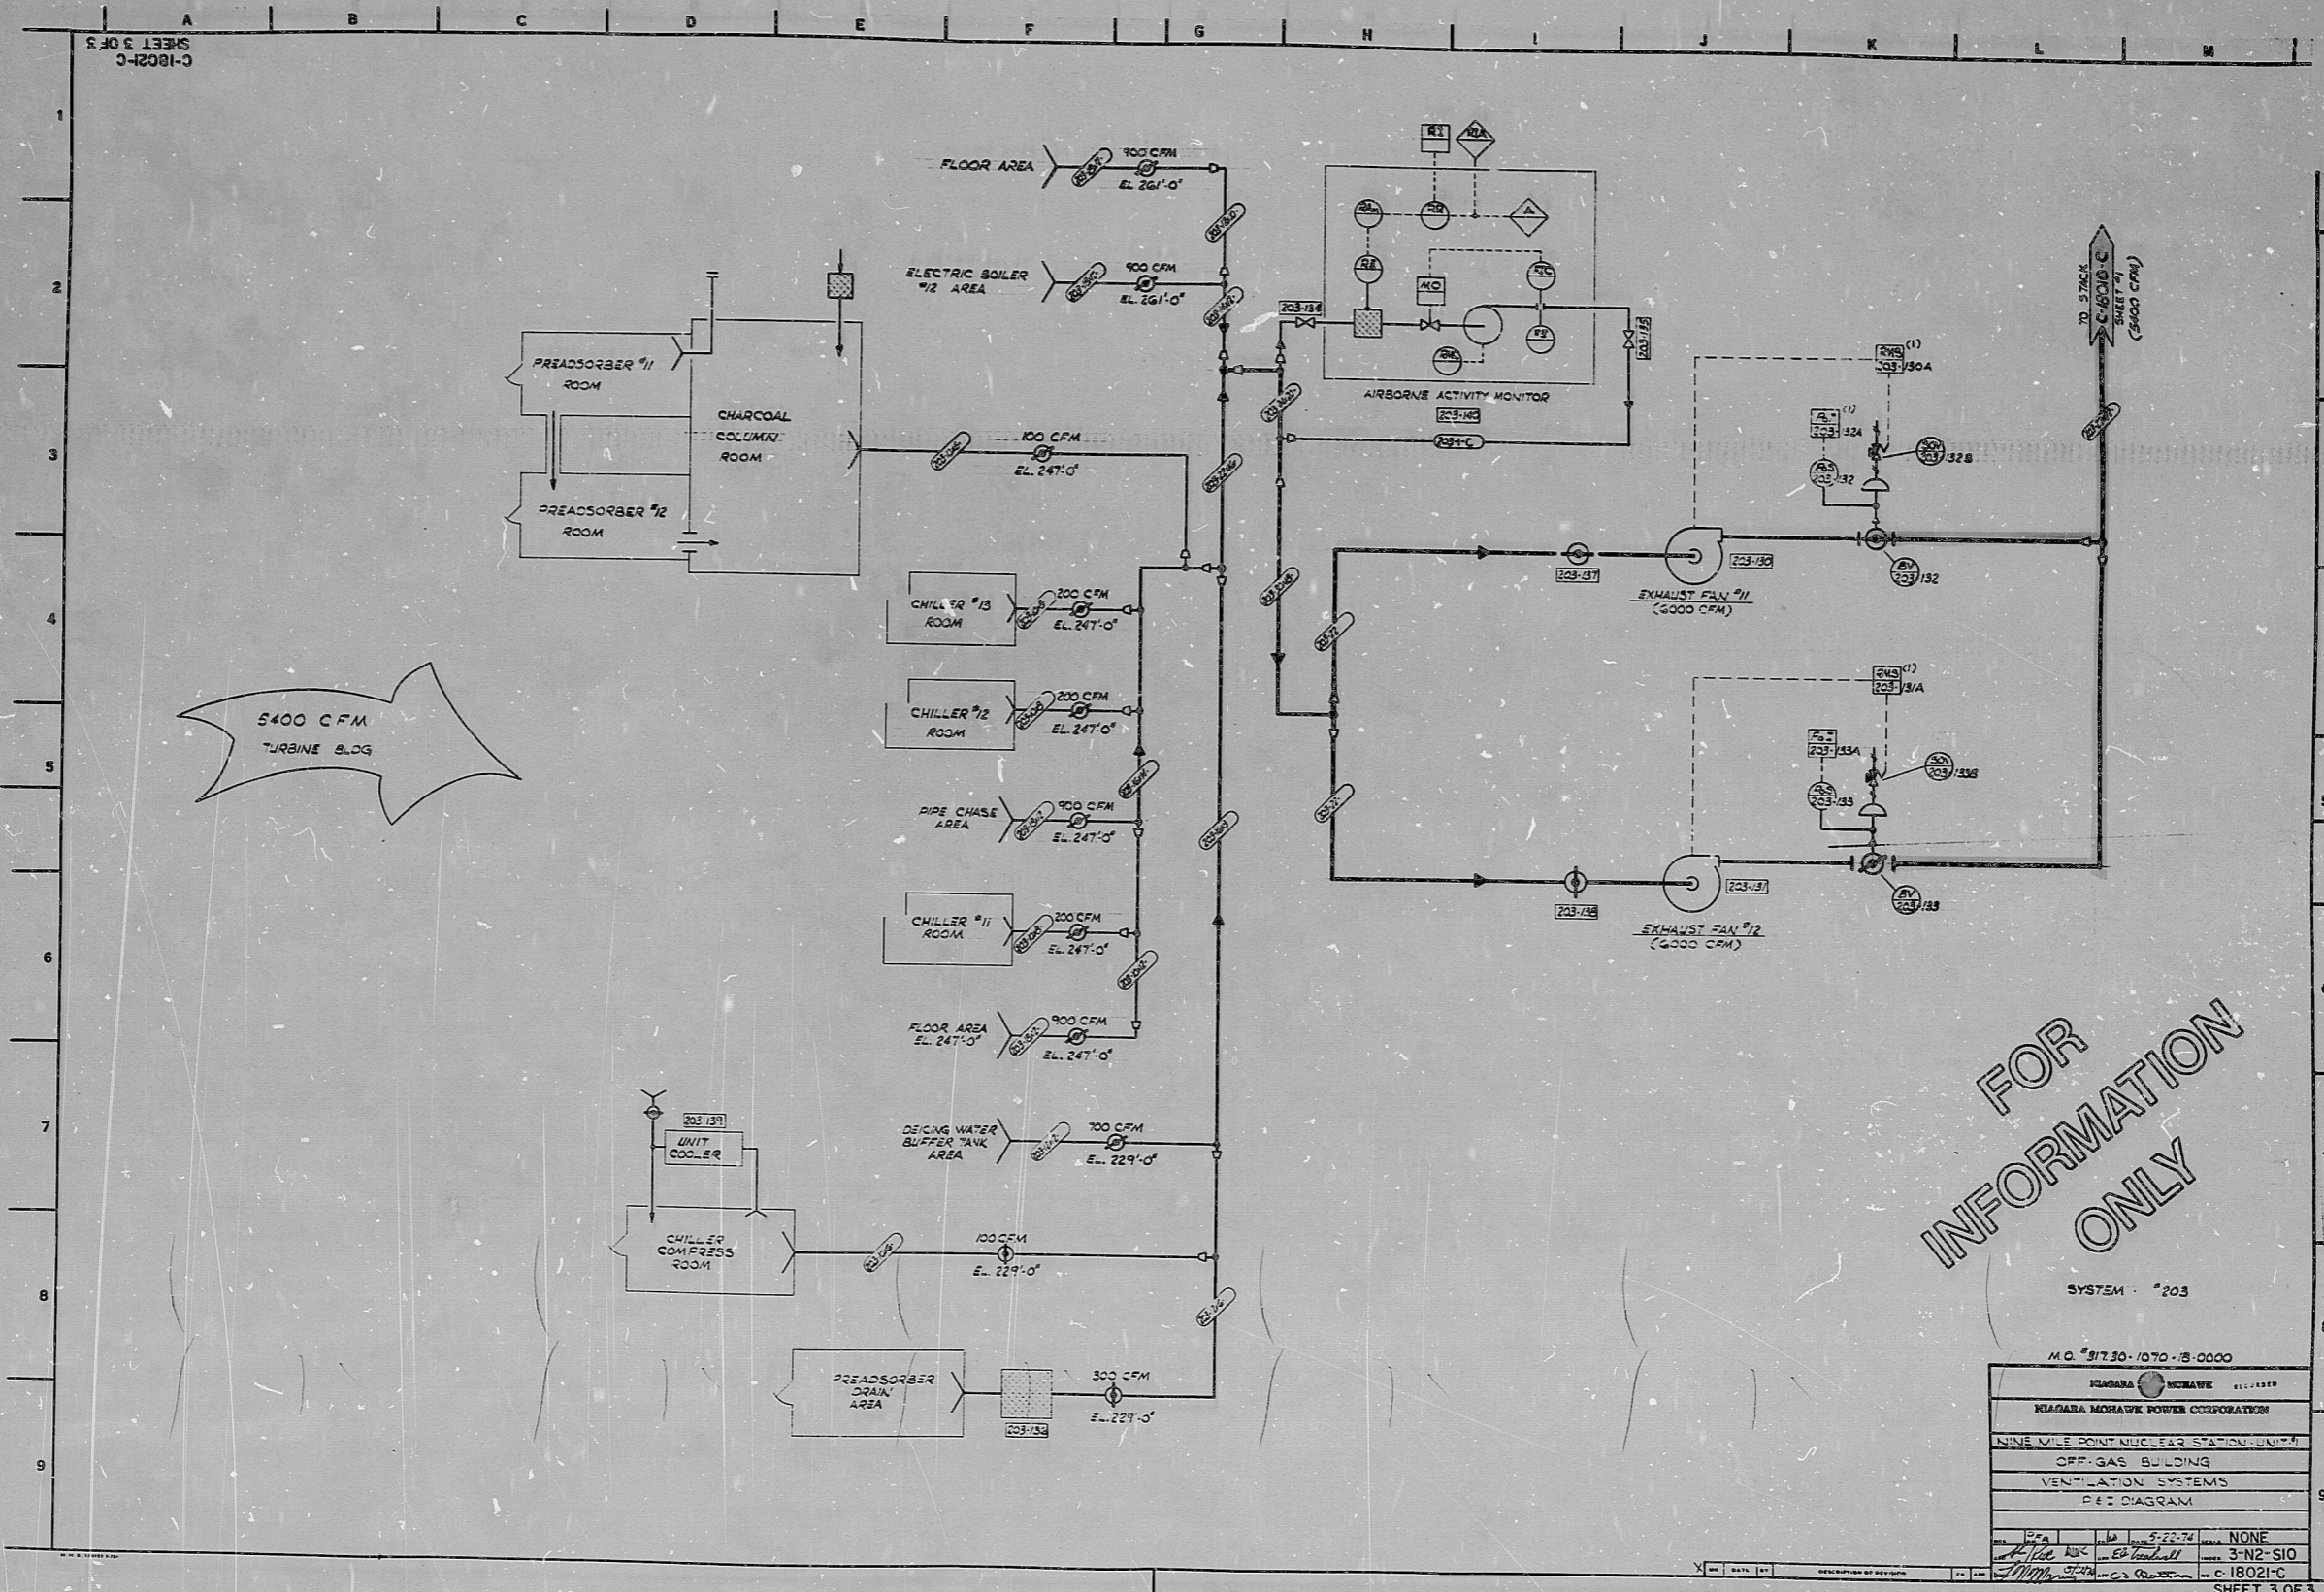

FOR  
INFORMATION  
ONLY

SYSTEM #203

M.D. 5/7/30-1070-13-0000

NIAGARA MOHAWK POWER CORPORATION	
NINE MILE POINT NUCLEAR STATION UNIT #1	
OFF-GAS BUILDING	
VENTILATION SYSTEMS	
P&ID DIAGRAM	
DATE	5-22-74
BY	EB
CHKD BY	EB
APP'D BY	EB
SCALE	NONE
PROJECT	3-N2-SIO
DRAWING NO.	C-18021-C
SHEET 3 OF 3	

30X

TI  
APERTURE  
CARD



PDR RIDS

8610090227

