


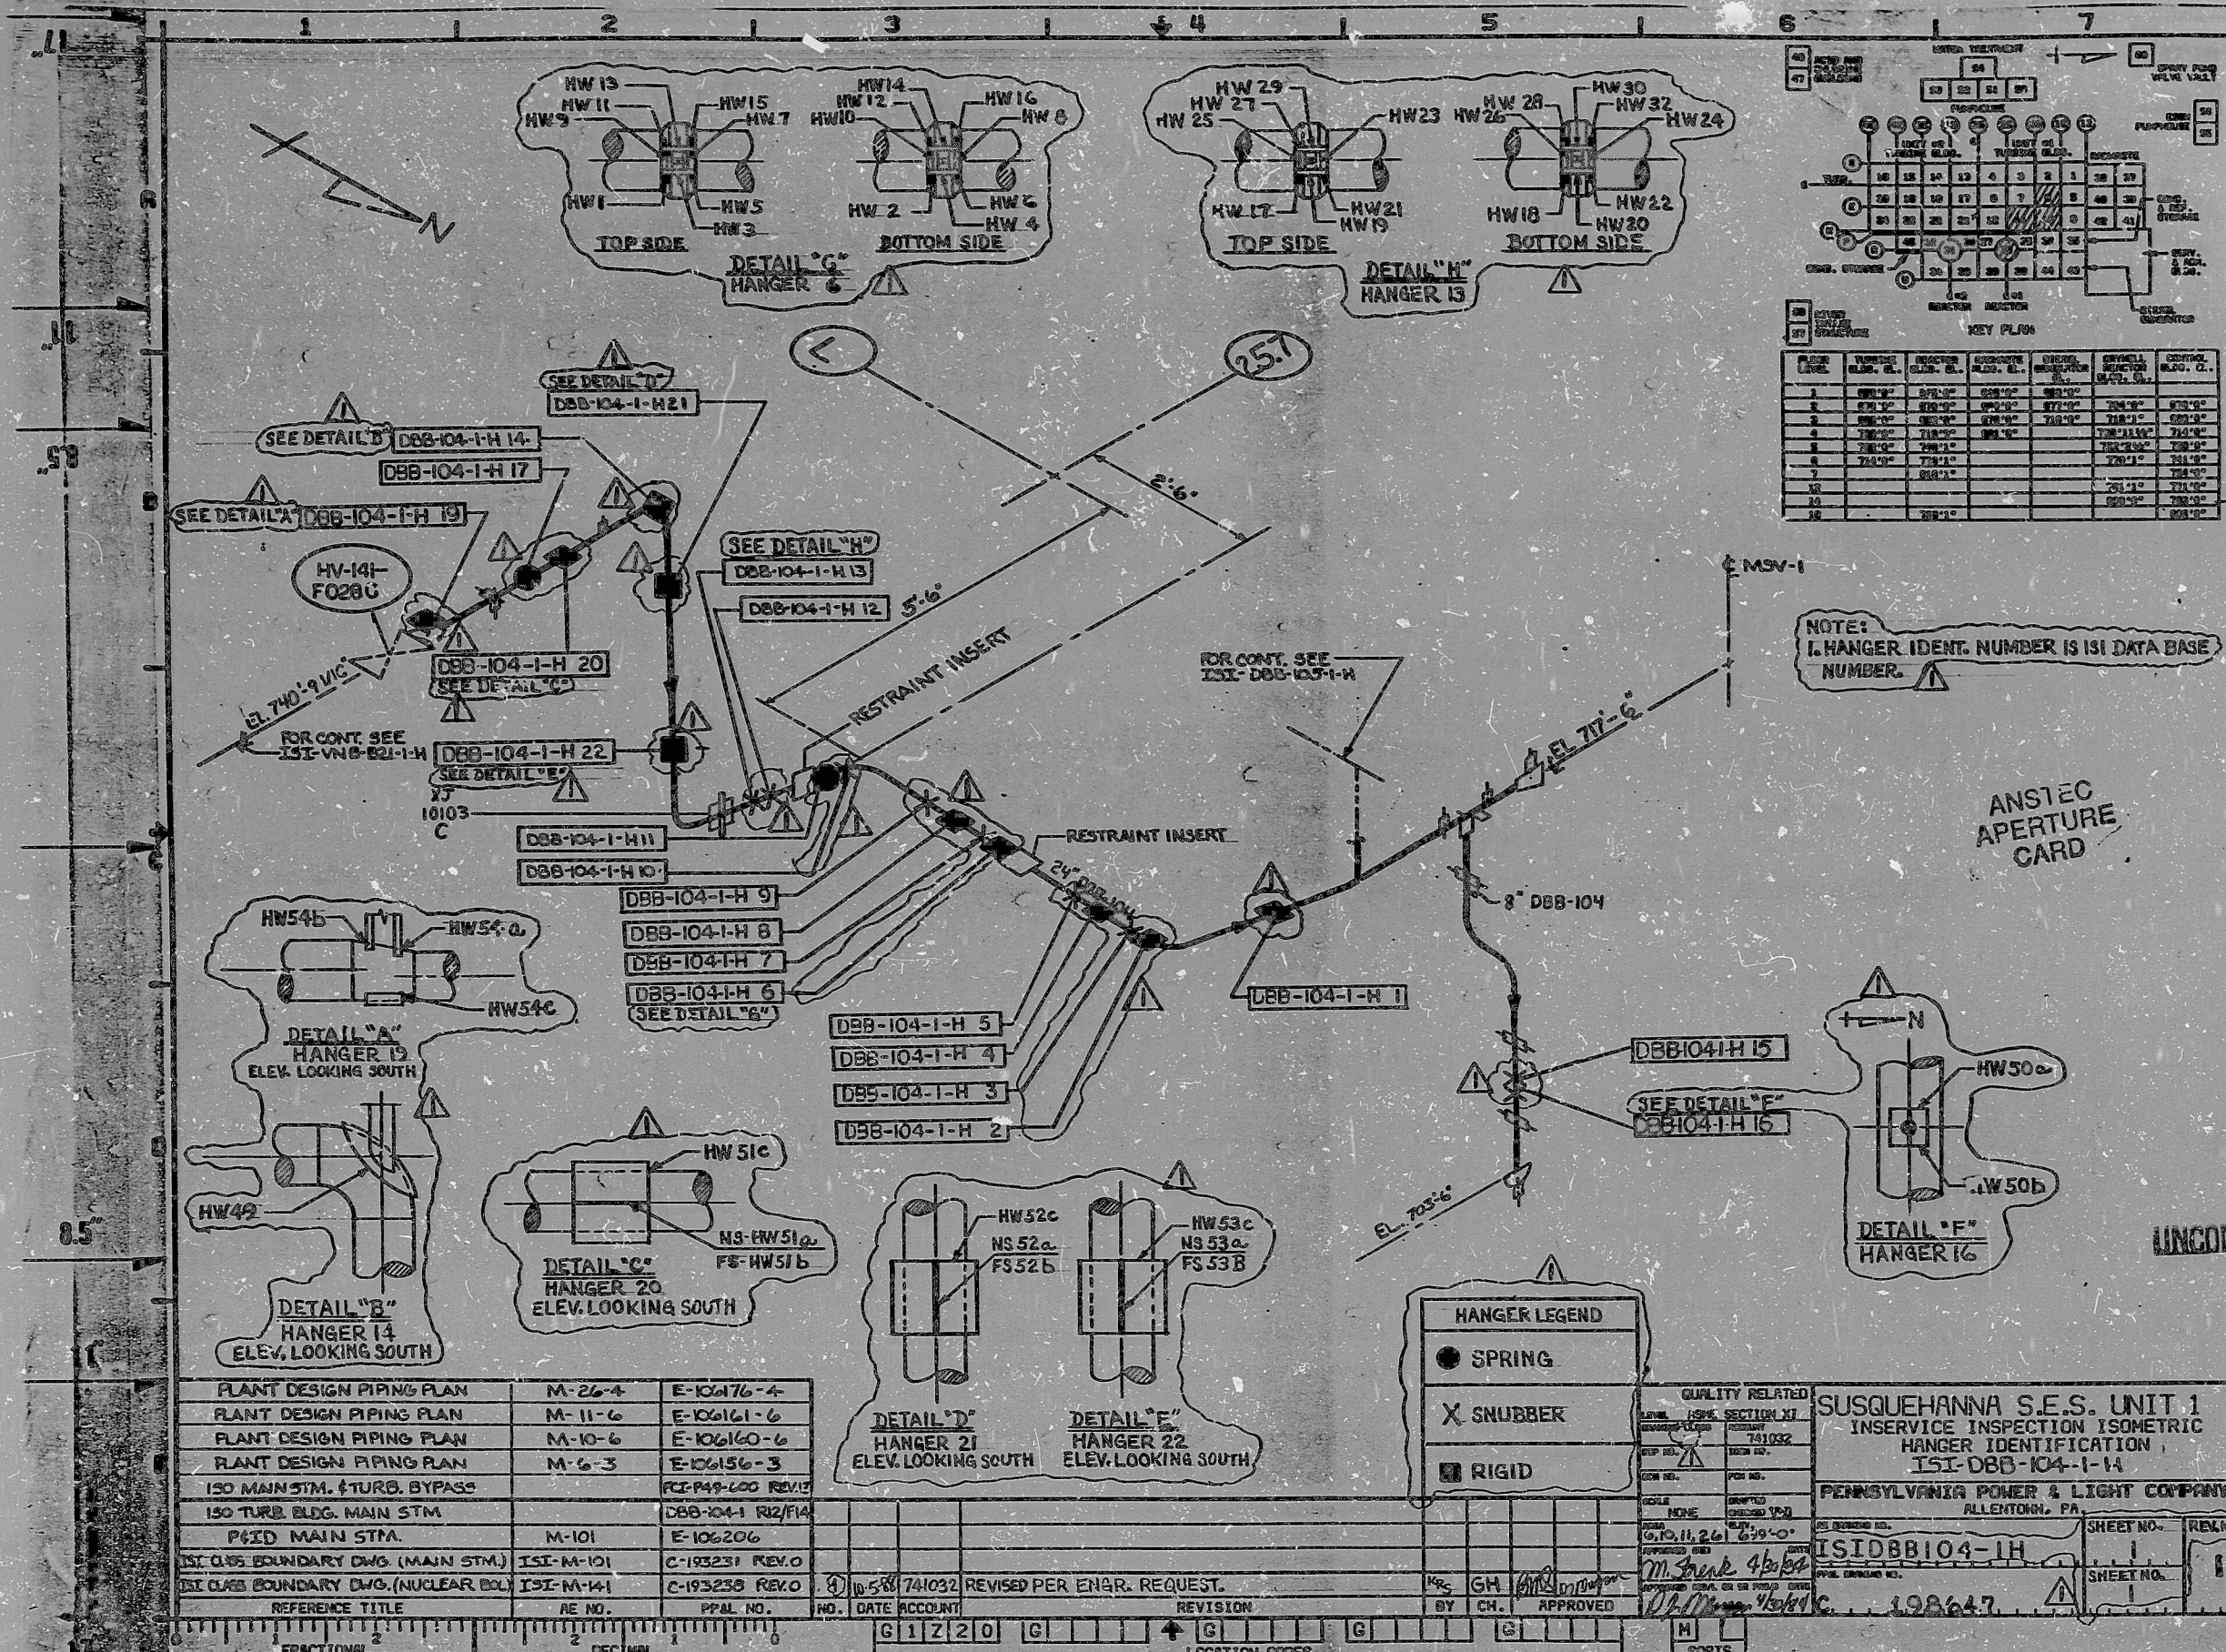

PLANT DESIGN PIPING PLAN	M-26-4	E-106176-4
PLANT DESIGN PIPING PLAN	M-11-6	E-106161-6
PLANT DESIGN PIPING PLAN	M-10-6	E-106160-6
PLANT DESIGN PIPING PLAN	M-6-3	E-106156-3
150 MAIN STM. & TURB. BYPASS		PI-149-600 REV.13
150 TURB. BLDG. MAIN STM		DBB-104-1 R2/F14
P&ID MAIN STM.	M-101	E-106206
ISI CLASS BOUNDARY DWG. (MAIN STM.)	ISI-M-101	C-193231 REV.0
ISI CLASS BOUNDARY DWG. (NUCLEAR BLDG.)	ISI-M-101	C-193238 REV.0
REFERENCE TITLE	RE NO.	PPAL NO.

HANGER LEGEND	
●	SPRING
X	SNUBBER
■	RIGID

QUALITY RELATED	
DATE	10/11/88
SECTION	17
REVISION	741032
BY	CH
APPROVED	
SUSQUEHANNA S.E.S. UNIT 1	
INSERVICE INSPECTION ISOMETRIC	
HANGER IDENTIFICATION	
ISI-DBB-104-1-H	
PENNSYLVANIA POWER & LIGHT COMPANY	
ALLENTOWN, PA.	
SHEET NO.	1
REV. NO.	

16X I CERTIFY THAT THE IMAGE CONTAINED ON THIS FRAME WAS MADE IN THE NORMAL AND REGULAR COURSE OF BUSINESS, ON THE DATE STATED DELIVERED AND THAT IT IS AN ACCURATE REPRODUCTION OF THE DOCUMENT SUBMITTED TO SRMS CORRESPONDENCE AND DRAWING FILES.

PDR RIDS

9507170164

