


205309 A 8762-34

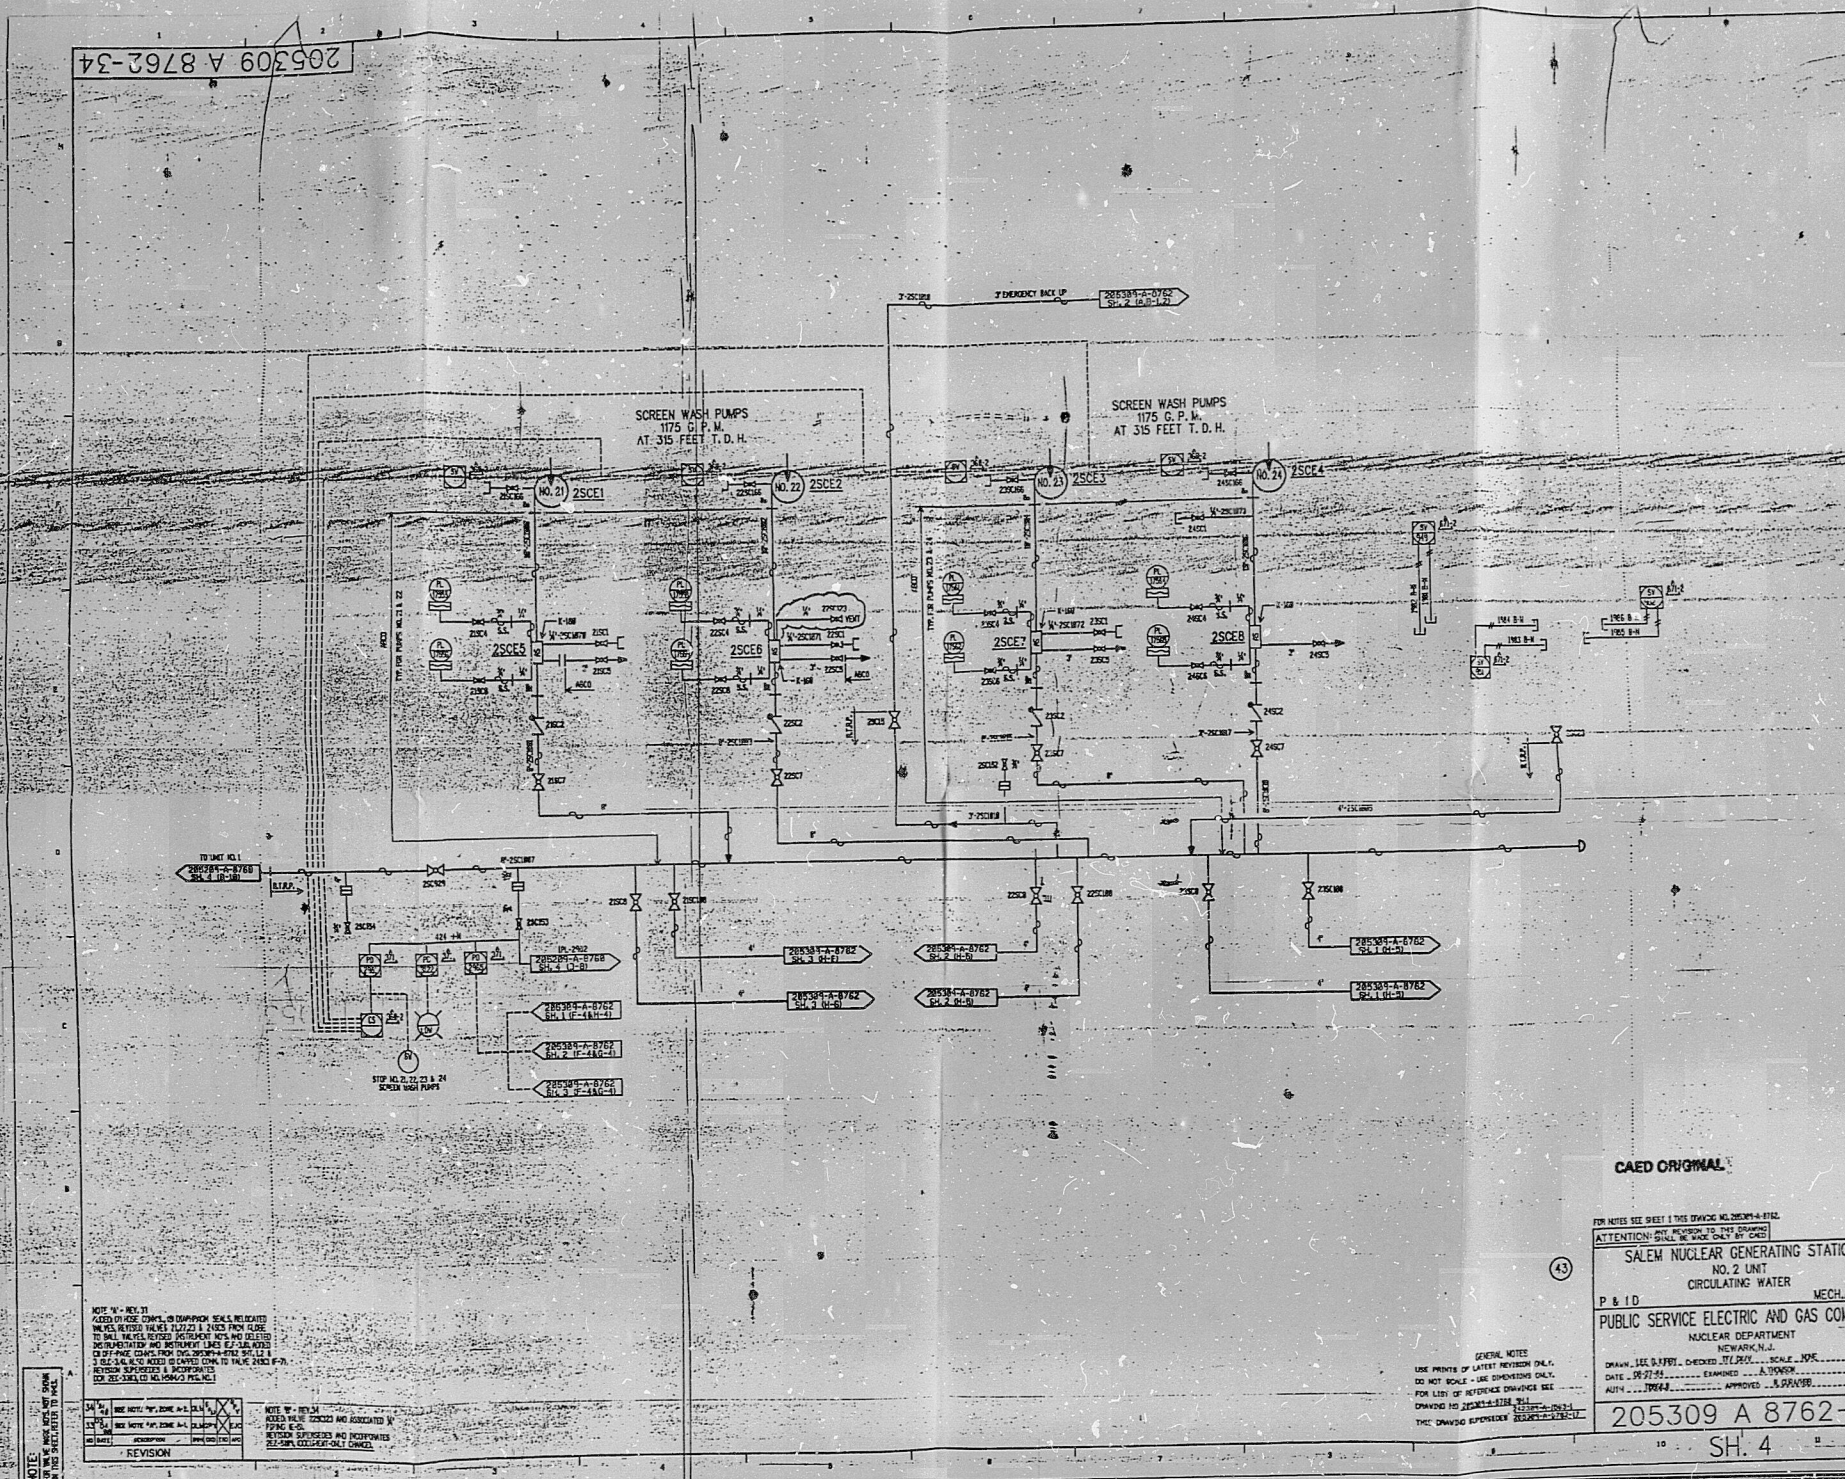

NOT TO SCALE
ALL DIMENSIONS ARE IN FEET
UNLESS OTHERWISE SPECIFIED
FOR LIST OF SYMBOLS SEE
DRAWING NO. 205309 A 8762-34

REVISION	DATE	BY	CHKD	APPD
1	10/27/73	J. J. J.	J. J. J.	J. J. J.
2	11/1/73	J. J. J.	J. J. J.	J. J. J.

NOT TO SCALE
ALL DIMENSIONS ARE IN FEET
UNLESS OTHERWISE SPECIFIED
FOR LIST OF SYMBOLS SEE
DRAWING NO. 205309 A 8762-34

CAED ORIGINAL

FOR NOTES SEE SHEET 1 THIS DRAWING NO. 205309 A 8762-34

ATTENTION: SEE SHEET 1 THIS DRAWING NO. 205309 A 8762-34

SALEM NUCLEAR GENERATING STATION

NO. 2 UNIT

CIRCULATING WATER

MECH/CONT.

P & ID

PUBLIC SERVICE ELECTRIC AND GAS COMPANY

NUCLEAR DEPARTMENT

NEWARK, N.J.

DRAWN: J. J. J. CHECKED: J. J. J. SCALE: 1/8" = 1'-0"

DATE: 10/27/73 EXAMINED: J. J. J.

APPROVED: J. J. J.

205309 A 8762-34

SH. 4

APERTURE
CARD

205309 A 8762-34

9904150106

FDR RIDS

9904150106

