


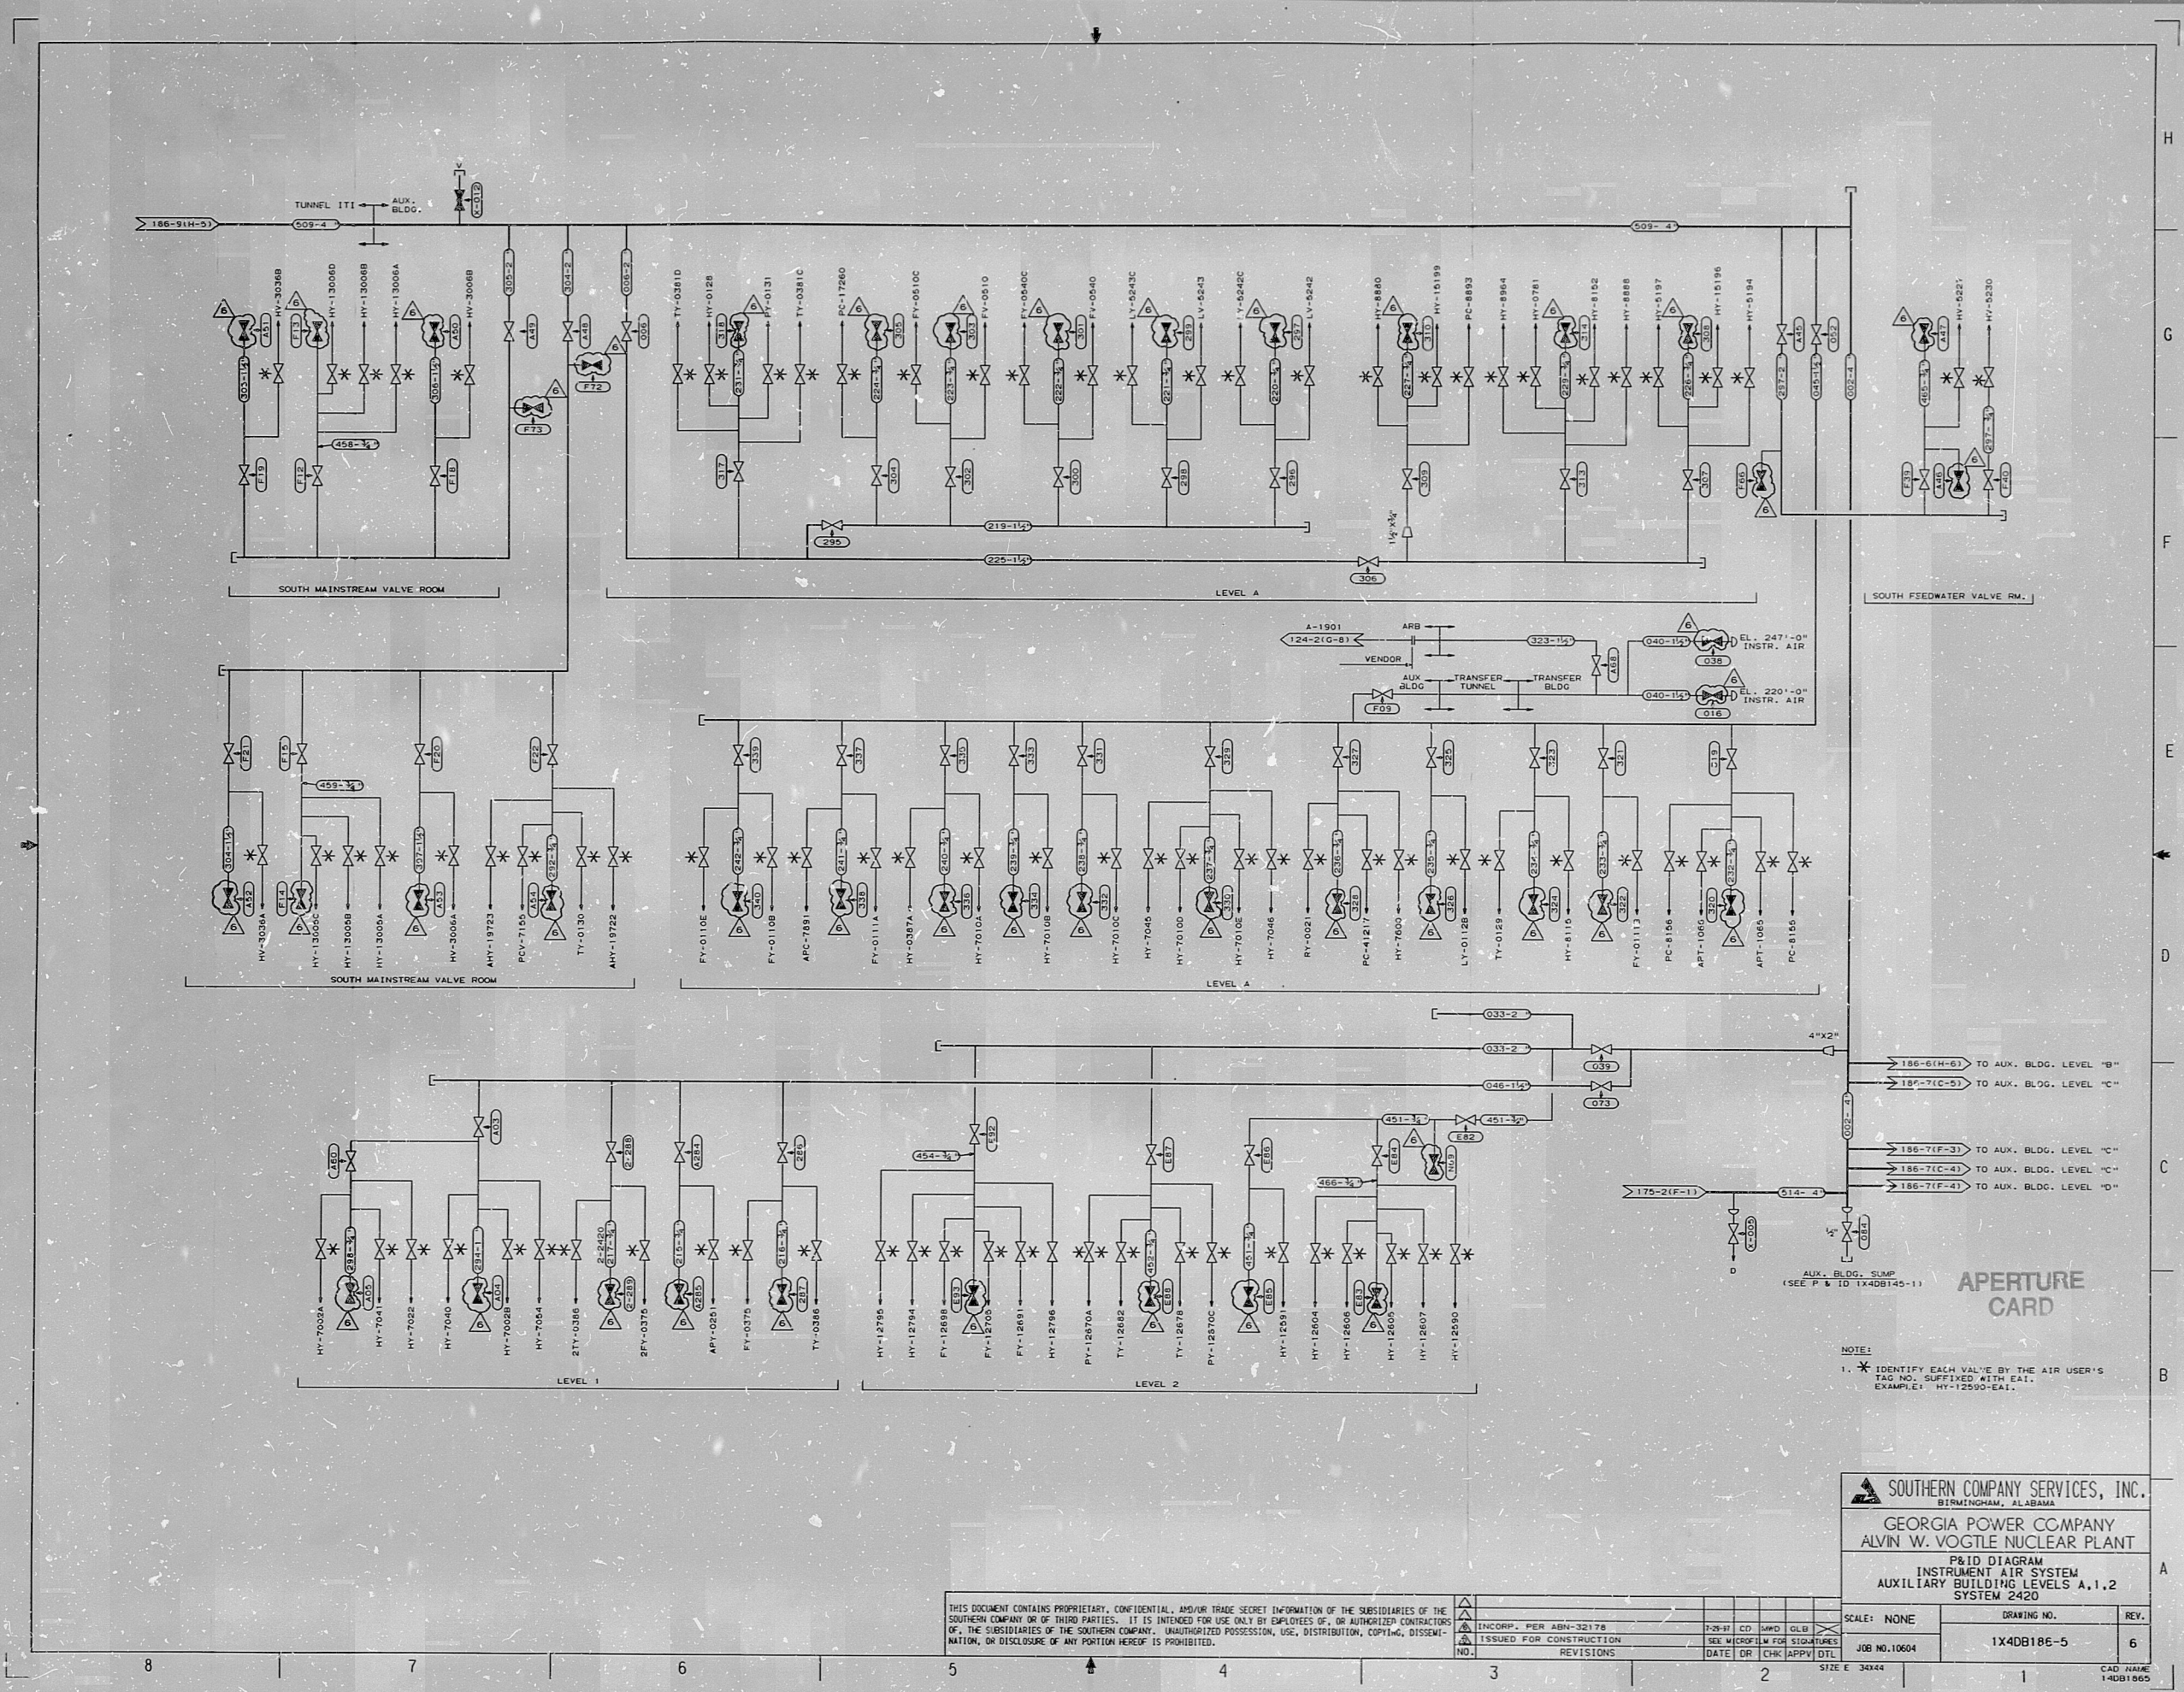

NOTE:
1. * IDENTIFY EACH VALVE BY THE AIR USER'S TAG NO. SUFFIXED WITH EAL.
EXAMPLE: HY-12595-EAL.

APERTURE CARD

SOUTHERN COMPANY SERVICES, INC.
BIRMINGHAM, ALABAMA
GEORGIA POWER COMPANY
ALVIN W. VOGLE NUCLEAR PLANT
P&ID DIAGRAM
INSTRUMENT AIR SYSTEM
AUXILIARY BUILDING LEVELS A, 1, 2
SYSTEM 2420

THIS DOCUMENT CONTAINS PROPRIETARY, CONFIDENTIAL, AND/OR TRADE SECRET INFORMATION OF THE SUBSIDIARIES OF THE SOUTHERN COMPANY OR OF THIRD PARTIES. IT IS INTENDED FOR USE ONLY BY EMPLOYEES OF, OR AUTHORIZED CONTRACTORS OF, THE SUBSIDIARIES OF THE SOUTHERN COMPANY. UNAUTHORIZED POSSESSION, USE, DISTRIBUTION, COPYING, DISSEMINATION, OR DISCLOSURE OF ANY PORTION HEREOF IS PROHIBITED.

SCALE: NONE	DRAWING NO. 1X4DB186-5	REV. 6
INCORP. PER ABN-32178	DATE 7-29-87	CD LMD GLE
ISSUED FOR CONSTRUCTION	REV MICROFILM FOR SIGNATURES	JOB NO. 10604
NO. 1	DATE 10-1-87	CHK APPV DTL
REV 1	DATE 10-1-87	CHK APPV DTL
REV 2	DATE 10-1-87	CHK APPV DTL
REV 3	DATE 10-1-87	CHK APPV DTL
REV 4	DATE 10-1-87	CHK APPV DTL
REV 5	DATE 10-1-87	CHK APPV DTL
REV 6	DATE 10-1-87	CHK APPV DTL
REV 7	DATE 10-1-87	CHK APPV DTL
REV 8	DATE 10-1-87	CHK APPV DTL
REV 9	DATE 10-1-87	CHK APPV DTL
REV 10	DATE 10-1-87	CHK APPV DTL
REV 11	DATE 10-1-87	CHK APPV DTL
REV 12	DATE 10-1-87	CHK APPV DTL
REV 13	DATE 10-1-87	CHK APPV DTL
REV 14	DATE 10-1-87	CHK APPV DTL
REV 15	DATE 10-1-87	CHK APPV DTL
REV 16	DATE 10-1-87	CHK APPV DTL
REV 17	DATE 10-1-87	CHK APPV DTL
REV 18	DATE 10-1-87	CHK APPV DTL
REV 19	DATE 10-1-87	CHK APPV DTL
REV 20	DATE 10-1-87	CHK APPV DTL

9910130034

PDR RIDS

091013 0034

