


9699-FE-1C

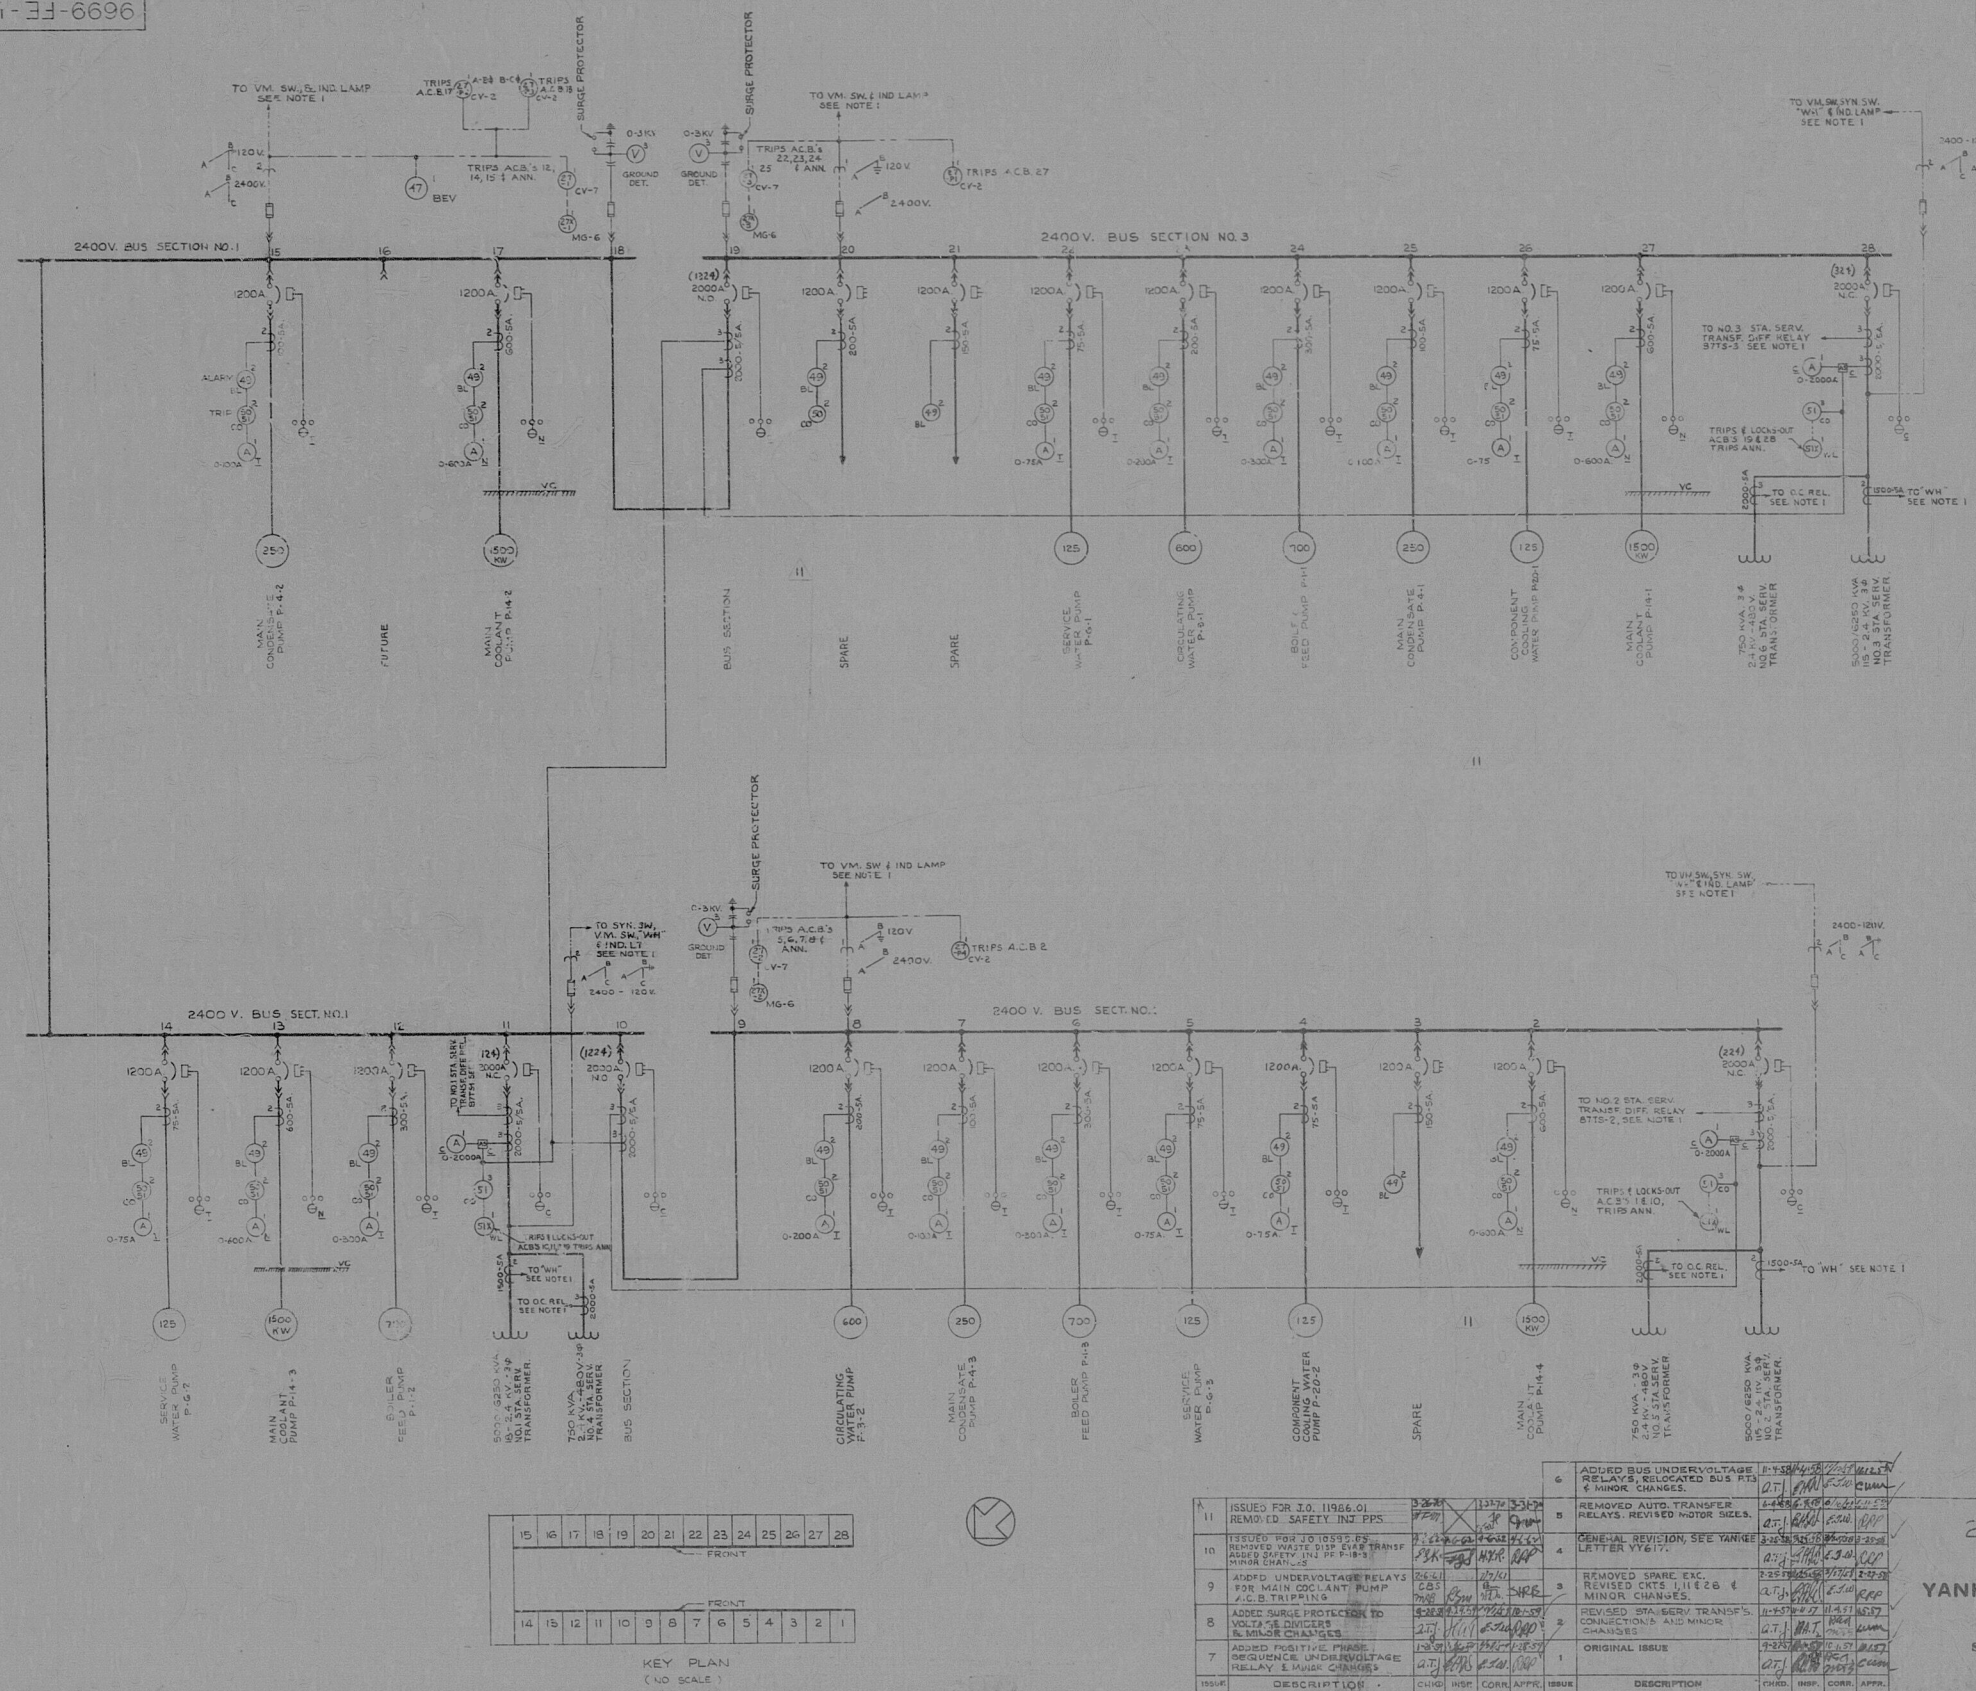

LEGEND:

DEVICE NUMBERS:

NOTES:

2400V ONE LINE DIAGRAM

POWER STATION
YANKEE ATOMIC ELECTRIC COMPANY
ROWE, MASS.

STONE & WEBSTER ENGINEERING CORPORATION

DRAWING NUMBER 9699-FE-1C

NO.	DESCRIPTION	CHG.	REV.	DATE	APP.	NO.	DESCRIPTION	CHG.	REV.	DATE	APP.
1	ISSUED FOR I.O. 11964.01			12/17/53		6	ADDED BUS UNDERVOLTAGE RELAYS, RELOCATED BUS RT'S			12/17/53	
2	REMOVED SAFETY INT. PPS			12/17/53		7	REMOVED AUTO. TRANSFER RELAYS, REVISED MOTOR SIZES			12/17/53	
3	ISSUED FOR I.O. 10335.05			12/17/53		8	GENERAL REVISION SEE YANKEE LETTER YTG-17			12/17/53	
4	REMOVED WASTE DISPOSAL TRANSFER			12/17/53		9	REMOVED SPARE EXC. REVISED CTS 1, 11, 12, 28 & MINOR CHANGES			12/17/53	
5	ADDED UNDERVOLTAGE RELAYS FOR MAIN DECONT. PUMP			12/17/53		10	REMOVED SPARE TRANS. CONNECTIONS AND MINOR CHANGES			12/17/53	
6	ADDED SURGE PROTECTION TO VOLTAGE DIVIDERS			12/17/53		11	ORIGINAL ISSUE			12/17/53	
7	ADDED POSITIVE PHASE SEQUENCE UNDERVOLTAGE RELAY & MINOR CHANGES			12/17/53							

CHECKED BY: [Signature] CHECKED BY: [Signature] CHECKED BY: [Signature] CHECKED BY: [Signature]

9699

FE-1C

11 2400V ONLINE DIAG

29X

DDAELE

NRCA ANP GF EB045

8104060135

