


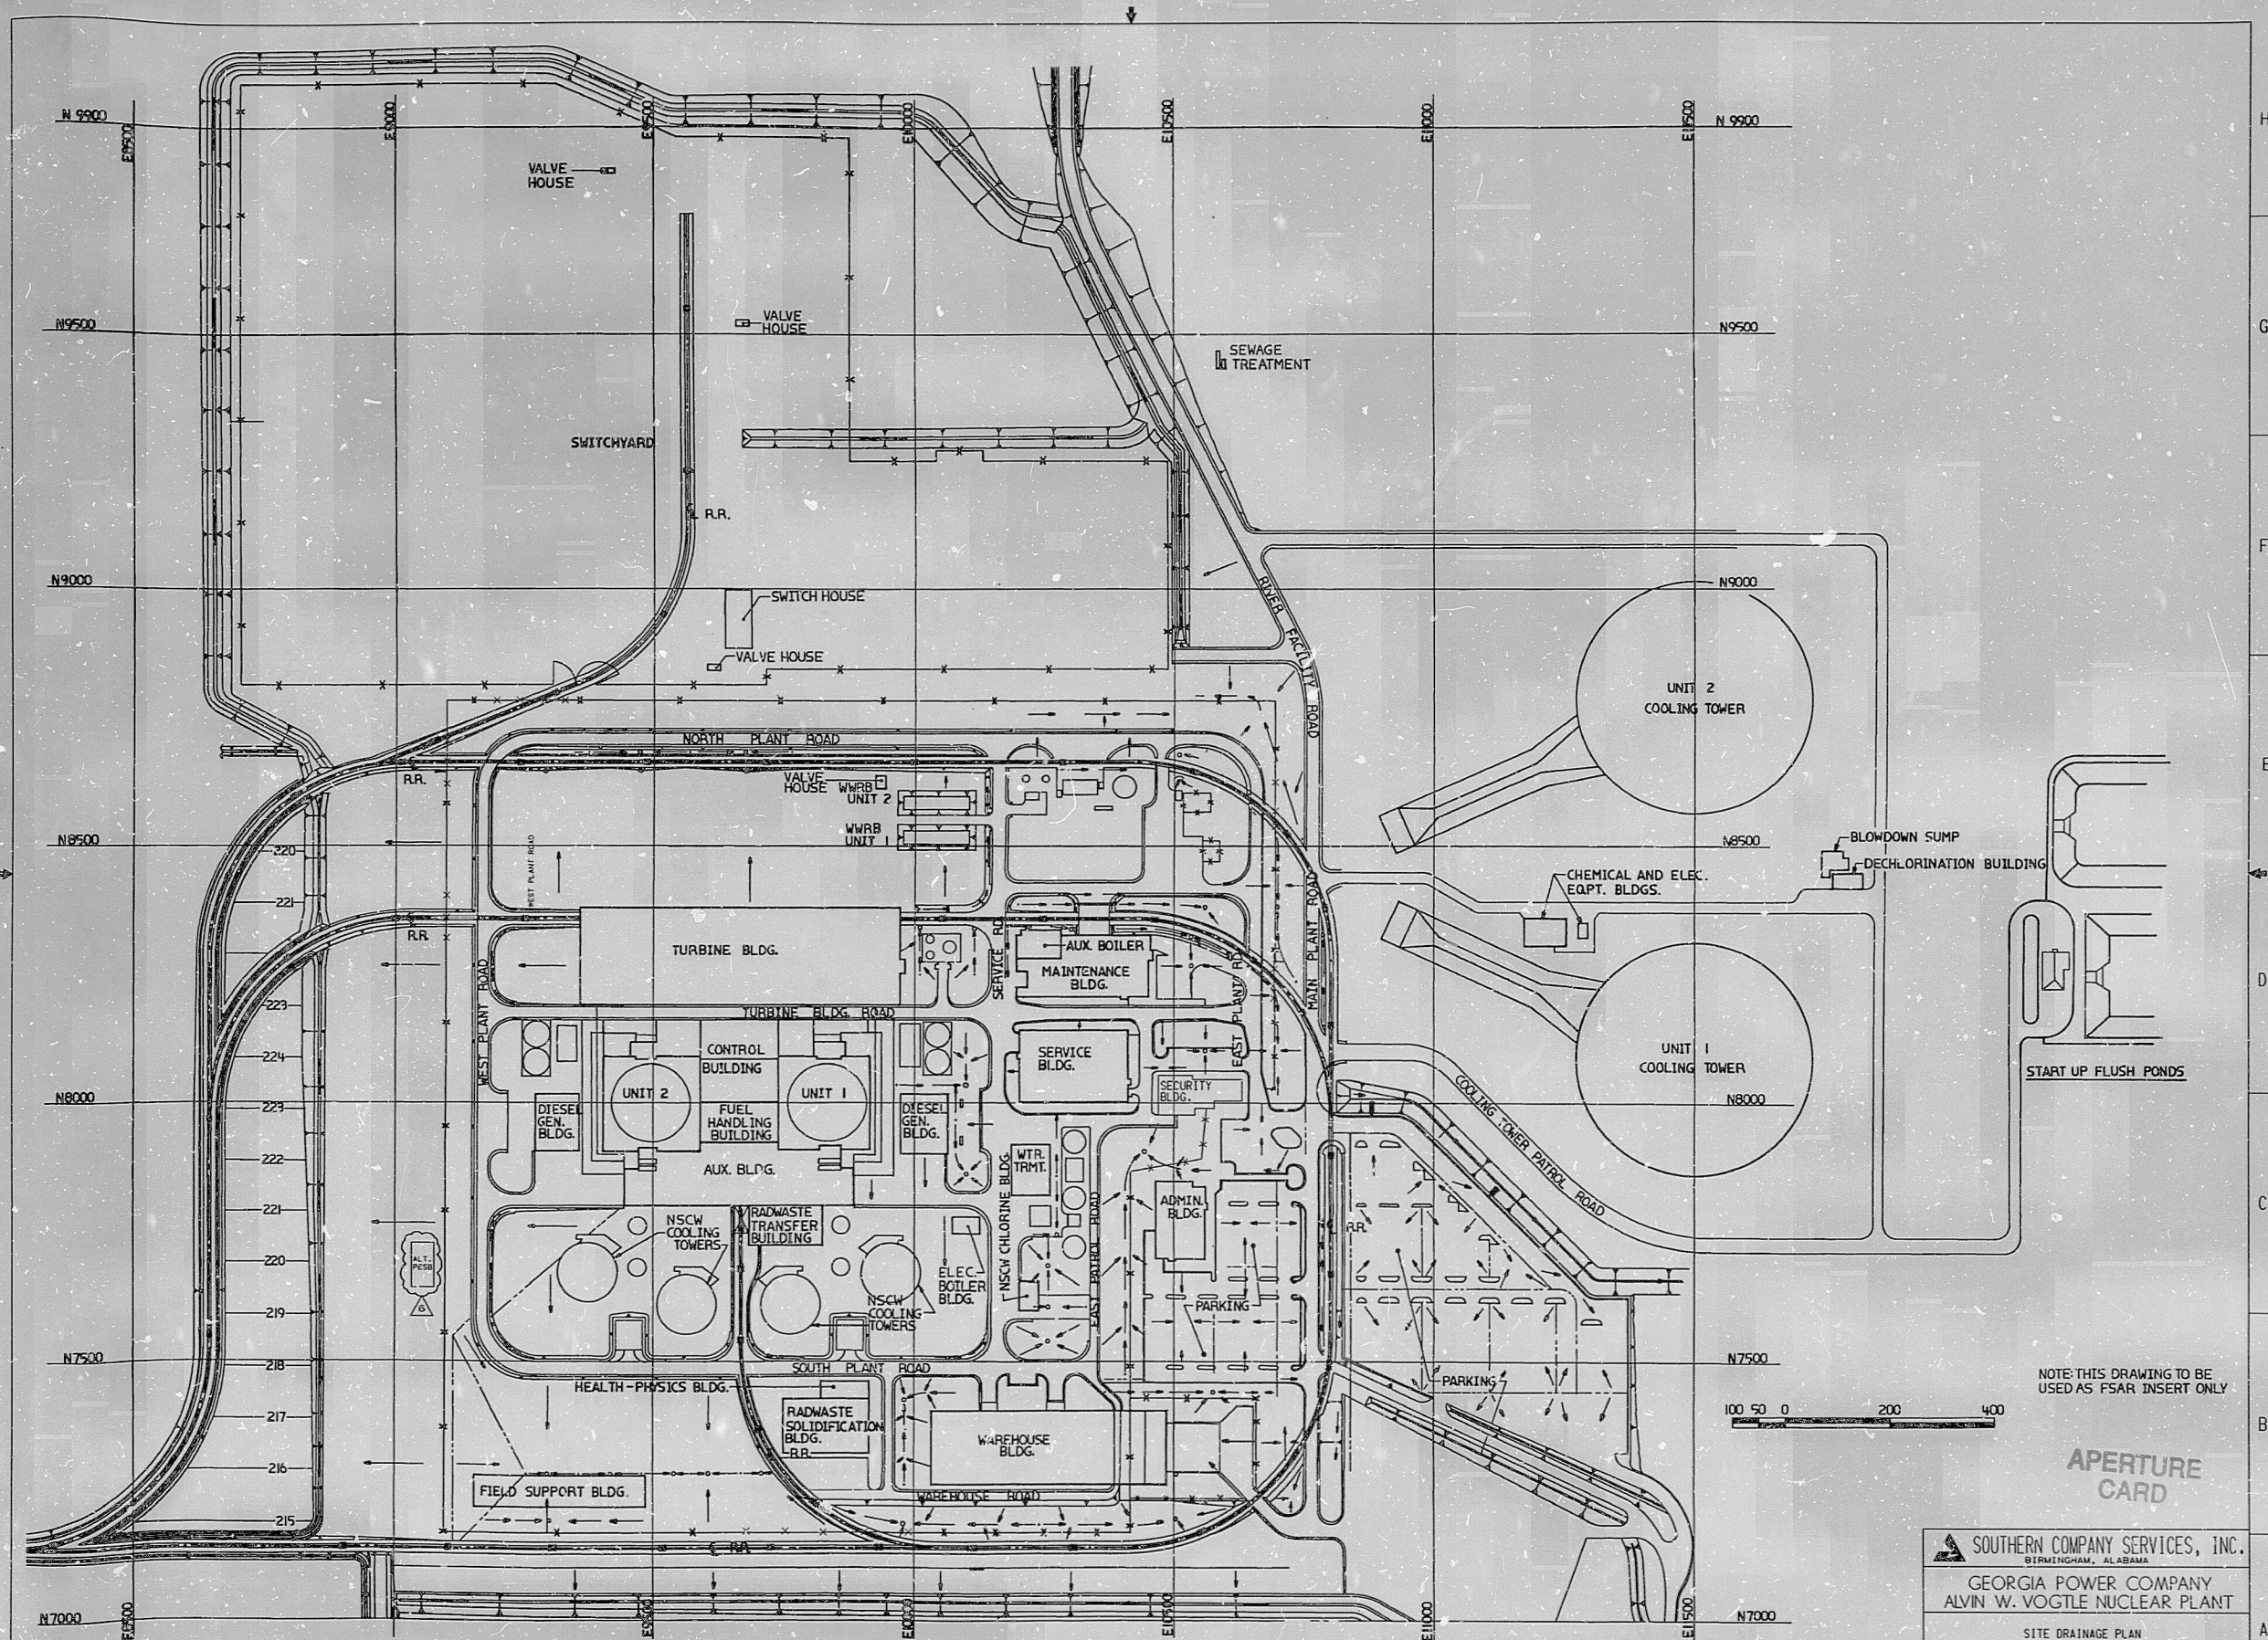

NOTE: THIS DRAWING TO BE USED AS FSAR INSERT ONLY

APERTURE CARD

SOUTHERN COMPANY SERVICES, INC.
BIRMINGHAM, ALABAMA
GEORGIA POWER COMPANY
ALVIN W. VOGTLE NUCLEAR PLANT

SITE DRAINAGE PLAN
100 YEAR, 6 HOUR STORM

THIS DOCUMENT CONTAINS PROPRIETARY, CONFIDENTIAL, AND/OR TRADE SECRET INFORMATION OF THE SUBSIDIARIES OF THE SOUTHERN COMPANY OR OF THIRD PARTIES. IT IS INTENDED FOR USE ONLY BY EMPLOYEES OF, OR AUTHORIZED CONTRACTORS OF, THE SUBSIDIARIES OF THE SOUTHERN COMPANY. UNAUTHORIZED POSSESSION, USE, DISTRIBUTION, COPYING, DISSEMINATION, OR DISCLOSURE OF ANY PORTION HEREOF IS PROHIBITED.

NO.	REVISIONS	DATE	CHK	APPV	DTL
1	ISSUED FOR CONSTRUCTION				
2					
3					
4					
5					
6					

SCALE: 1"=100'	DRAWING NO.	REV.
JOB NO. 10604	CX2046-005	6
CAD NAME: C246V005		

9910180032

9910180032

~~REDACTED~~
PDR RIDS

~~SENSITIVE DATA~~

