


NPR 2

NORTHEAST UTILITIES

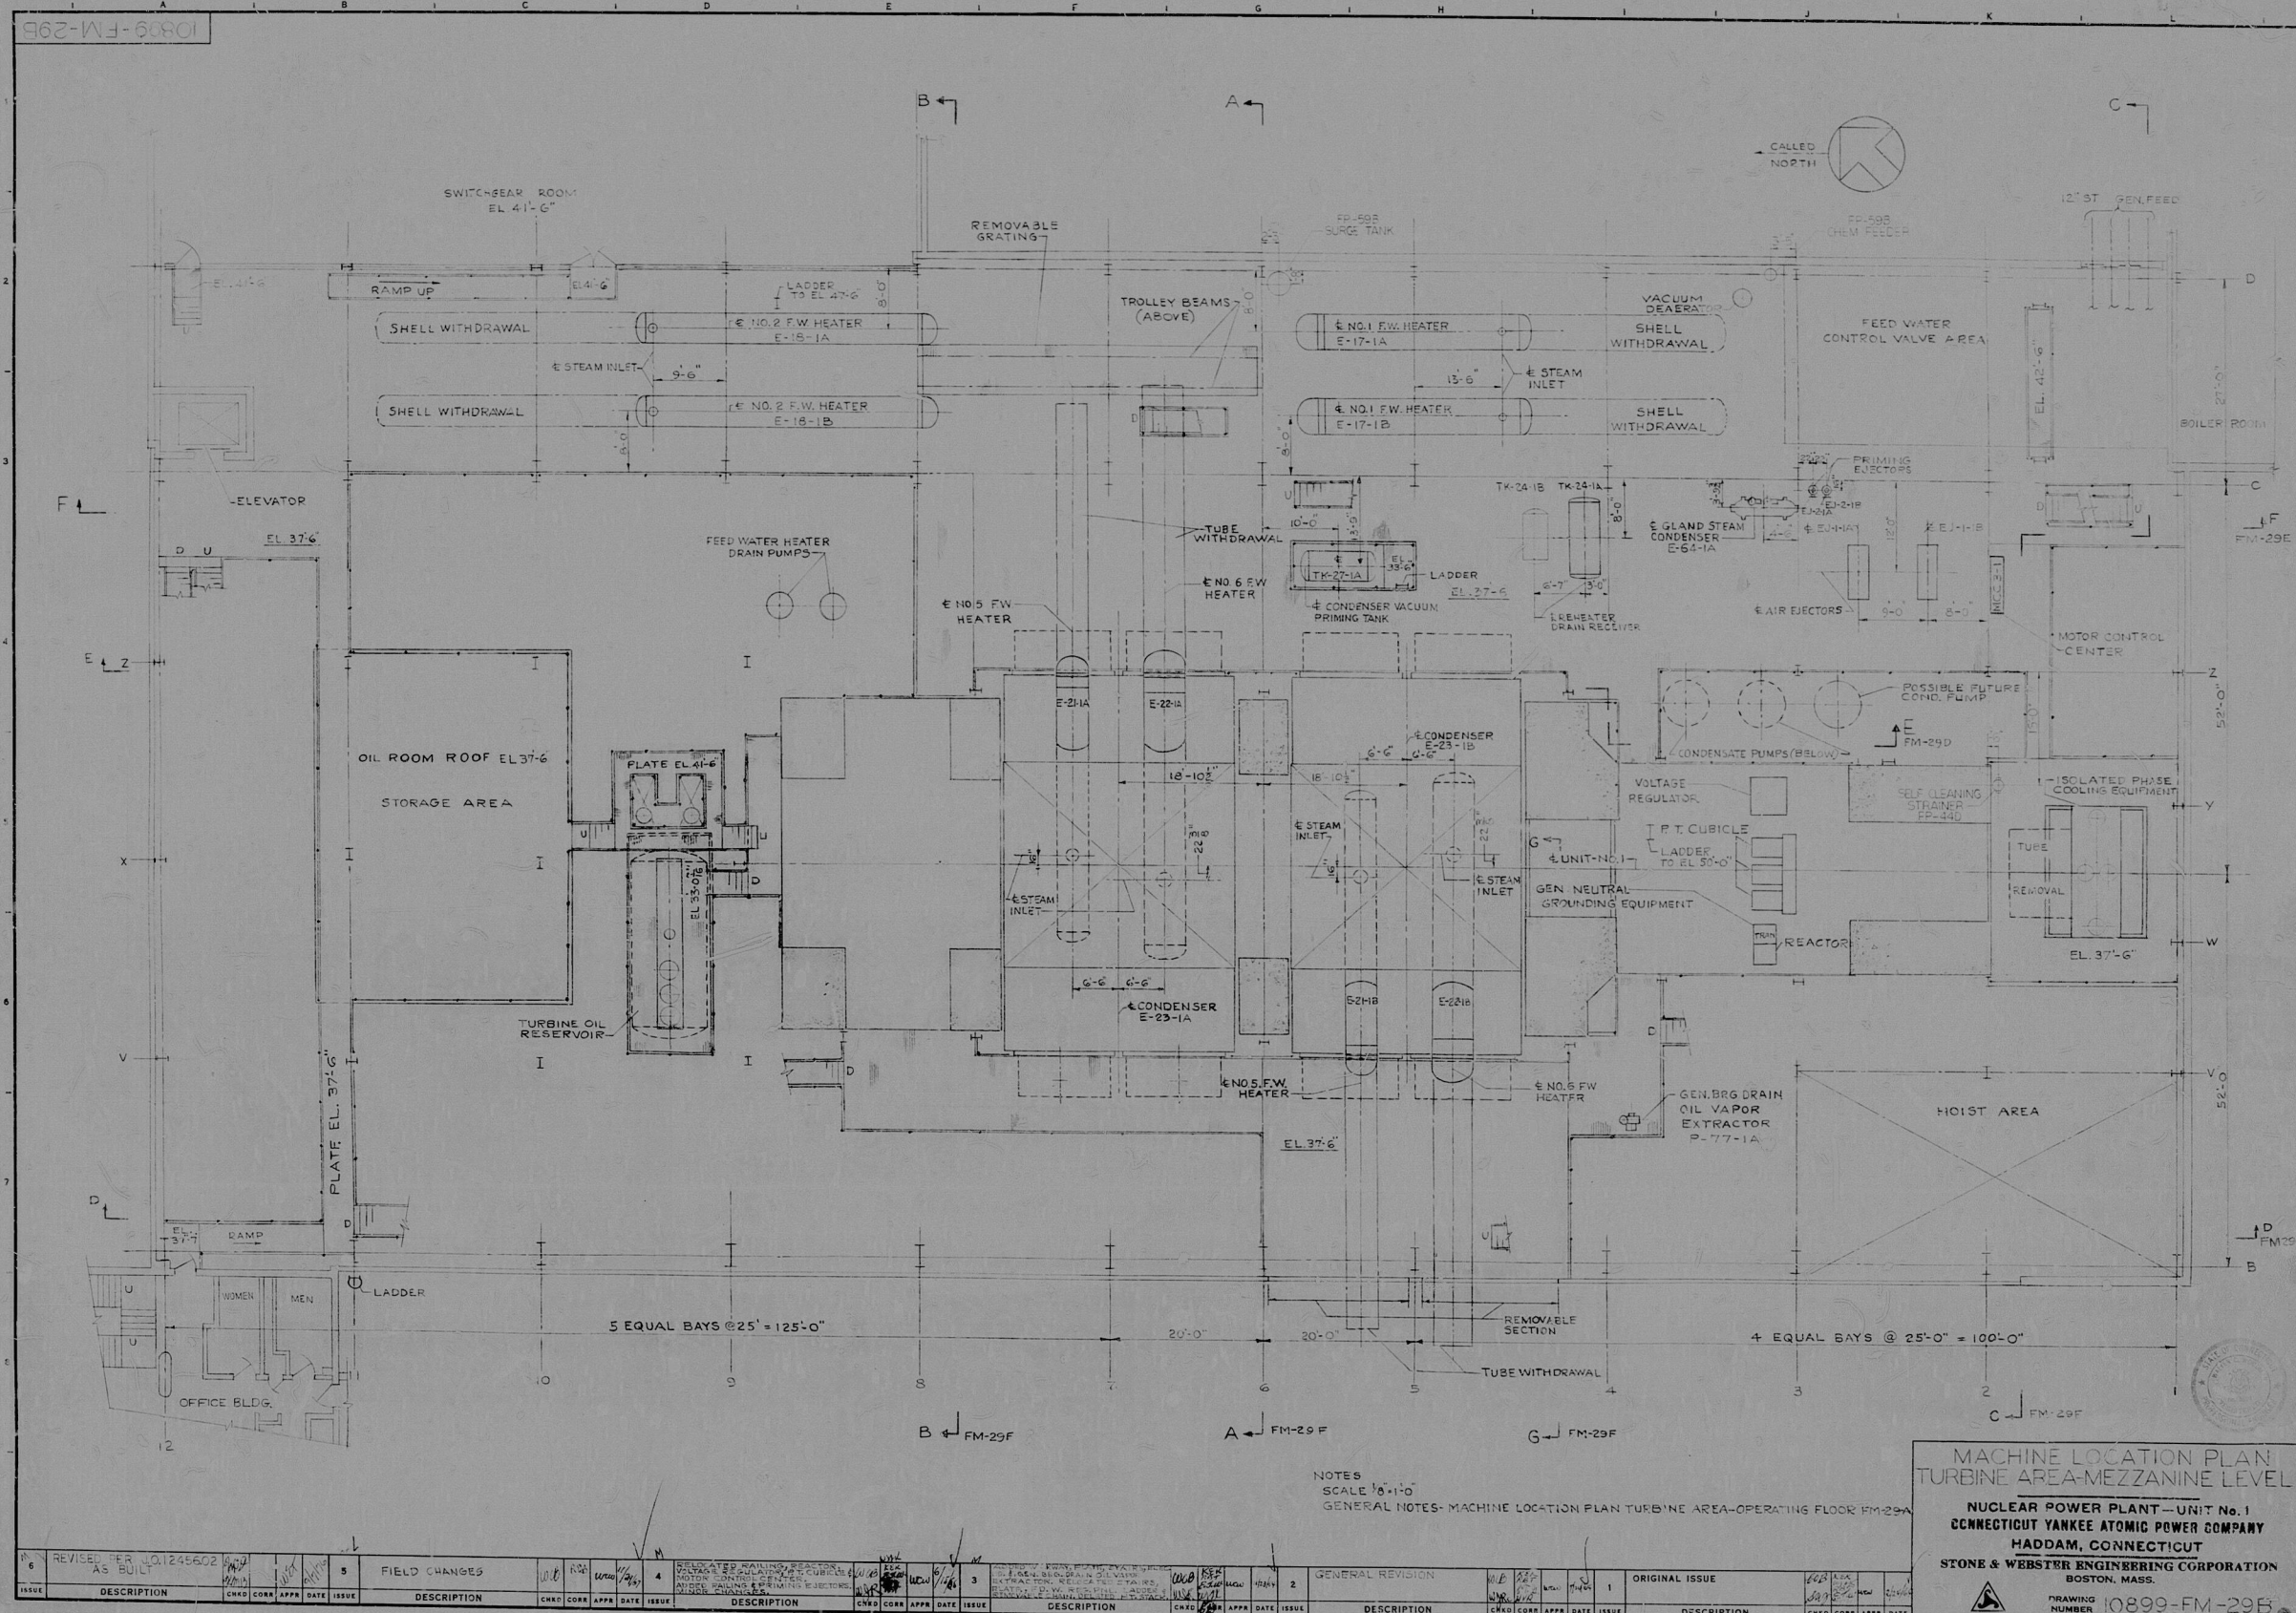

NOTES
SCALE 1/8"=1'-0"
GENERAL NOTES-MACHINE LOCATION PLAN TURBINE AREA-OPERATING FLOOR FM-29A

MACHINE LOCATION PLAN
TURBINE AREA-MEZZANINE LEVEL
NUCLEAR POWER PLANT-UNIT No. 1
CONNECTICUT YANKEE ATOMIC POWER COMPANY
HADDAM, CONNECTICUT
STONE & WEBSTER ENGINEERING CORPORATION
BOSTON, MASS.
DRAWING NUMBER 10899-FM-29B

REVISION	DESCRIPTION	DATE	BY	CHKD	APPD	DATE	REVISION	DESCRIPTION	DATE	BY	CHKD	APPD	DATE	REVISION	DESCRIPTION	DATE	BY	CHKD	APPD	DATE	REVISION	DESCRIPTION	DATE	BY	CHKD	APPD	DATE	REVISION	DESCRIPTION	DATE	BY	CHKD	APPD	DATE
1	REVISION FOR 101245602	10/1/60	WJH	WJH	WJH	10/1/60	2	FIELD CHANGES	10/1/60	WJH	WJH	WJH	10/1/60	3	GENERAL REVISION	10/1/60	WJH	WJH	WJH	10/1/60	4	GENERAL REVISION	10/1/60	WJH	WJH	WJH	10/1/60	5	GENERAL REVISION	10/1/60	WJH	WJH	WJH	10/1/60

16103-27053

DDAFAC

8104220624

