




ARRGT- PRIMARY AUXILIARY BUILDING SHEET 1
 NUCLEAR POWER PLANT - UNIT No. 1
 CONNECTICUT YANKEE ATOMIC POWER COMPANY
 HADDAM, CONNECTICUT
 STONE & WEBSTER ENGINEERING CORPORATION
 BOSTON, MASS.
 DRAWING NUMBER 10899-FM-25A
 10103-27042 SH 1

8104220631

DDAFAC

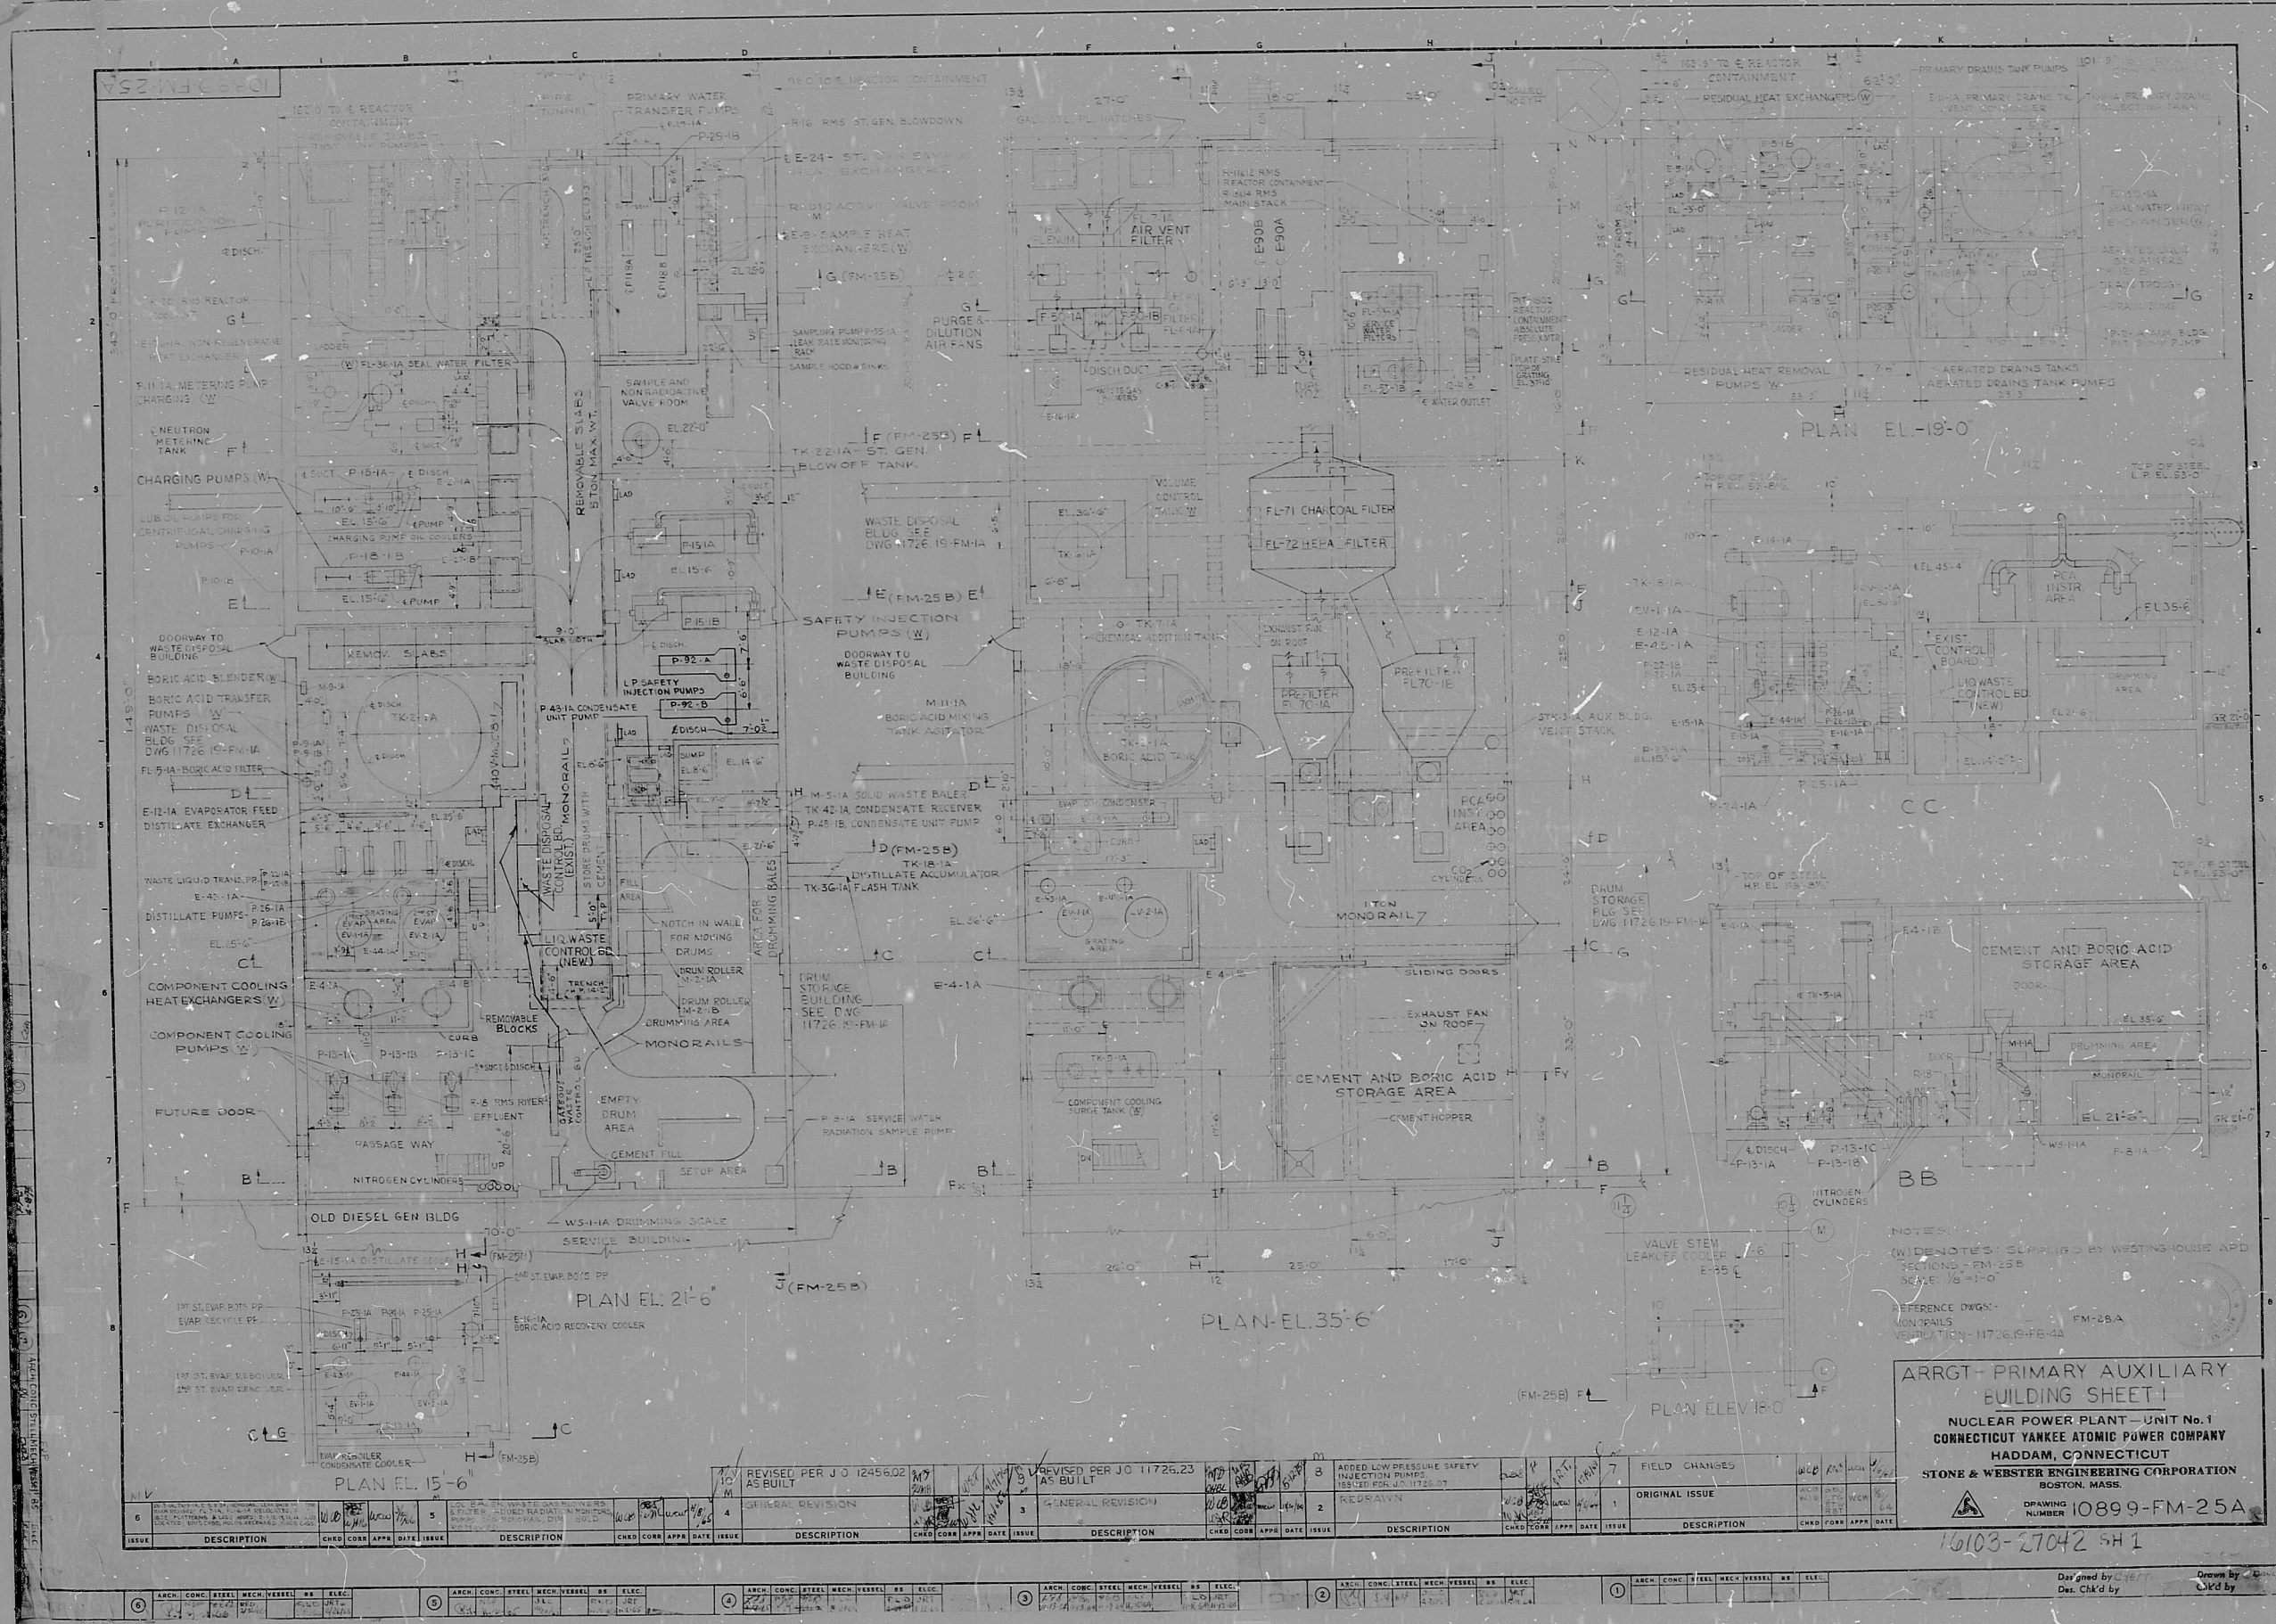