


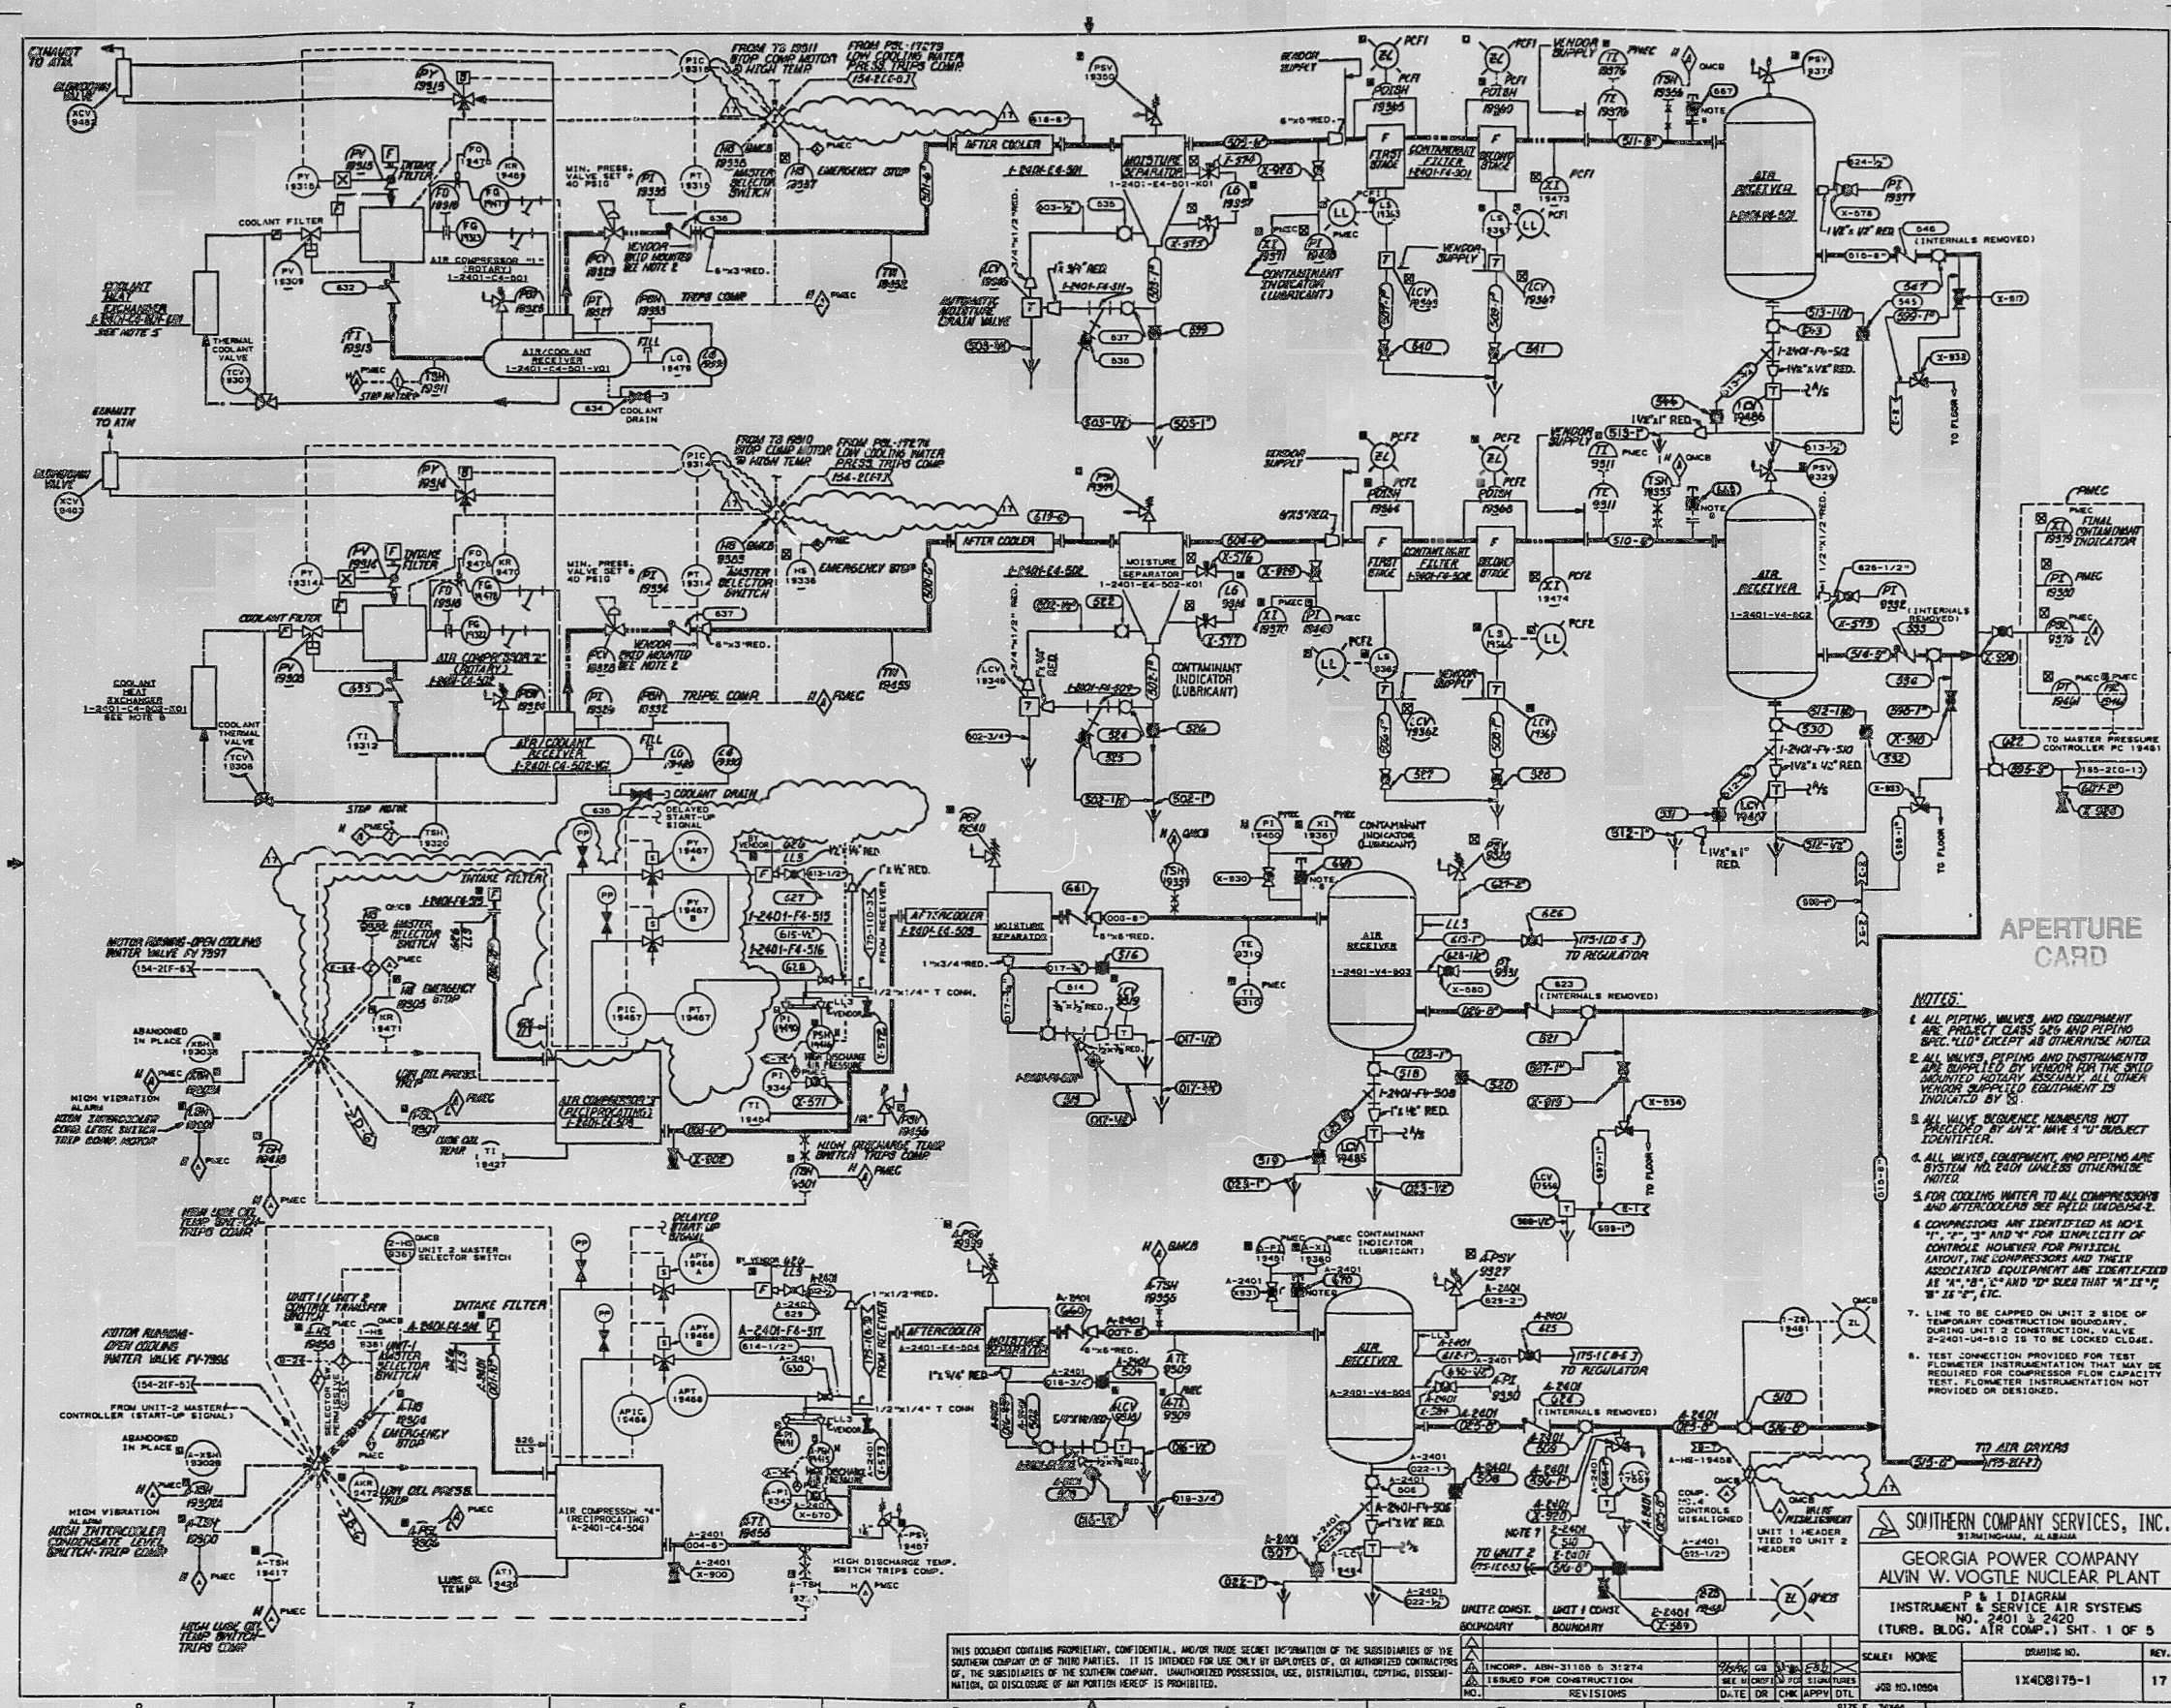

- NOTES:**
1. ALL PIPING, VALVES, AND EQUIPMENT ARE PROJECT CLASS 200 AND PIPING SPEC. 100 EXCEPT AS OTHERWISE NOTED.
 2. ALL VALVES, PIPING AND INSTRUMENTS ARE SUPPLIED BY VENDOR FOR THE SAID INSTALLED ROTARY ASSEMBLY. ALL OTHER VENDOR SUPPLIED EQUIPMENT IS INDICATED BY S.
 3. ALL VALVE, EQUIPMENT, AND PIPING ARE SYSTEM NO. 200 UNLESS OTHERWISE NOTED.
 4. ALL VALVES, EQUIPMENT, AND PIPING ARE SYSTEM NO. 200 UNLESS OTHERWISE NOTED.
 5. FOR COOLING WATER TO ALL COMPRESSORS AND AFTERCOOLERS SEE P&ID UNDESIGNED.
 6. COMPRESSORS ARE IDENTIFIED AS NO. 1, 2, 3, 999, 1000.

SOUTHERN COMPANY SERVICES, INC.
GEORGIA POWER COMPANY
ALVIN W. VOGTLE NUCLEAR PLANT
P & I DIAGRAM
INSTRUMENT & SERVICE AIR SYSTEMS
(TURB. BLDG. AIR COMP. 1) SHT. 1 OF 5
SCALE: NONE
DRAWING NO. 1X408175-1
REV. 17

THIS DOCUMENT CONTAINS PROPRIETARY, CONFIDENTIAL, AND/OR TRADE SECRET INFORMATION OF THE SOUTHERN COMPANY OR OF THIRD PARTIES. IT IS INTENDED FOR USE ONLY BY EMPLOYEES OF, OR AUTHORIZED CONTRACTORS OF, THE SOUTHERN COMPANY. UNAUTHORIZED POSSESSION, USE, DISTRIBUTION, COPYING, DISSEMINATION, OR DISCLOSURE OF ANY PORTION HEREOF IS PROHIBITED.

9910190215

9910190215

