


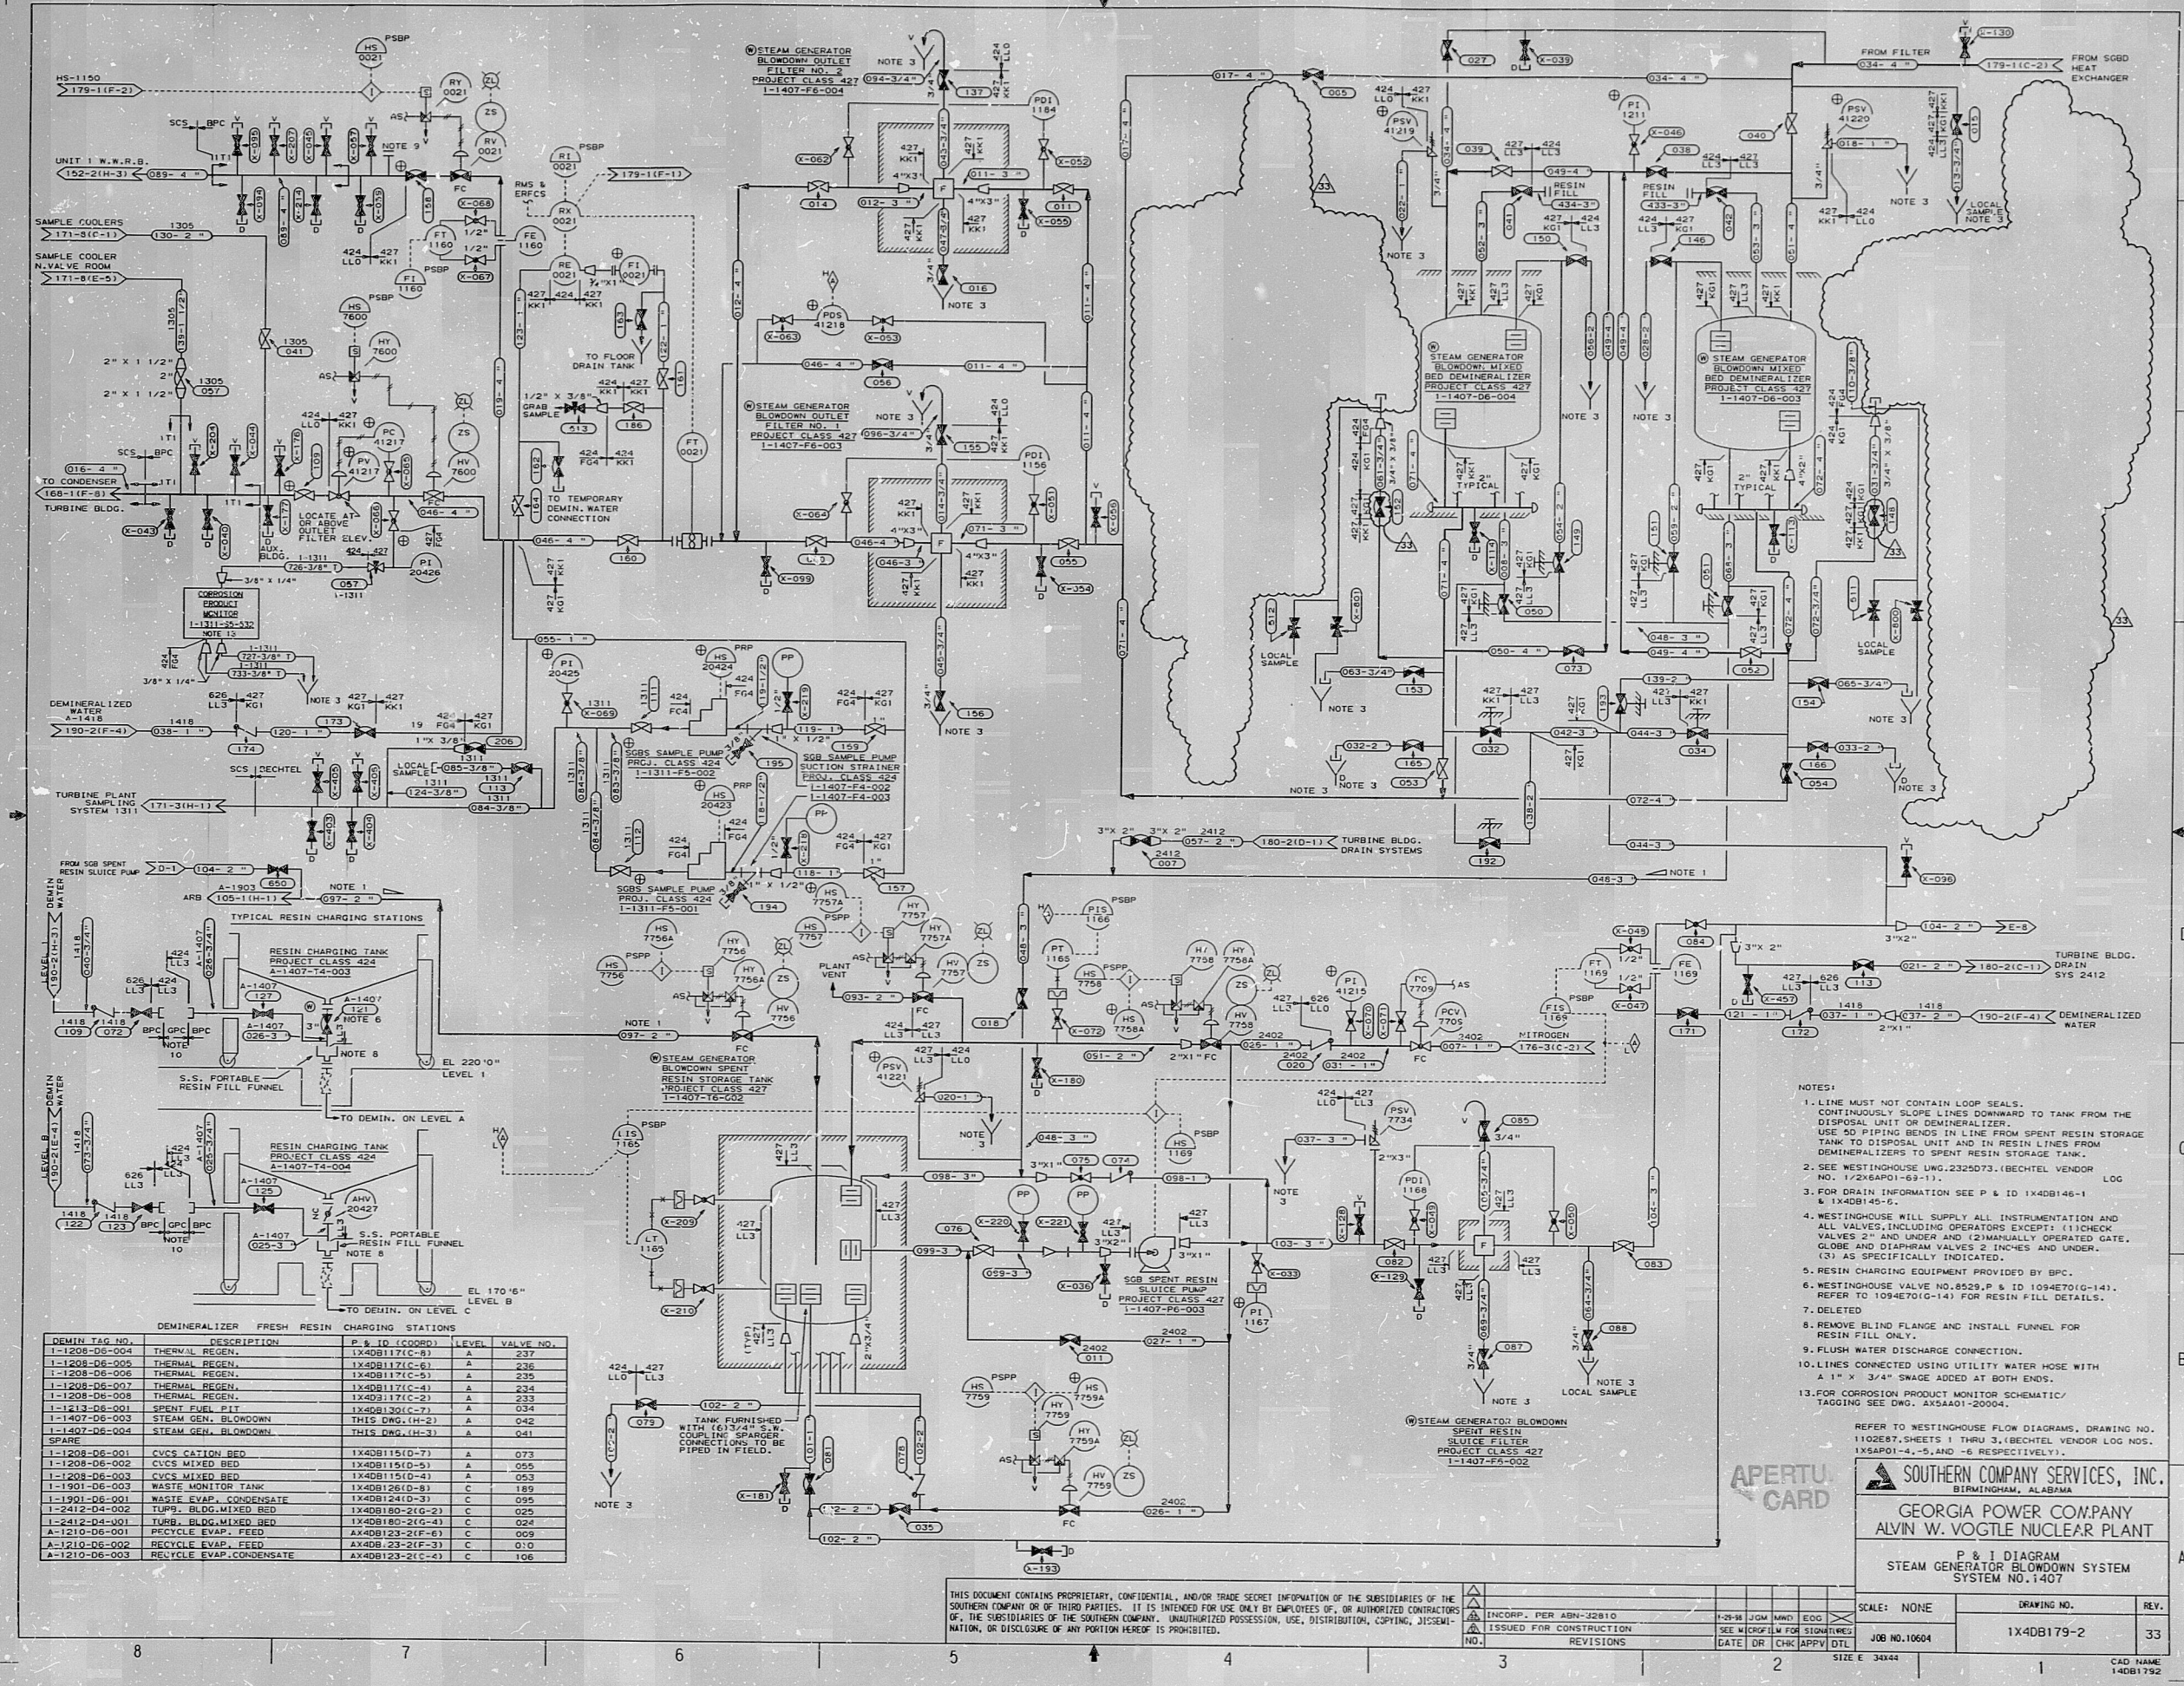

DEMIN. TAG NO.	DESCRIPTION	P. & ID. (COORD.)	LEVEL	VALVE NO.
I-1208-D6-004	THERMAL REGEN.	IX40B117(C-6)	A	236
I-1208-D6-005	THERMAL REGEN.	IX40B117(C-6)	A	236
I-1208-D6-006	THERMAL REGEN.	IX40B117(C-6)	A	236
I-1208-D6-100	THERMAL REGEN.	IX40B117(C-6)	A	236

- NOTES:
1. LINE MUST NOT CONTAIN LOOP SEALS. CONTINUOUSLY SLOPE LINES DOWNWARD TO TANK FROM THE DISPOSAL UNIT OR DEMINERALIZER. USE 90° PIPING BENDS IN LINE FROM SPENT RESIN STORAGE TANK TO DISPOSAL UNIT AND IN RESIN LINES FROM DEMINERALIZERS TO SPENT RESIN STORAGE TANK.
 2. SEE WESTINGHOUSE LOG 2325073 (BECHTEL VENDOR LOG NO. 1/2X6A01-69-11).
 3. FOR DRAIN INFORMATION SEE P & ID 1X40B146-1 & 1X40B146-2.
 4. WESTINGHOUSE WILL SUPPLY ALL INSTRUMENTATION AND ALL VALVES, INCLUDING OPERATORS EXCEPT: (1) CHECK VALVES 2" AND UNDER AND (2) MANUALLY OPERATED GATE, GLOBE AND DIAPHRAM VALVES 2" INCHES AND UNDER. (3) AS SPECIFICALLY INDICATED.
 5. RESIN CHARGING EQUIPMENT PROVIDED BY BPC.
 6. WESTINGHOUSE VALVE NO. 0528 P & ID 1094701G-141. REFER TO 1094701G-141 FOR RESIN FILL DETAILS.
 7. DELETED.
 8. REMOVE BLIND FLANGE AND INSTALL FUNNEL FOR RESIN FILL ONLY.
 9. FLUSH WATER DISCHARGE CONNECTION.
 10. LINES CONNECTED USING UTILITY WATER HOSE WITH A 1" X 3/4" SWAGE ADDED AT BOTH ENDS.
 13. FOR CORROSION PRODUCT MONITOR SCHEMATIC/TAGGING SEE DWG. A154401-20004.

REFER TO WESTINGHOUSE FLOW DIAGRAMS, DRAWING NO. 110857-23, SHEETS 1 THRU 3, (BECHTEL VENDOR LOG NOS. 1X6A01-4, -5, AND -6 RESPECTIVELY).

SOUTHERN COMPANY SERVICES, INC.
BIRMINGHAM, ALABAMA

GEORGIA POWER COMPANY
ALVIN W. VOGTLE NUCLEAR PLANT

P & ID DIAGRAM
STEAM GENERATOR BLOWDOWN SYSTEM NO. 1407

SCALE: NONE	DRAWING NO.	REV.
	1X40B179-2	33
JOB NO. 10604		
DATE DR. CHK. APPV.		
SIZE E 34x44		
CAD NAME: 140B1792		

9910190224

PDR RIDS

9910190224

