


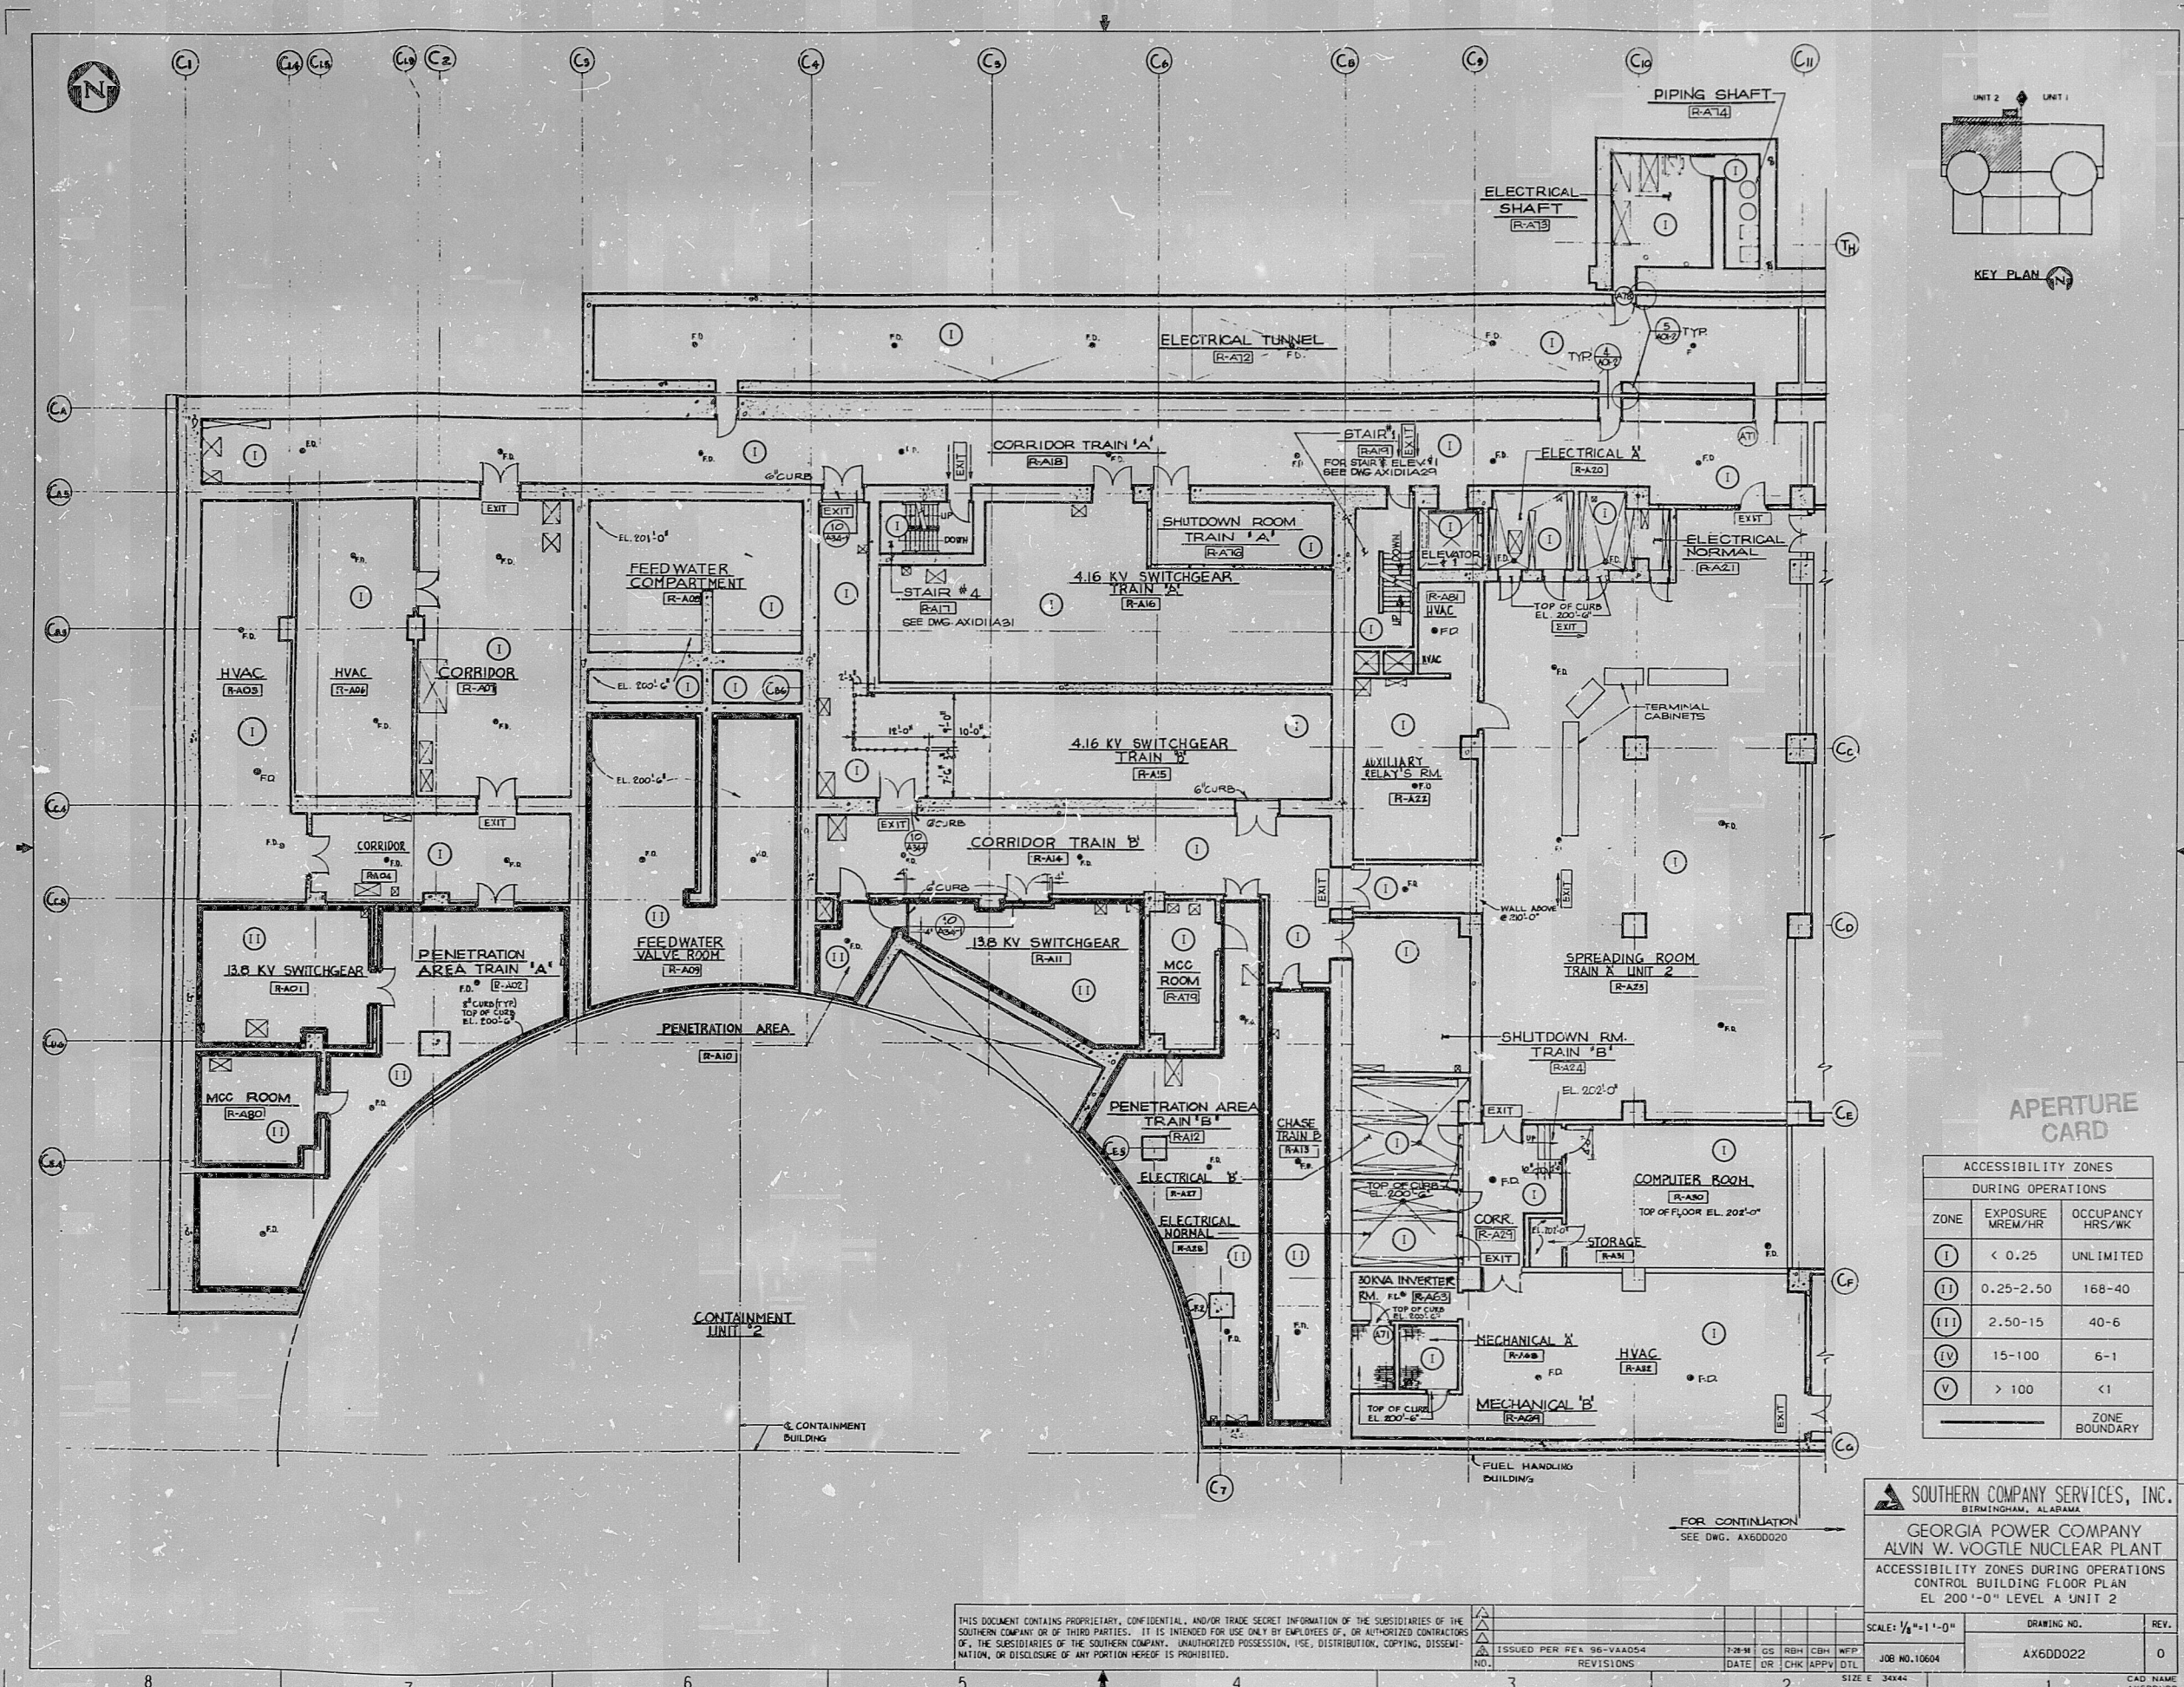

THIS DOCUMENT CONTAINS PROPRIETARY, CONFIDENTIAL, AND/OR TRADE SECRET INFORMATION OF THE SUBSIDIARIES OF THE SOUTHERN COMPANY OR OF THIRD PARTIES. IT IS INTENDED FOR USE ONLY BY EMPLOYEES OF, OR AUTHORIZED CONTRACTORS OF, THE SUBSIDIARIES OF THE SOUTHERN COMPANY. UNAUTHORIZED POSSESSION, USE, DISTRIBUTION, COPYING, DISSEMINATION, OR DISCLOSURE OF ANY PORTION HEREOF IS PROHIBITED.

	ISSUED PER FE# 96-VAA054	7-28-96	GS	RBH	CBH	WFP			
NO.	REVISIONS	DATE	CR	CHK	APPV	DTL			
3	1				2				

SOUTHERN COMPANY SERVICES, INC.
BIRMINGHAM, ALABAMA

GEORGIA POWER COMPANY
ALVIN W. VOGTLE NUCLEAR PLANT
ACCESSIBILITY ZONES DURING OPERATIONS
CONTROL BUILDING FLOOR PLAN
EL. 200'-0" LEVEL A UNIT 2

SCALE: 1/8"=1'-0"

DRAWING NO.	REV.
AX600022	0

JOB NO. 10604

CAD NAME: AX600022

9910190246

PDR RIDS

9910190246

