




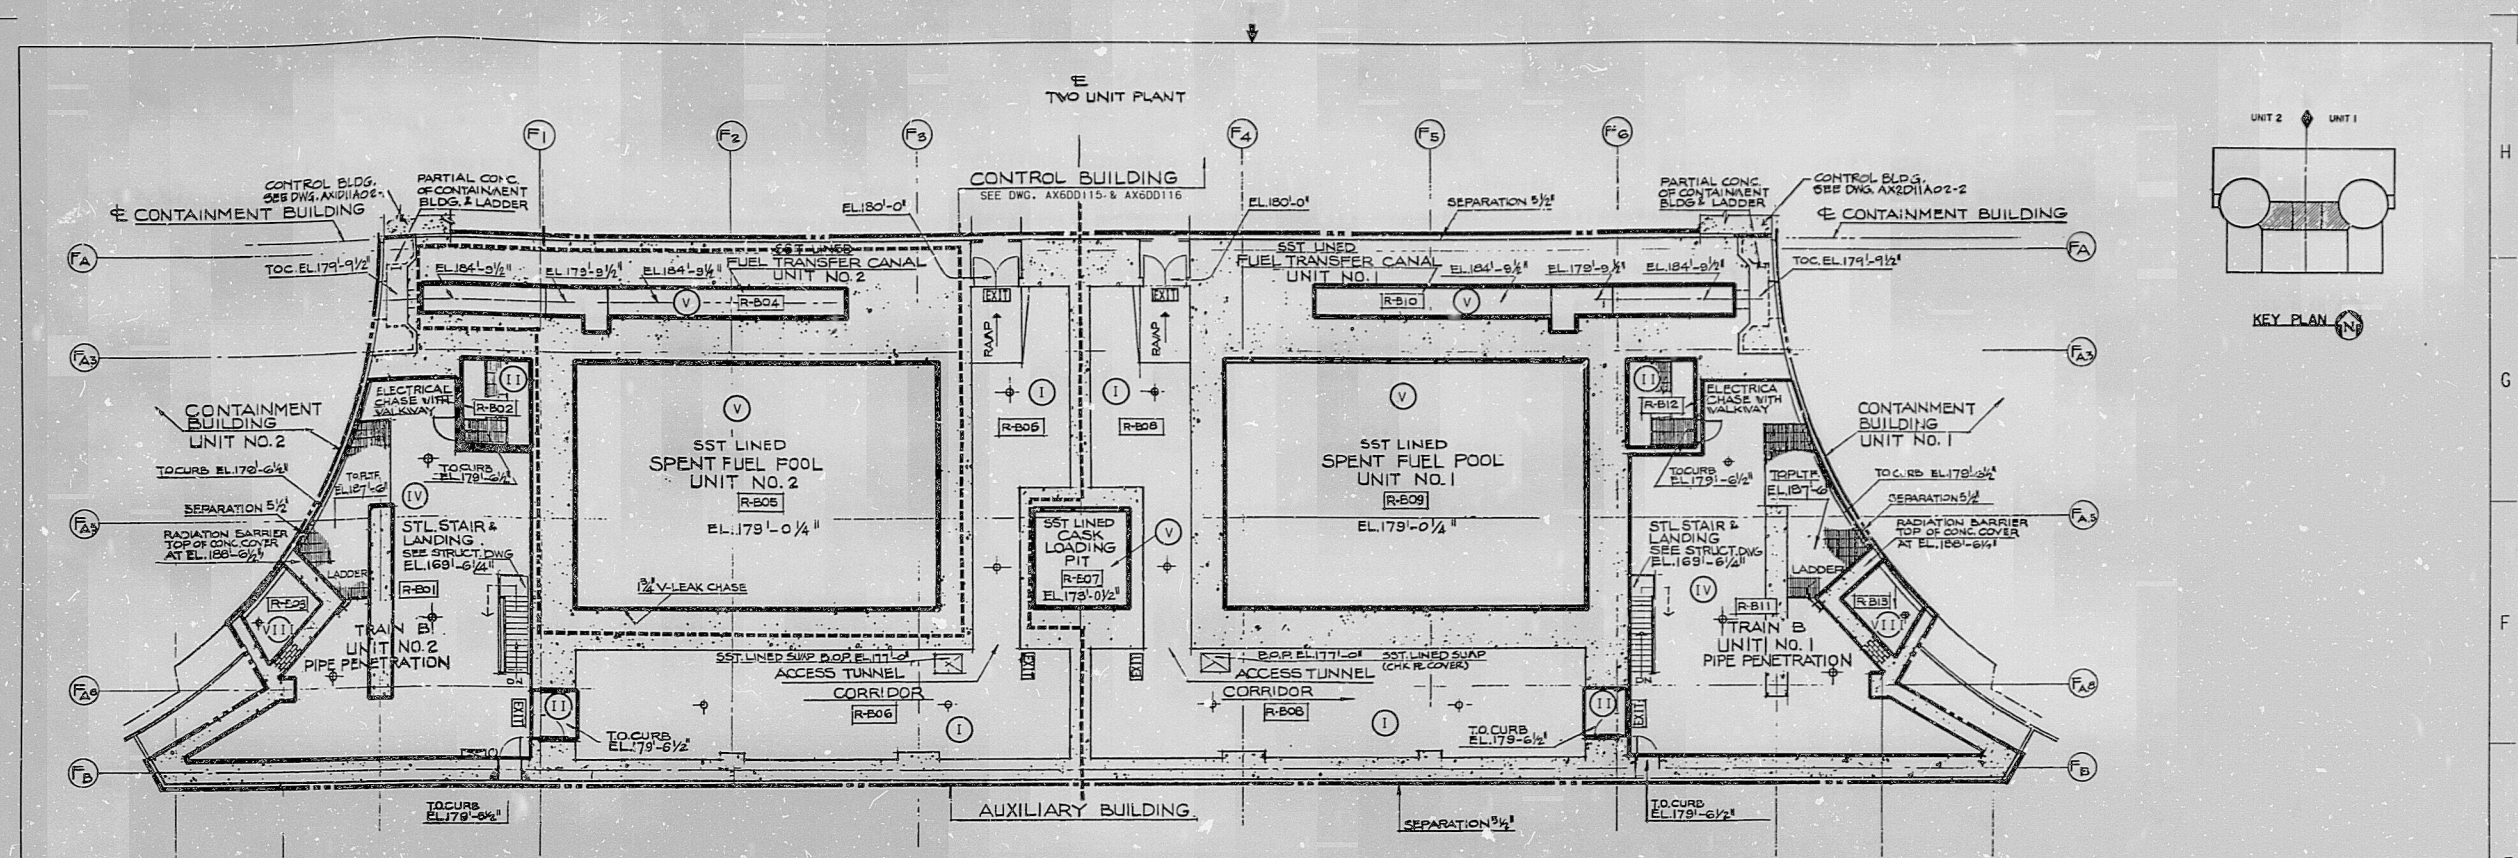

LEVEL B
FLOOR PLAN EL.179'-0 1/2"

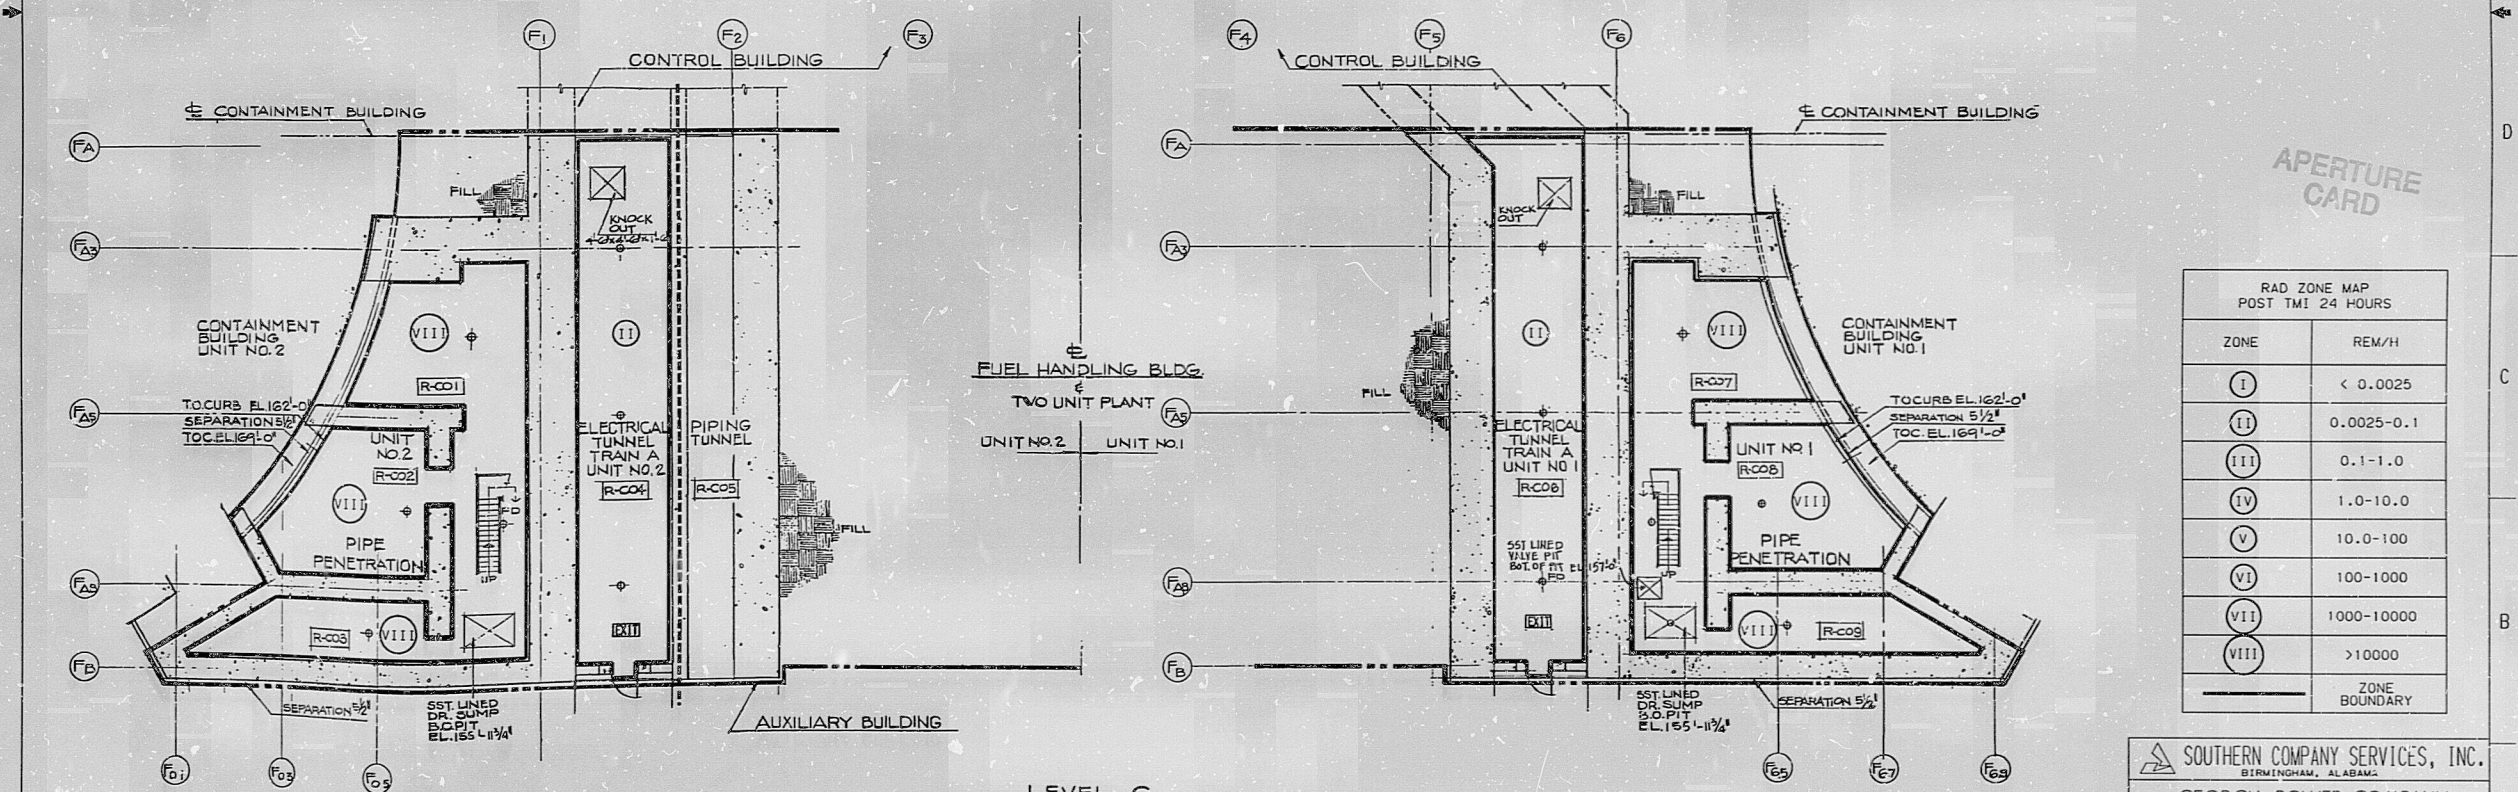

LEVEL C
FLOOR PLAN EL.160'-0"

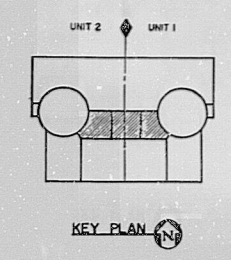

APERTURE
CARD

RAD ZONE MAP POST TMI 24 HOURS	
ZONE	REM/H
(I)	< 0.0025
(II)	0.0025-0.1
(III)	0.1-1.0
(IV)	1.0-10.0
(V)	10.0-100
(VI)	100-1000
(VII)	1000-10000
(VIII)	>10000
	ZONE BOUNDARY

SOUTHERN COMPANY SERVICES, INC.
BIRMINGHAM, ALABAMA

GEORGIA POWER COMPANY
ALVIN W. VOGTLE NUCLEAR PLANT

RAD ZONE MAP POST TMI 24 HOURS
FUEL HANDLING BUILDING FLOOR PLAN
EL. 160'-0", AND
EL. 179'-0 1/2", LEVELS C AND B

SCALE: NONE

DRAWING NO. AX600111

REV. 0

ISSUED PER REA 96-VAAC04

7-28-94 JLM RSH CBH WFP

DATE DR CHK APPV DTL

JOB NO. 10604

SIZE E 34x44

CAD NAME AX600111

THIS DOCUMENT CONTAINS PROPRIETARY, CONFIDENTIAL, AND/OR TRADE SECRET INFORMATION OF THE SUBSIDIARIES OF THE SOUTHERN COMPANY OR OF THIRD PARTIES. IT IS INTENDED FOR USE ONLY BY EMPLOYEES OF, OR AUTHORIZED CONTRACTORS OF, THE SUBSIDIARIES OF THE SOUTHERN COMPANY. UNAUTHORIZED POSSESSION, USE, DISTRIBUTION, COPYING, DISSEMINATION, OR DISCLOSURE OF ANY PORTION HEREOF IS PROHIBITED.

PDR RDS

9910190278

[REDACTED]

9910190278

[REDACTED]

