
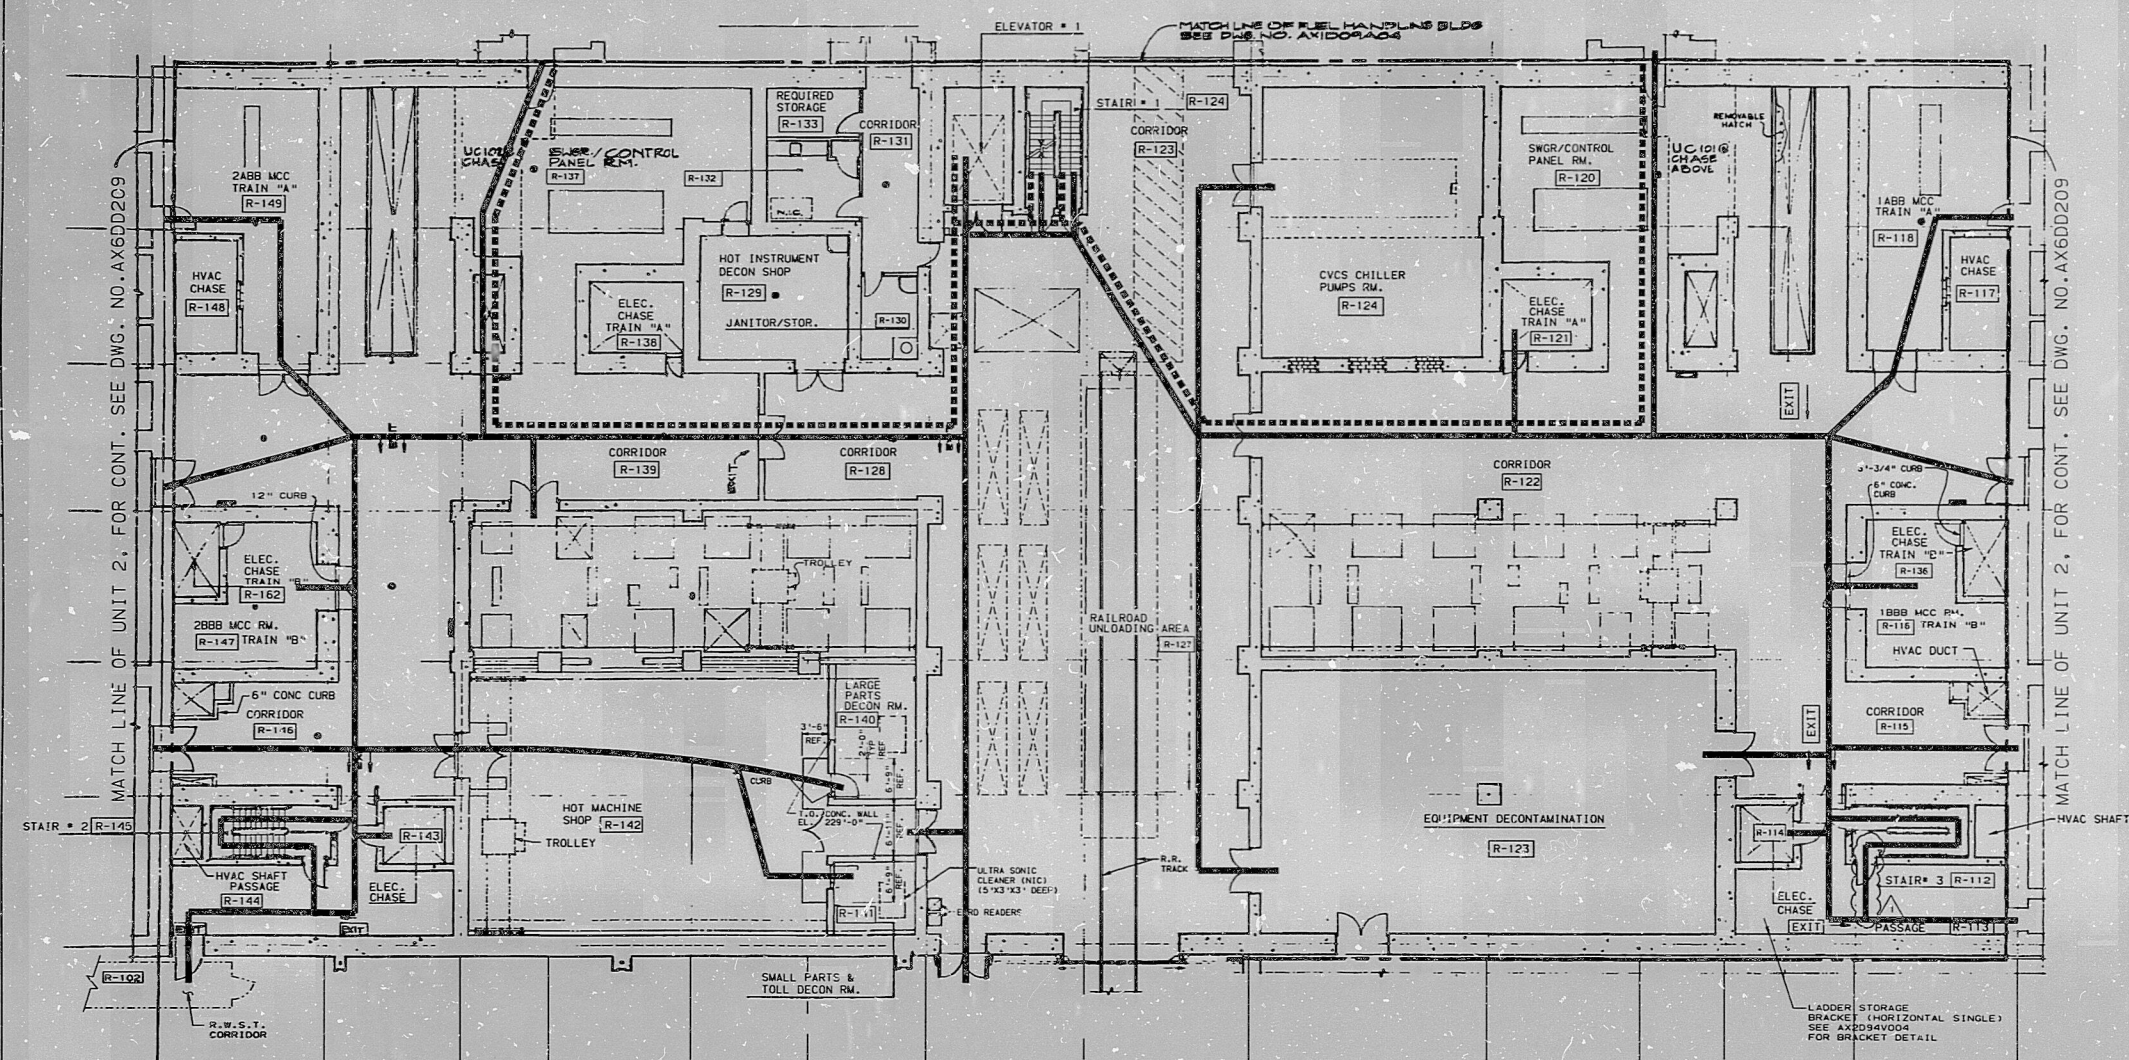


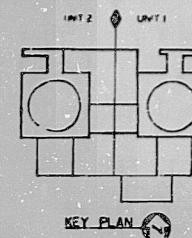

APERTURE CARD

- LEGEND:
- PLANT EQUIPMENT OPERATIONS (MAINTENANCE AND LABOR)
 - REFUELING
 - MAIN CONTROL ROOM OPERATIONS
 - AREA RADIATION MONITORS
 - AIRBORNE RADIATION MONITORS
 - PROCESS RADIATION MONITORS

SOUTHERN COMPANY SERVICES, INC.
BIRMINGHAM, ALABAMA

GEORGIA POWER COMPANY
ALVIN W. VOGTLE NUCLEAR PLANT

PERSONNEL FLOW
AUXILIARY BUILDING
FLOOR PLAN EL. 220'-0"
LEVEL 1

THIS DOCUMENT CONTAINS PROPRIETARY, CONFIDENTIAL, AND/OR TRADE SECRET INFORMATION OF THE SUBSIDIARIES OF THE SOUTHERN COMPANY OR OF THIRD PARTIES. IT IS INTENDED FOR USE ONLY BY EMPLOYEES OF, OR AUTHORIZED CONTRACTORS OF, THE SUBSIDIARIES OF THE SOUTHERN COMPANY. UNAUTHORIZED POSSESSION, USE, DISTRIBUTION, COPYING, DISSEMINATION, OR DISCLOSURE OF ANY PORTION HEREOF IS PROHIBITED.

REVISIONS

NO.	DESCRIPTION	DATE	BY	CHK	APPV	DTL
1	ISSUED PER REA 96-VAX054					
2	REVISED PER REA 96-VAX054					

SCALE: NONE

DRAWING NO. AX6DD208

REV. 1

CAD NAME AX6DD208

PDR RUS 9910190303

9910190303

