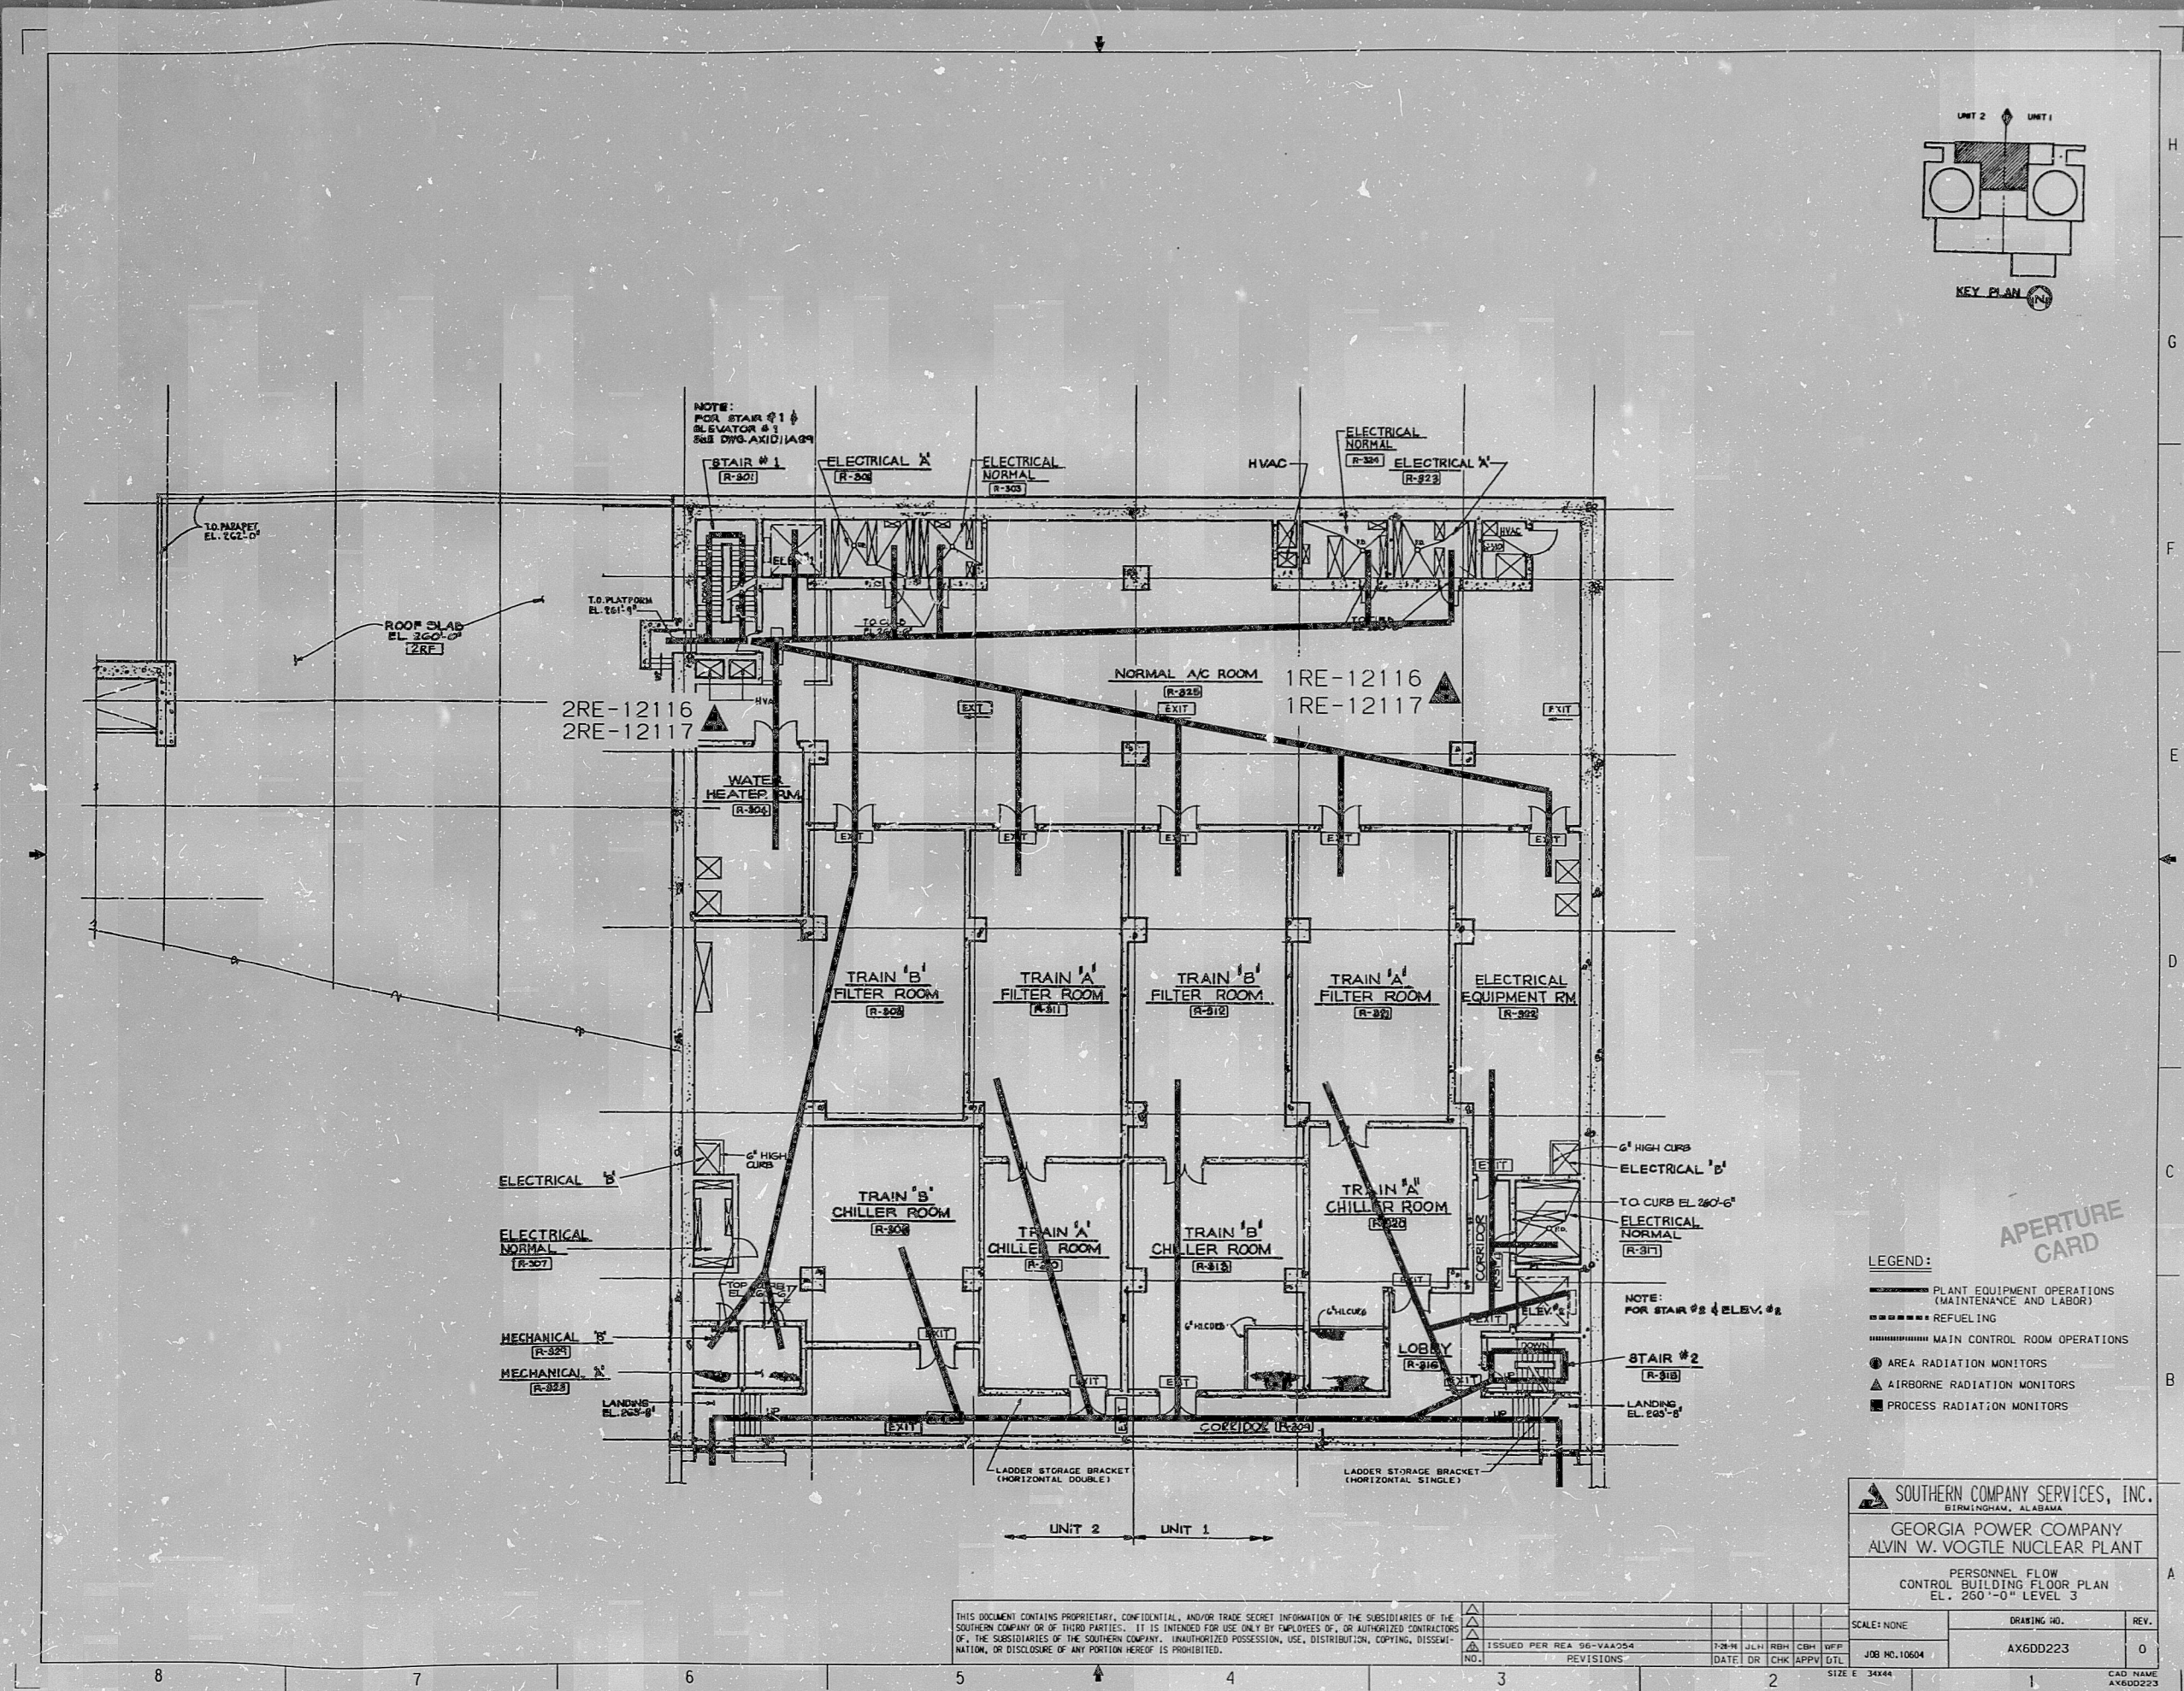


- LEGEND:
- PLANT EQUIPMENT OPERATIONS (MAINTENANCE AND LABOR)
 - REFUELING
 - MAIN CONTROL ROOM OPERATIONS
 - AREA RADIATION MONITORS
 - AIRBORNE RADIATION MONITORS
 - PROCESS RADIATION MONITORS

SOUTHERN COMPANY SERVICES, INC.
BERMINGHAM, ALABAMA

GEORGIA POWER COMPANY
ALVIN W. VOGTLE NUCLEAR PLANT

PERSONNEL FLOW
CONTROL BUILDING FLOOR PLAN
EL. 200'-0" LEVEL 3

SCALE: NONE

DRAWING NO. AX600223

REV. 0

CAD NAME AX600223

NO.	REVISIONS	DATE	DR	CHK	APPV	DTL
1	ISSUED PER REA 96-VAA054	7-24-96	JLH	RHB	CBH	DPF


PDR RIBS 9910200088

[REDACTED]

9910200088

|||
|
|

[REDACTED]

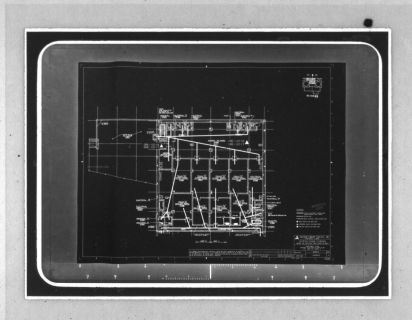

||

||