


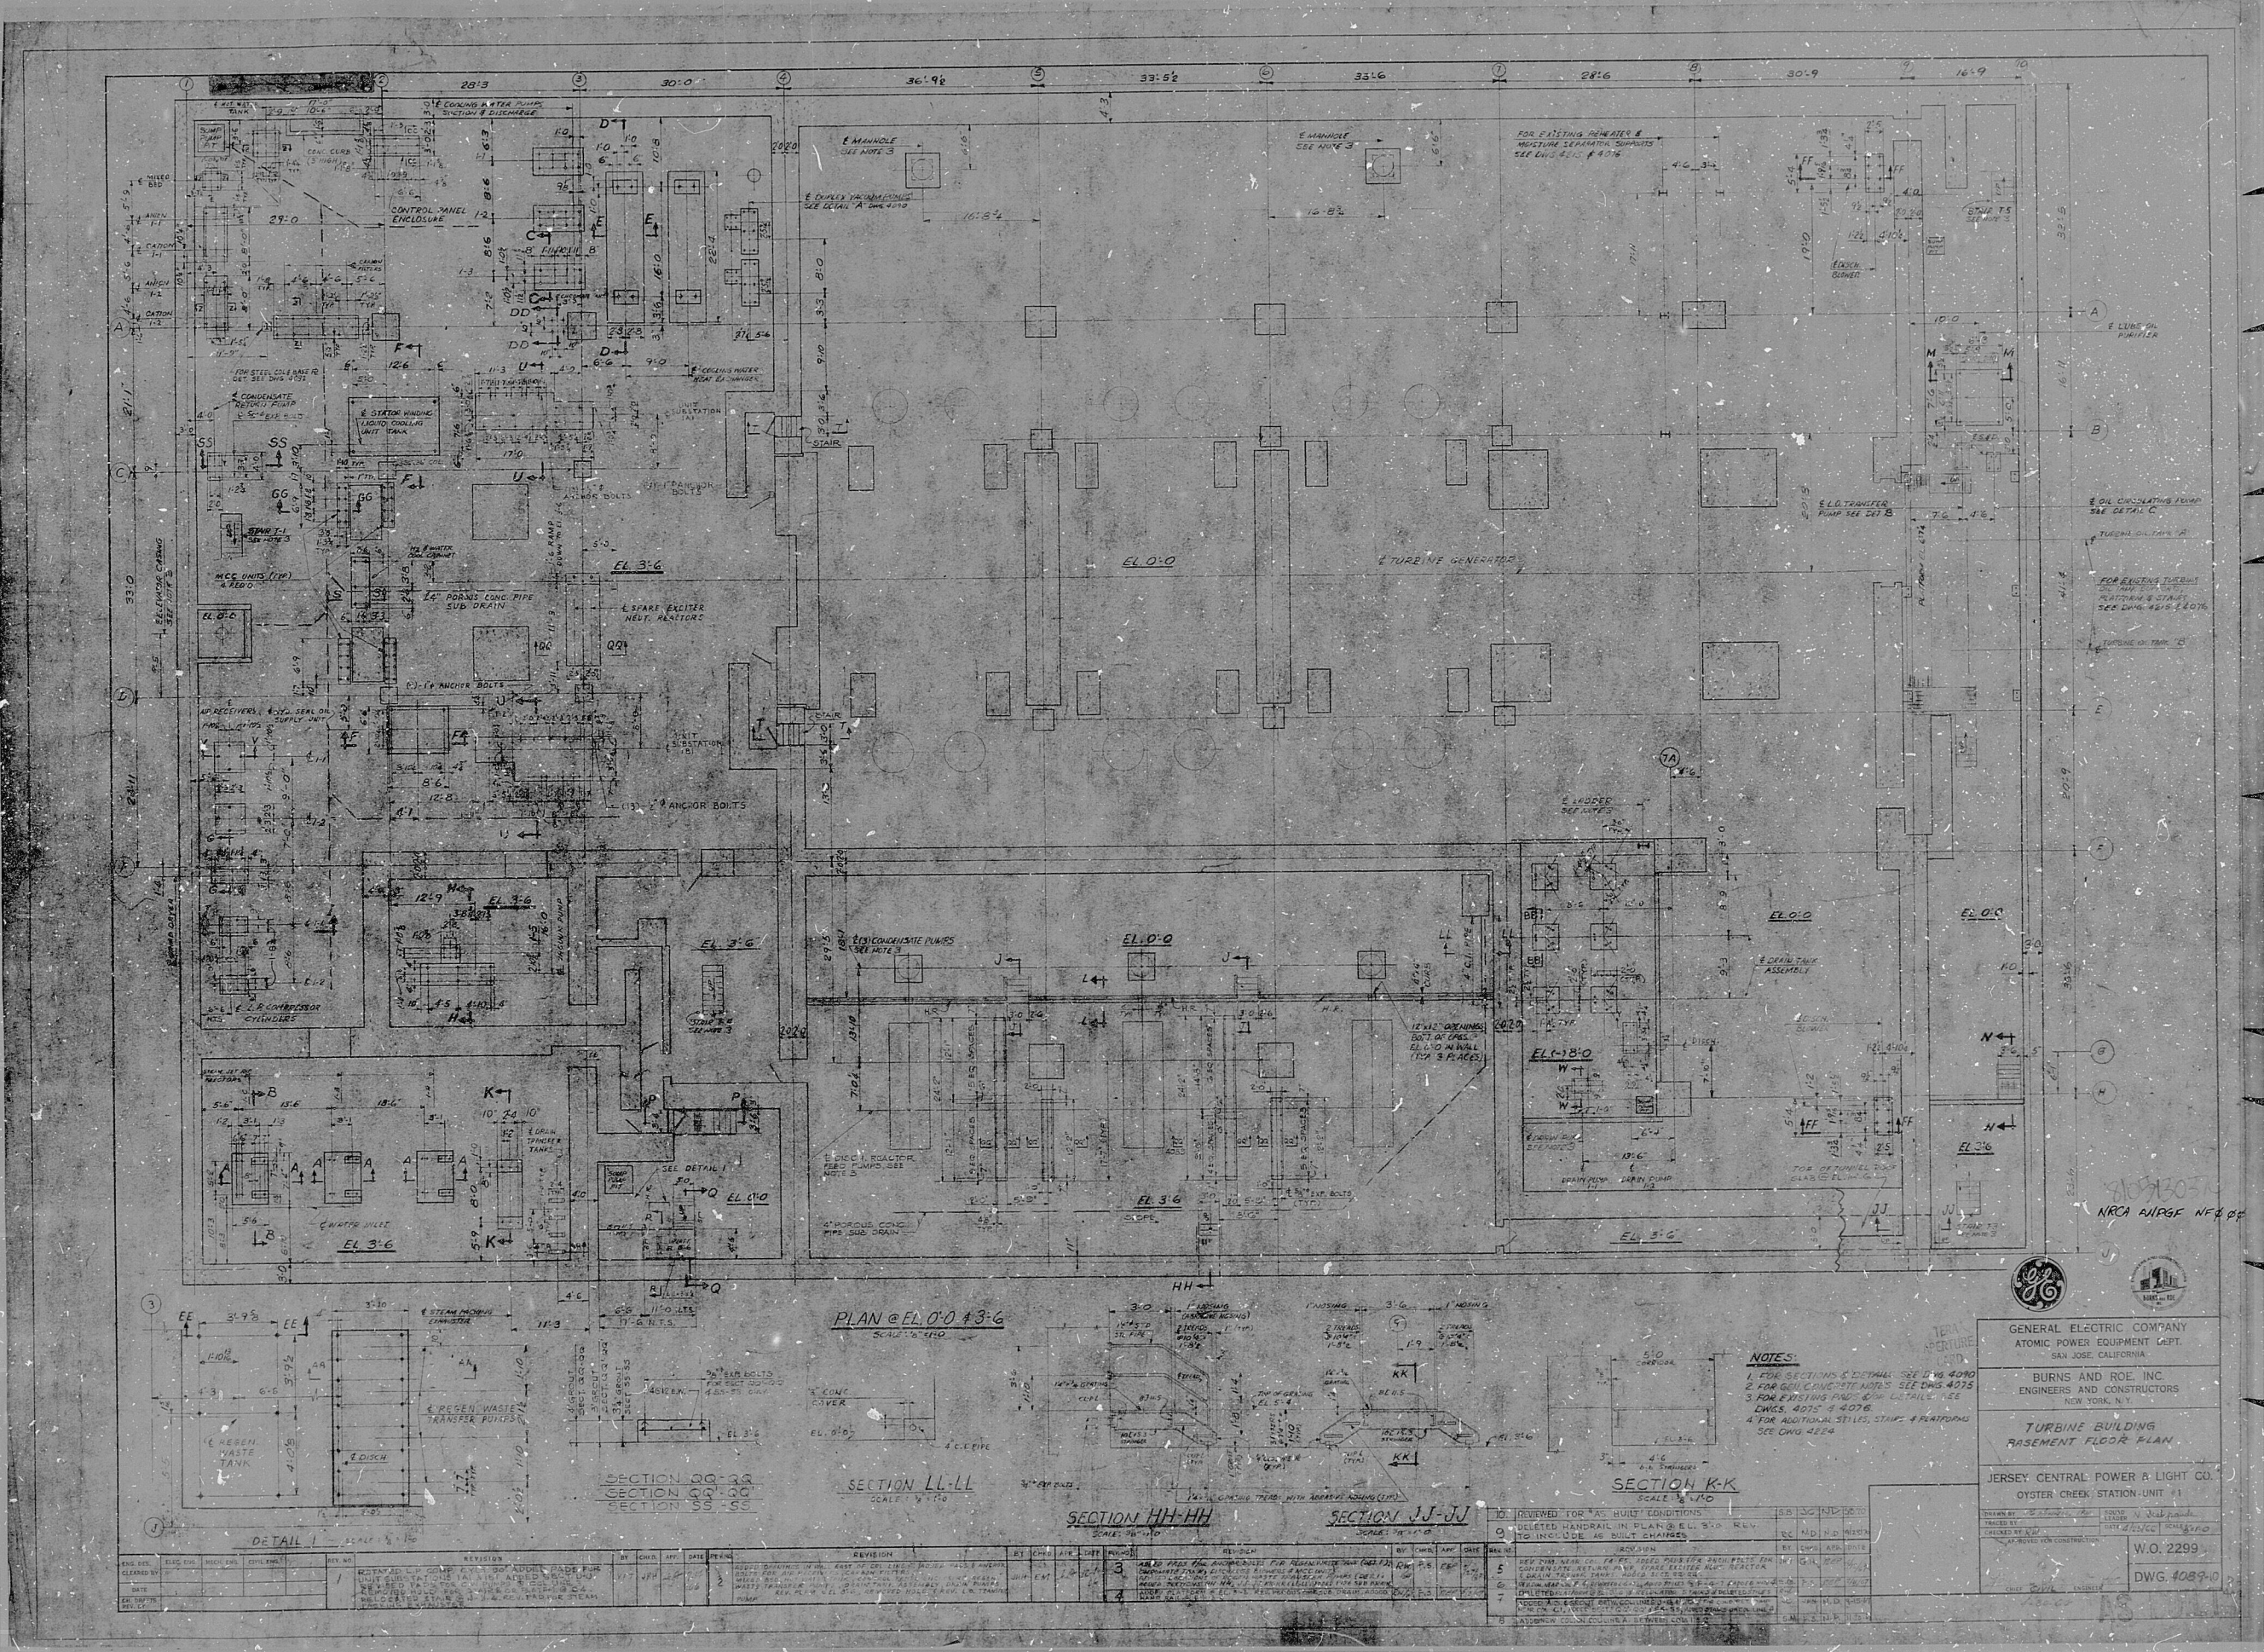

GENERAL ELECTRIC COMPANY
ATOMIC POWER EQUIPMENT DEPT.
SAN JOSE, CALIFORNIA
BURNS AND ROE, INC.
ENGINEERS AND CONSTRUCTORS
NEW YORK, N.Y.

TURBINE BUILDING
BASEMENT FLOOR PLAN

JERSEY CENTRAL POWER & LIGHT CO.
OYSTER CREEK STATION UNIT #1

W.O. 2299
DWG. 4089-0

NOTES:
1. FOR SECTIONS & DETAILS SEE DWG. 4080
2. FOR EXISTING FOUNDATION DETAILS SEE
DWG. 4075 & 4076
3. FOR EXISTING FOUNDATION DETAILS SEE
DWG. 4075 & 4076
4. FOR ADDITIONAL DETAILS, STAIRS & PLATFORMS
SEE DWG. 4074

SECTION K-K
SCALE 1/8" = 1'-0"

SECTION JJ-JJ
SCALE 1/8" = 1'-0"

SECTION HH-HH
SCALE 1/8" = 1'-0"

SECTION LL-LL
SCALE 1/8" = 1'-0"

SECTION QQ-QQ
SCALE 1/8" = 1'-0"

SECTION SS-SS
SCALE 1/8" = 1'-0"

REV.	DATE	BY	CHKD.	APP.	DESCRIPTION
1					ISSUED FOR CONSTRUCTION
2					REVISION
3					REVISION
4					REVISION

8105130370

DOCKET
NUMBER

ACCESSION
NUMBER

DRAWING NUMBER

SHEET REV.

