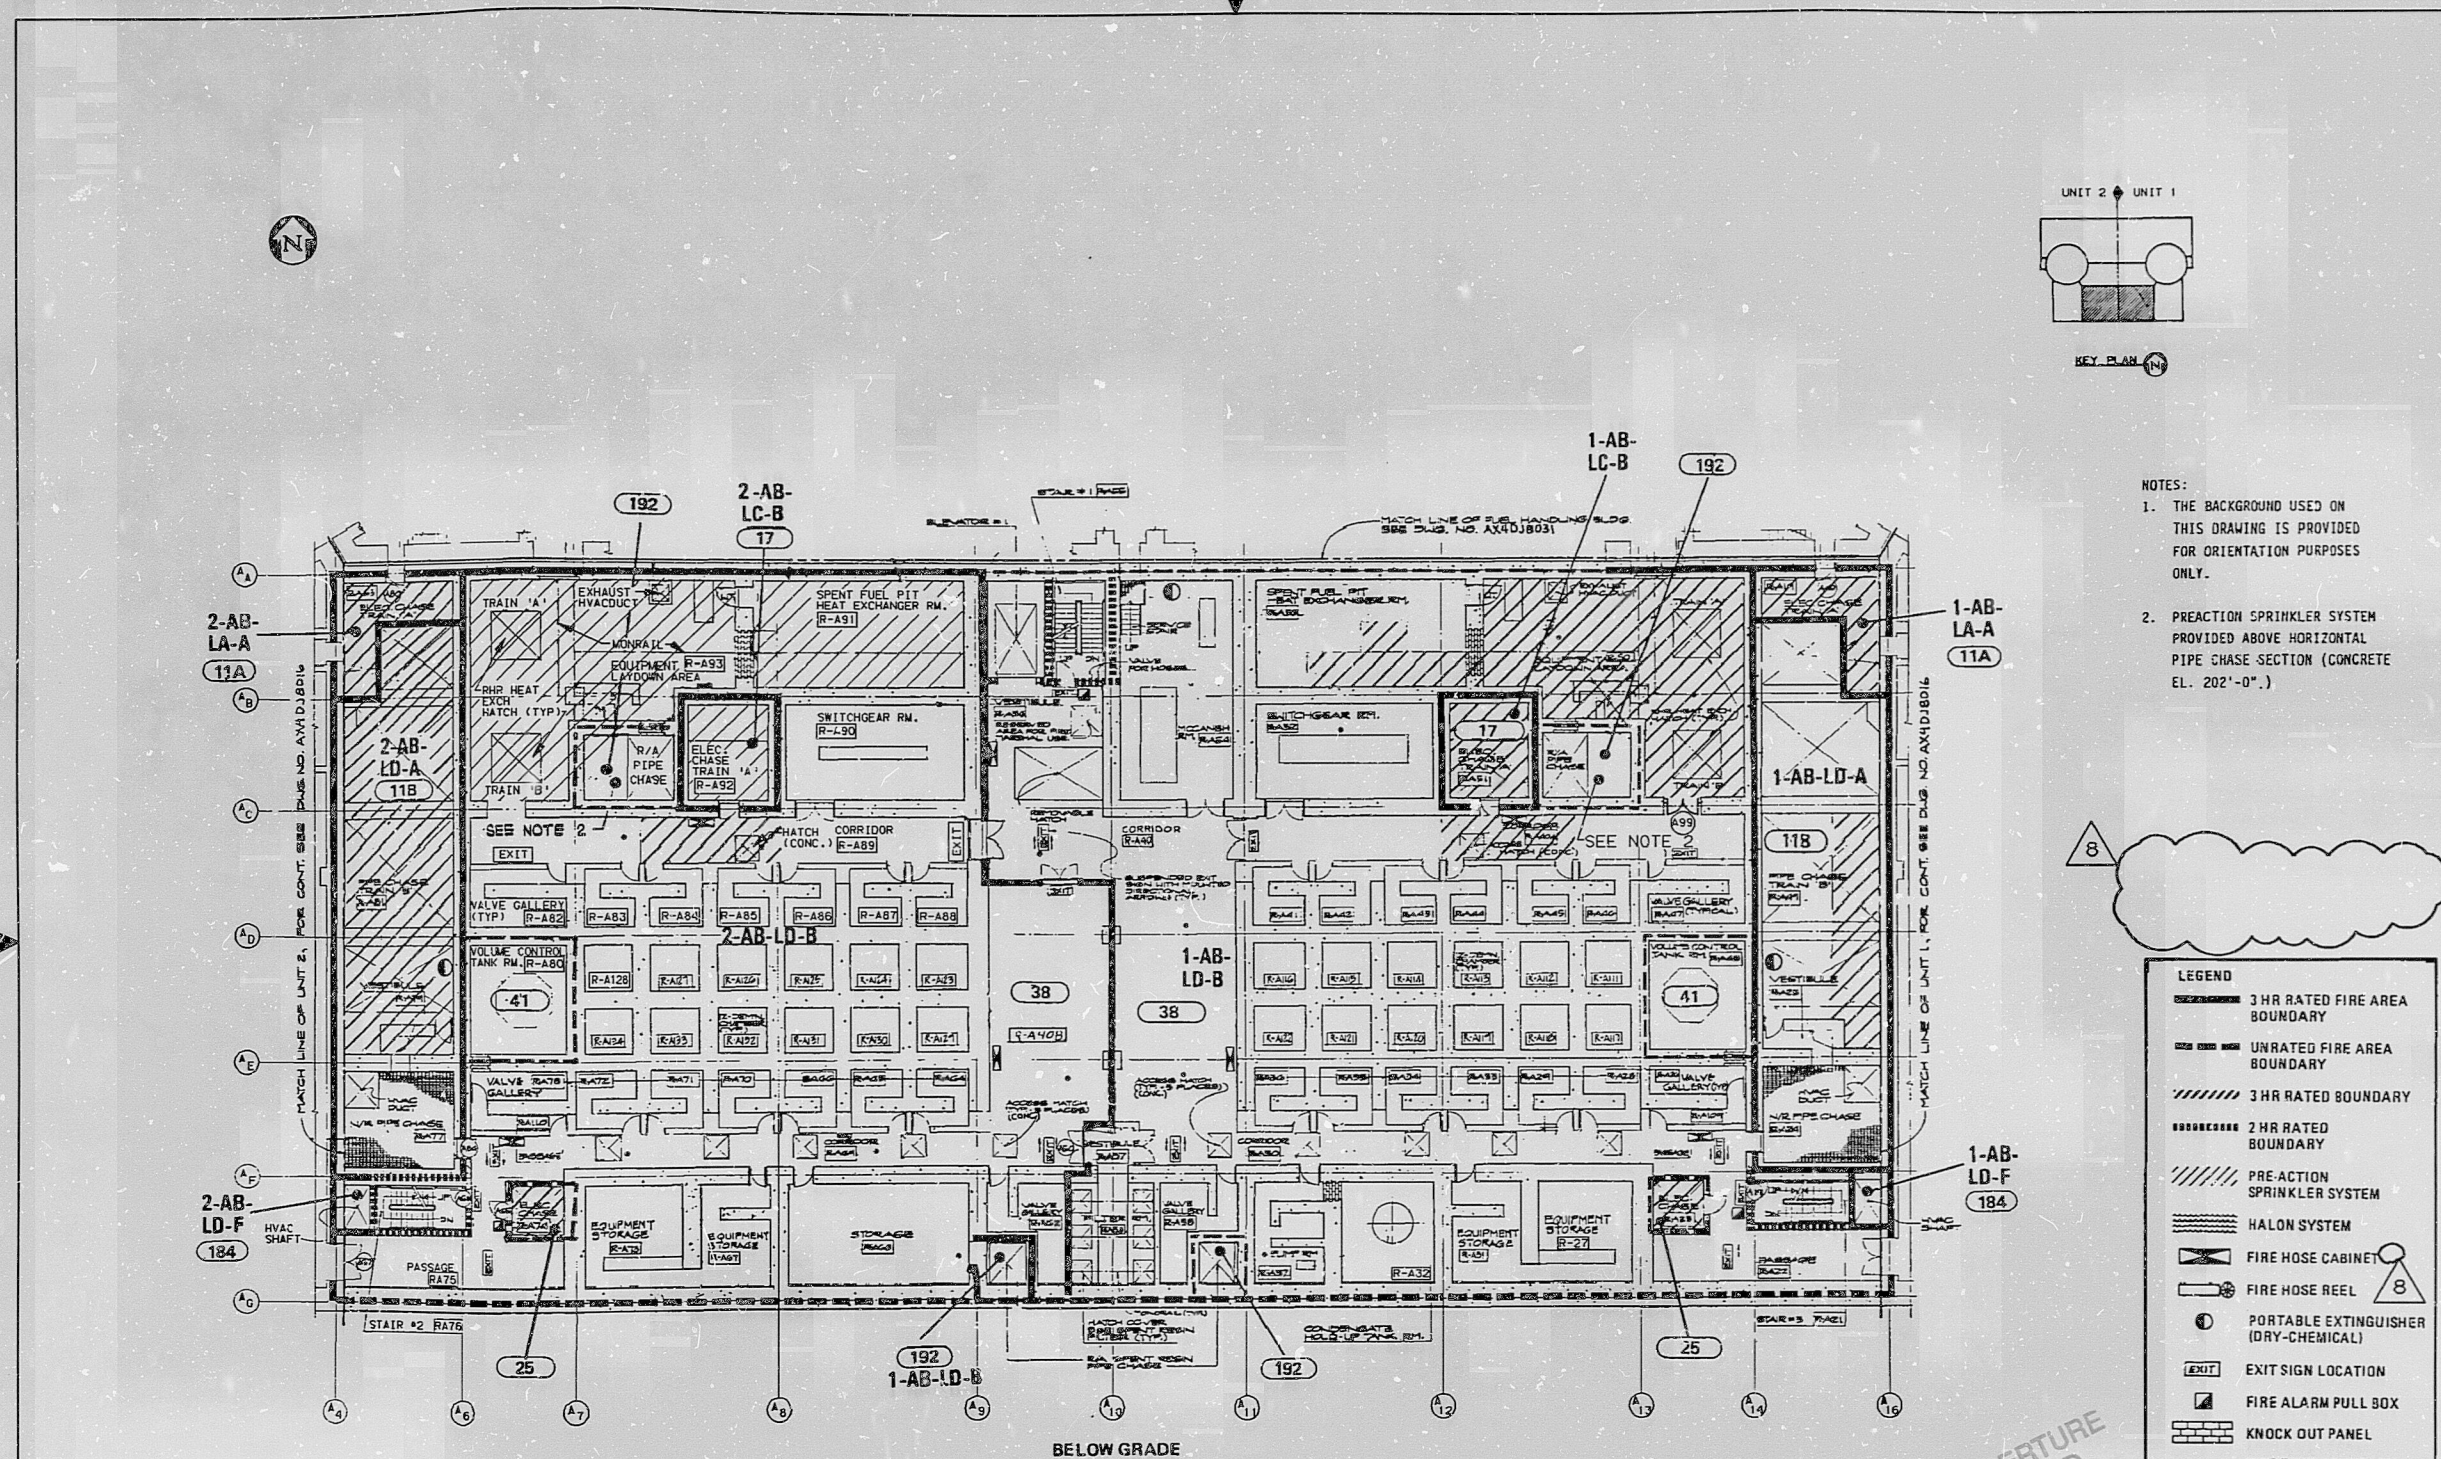


- NOTES:
1. THE BACKGROUND USED ON THIS DRAWING IS PROVIDED FOR ORIENTATION PURPOSES ONLY.
 2. PREACTION SPRINKLER SYSTEM PROVIDED ABOVE HORIZONTAL PIPE CHASE SECTION (CONCRETE EL. 202'-0").

LEGEND	
	3 HR RATED FIRE AREA BOUNDARY
	UNRATED FIRE AREA BOUNDARY
	3 HR RATED BOUNDARY
	2 HR RATED BOUNDARY
	PRE-ACTION SPRINKLER SYSTEM
	HALON SYSTEM
	FIRE HOSE CABINET
	FIRE HOSE REEL
	PORTABLE EXTINGUISHER (DRY-CHEMICAL)
	EXIT SIGN LOCATION
	FIRE ALARM PULL BOX
	KNOCK OUT PANEL
	FIRE ZONE BOUNDARY
	FIRE ZONE DESIGNATOR

ELECTRICAL CABLE LOCATION CROSS REFERENCE		
FIRE ZONE	UNIT 1 E4 CODE	UNIT 2 E4 CODE
11A	CE	FB
11B	CG	E1
17	CF	EN
25	BT	EE
38	CH	G1
41	CH	FC
184	AS	E9
192	CL	EZ

REVISIONS		DATE	DR	CHK	APPV	DTL
1	INCORP. PER ABN-32044	7-23-97	CD	EOG	MWD	
2	ISSUED FOR CONSTRUCTION					


SOUTHERN COMPANY SERVICES, INC. BIRMINGHAM, ALABAMA		
GEORGIA POWER COMPANY ALVIN W. VOGTLE NUCLEAR PLANT		
FIRE AREAS AUXILIARY BUILDING FLOOR PLAN EL. 195'-0" LEVEL A		
SCALE: NONE	DRAWING NO. AX4DJ8015	REV. 8

SIZE C 17x22 CAD NAME A4DJ8015

PDR RIDS

9910200292

9910200292

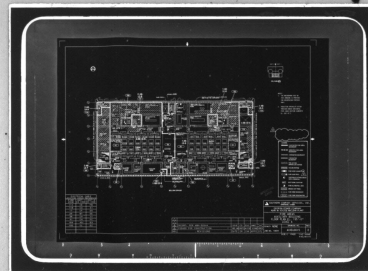

SENSITIVE DATA