


125222

AO-2301-28 AO-2301-29 AO-2301-30 AO-2301-31 SOV-2301-32

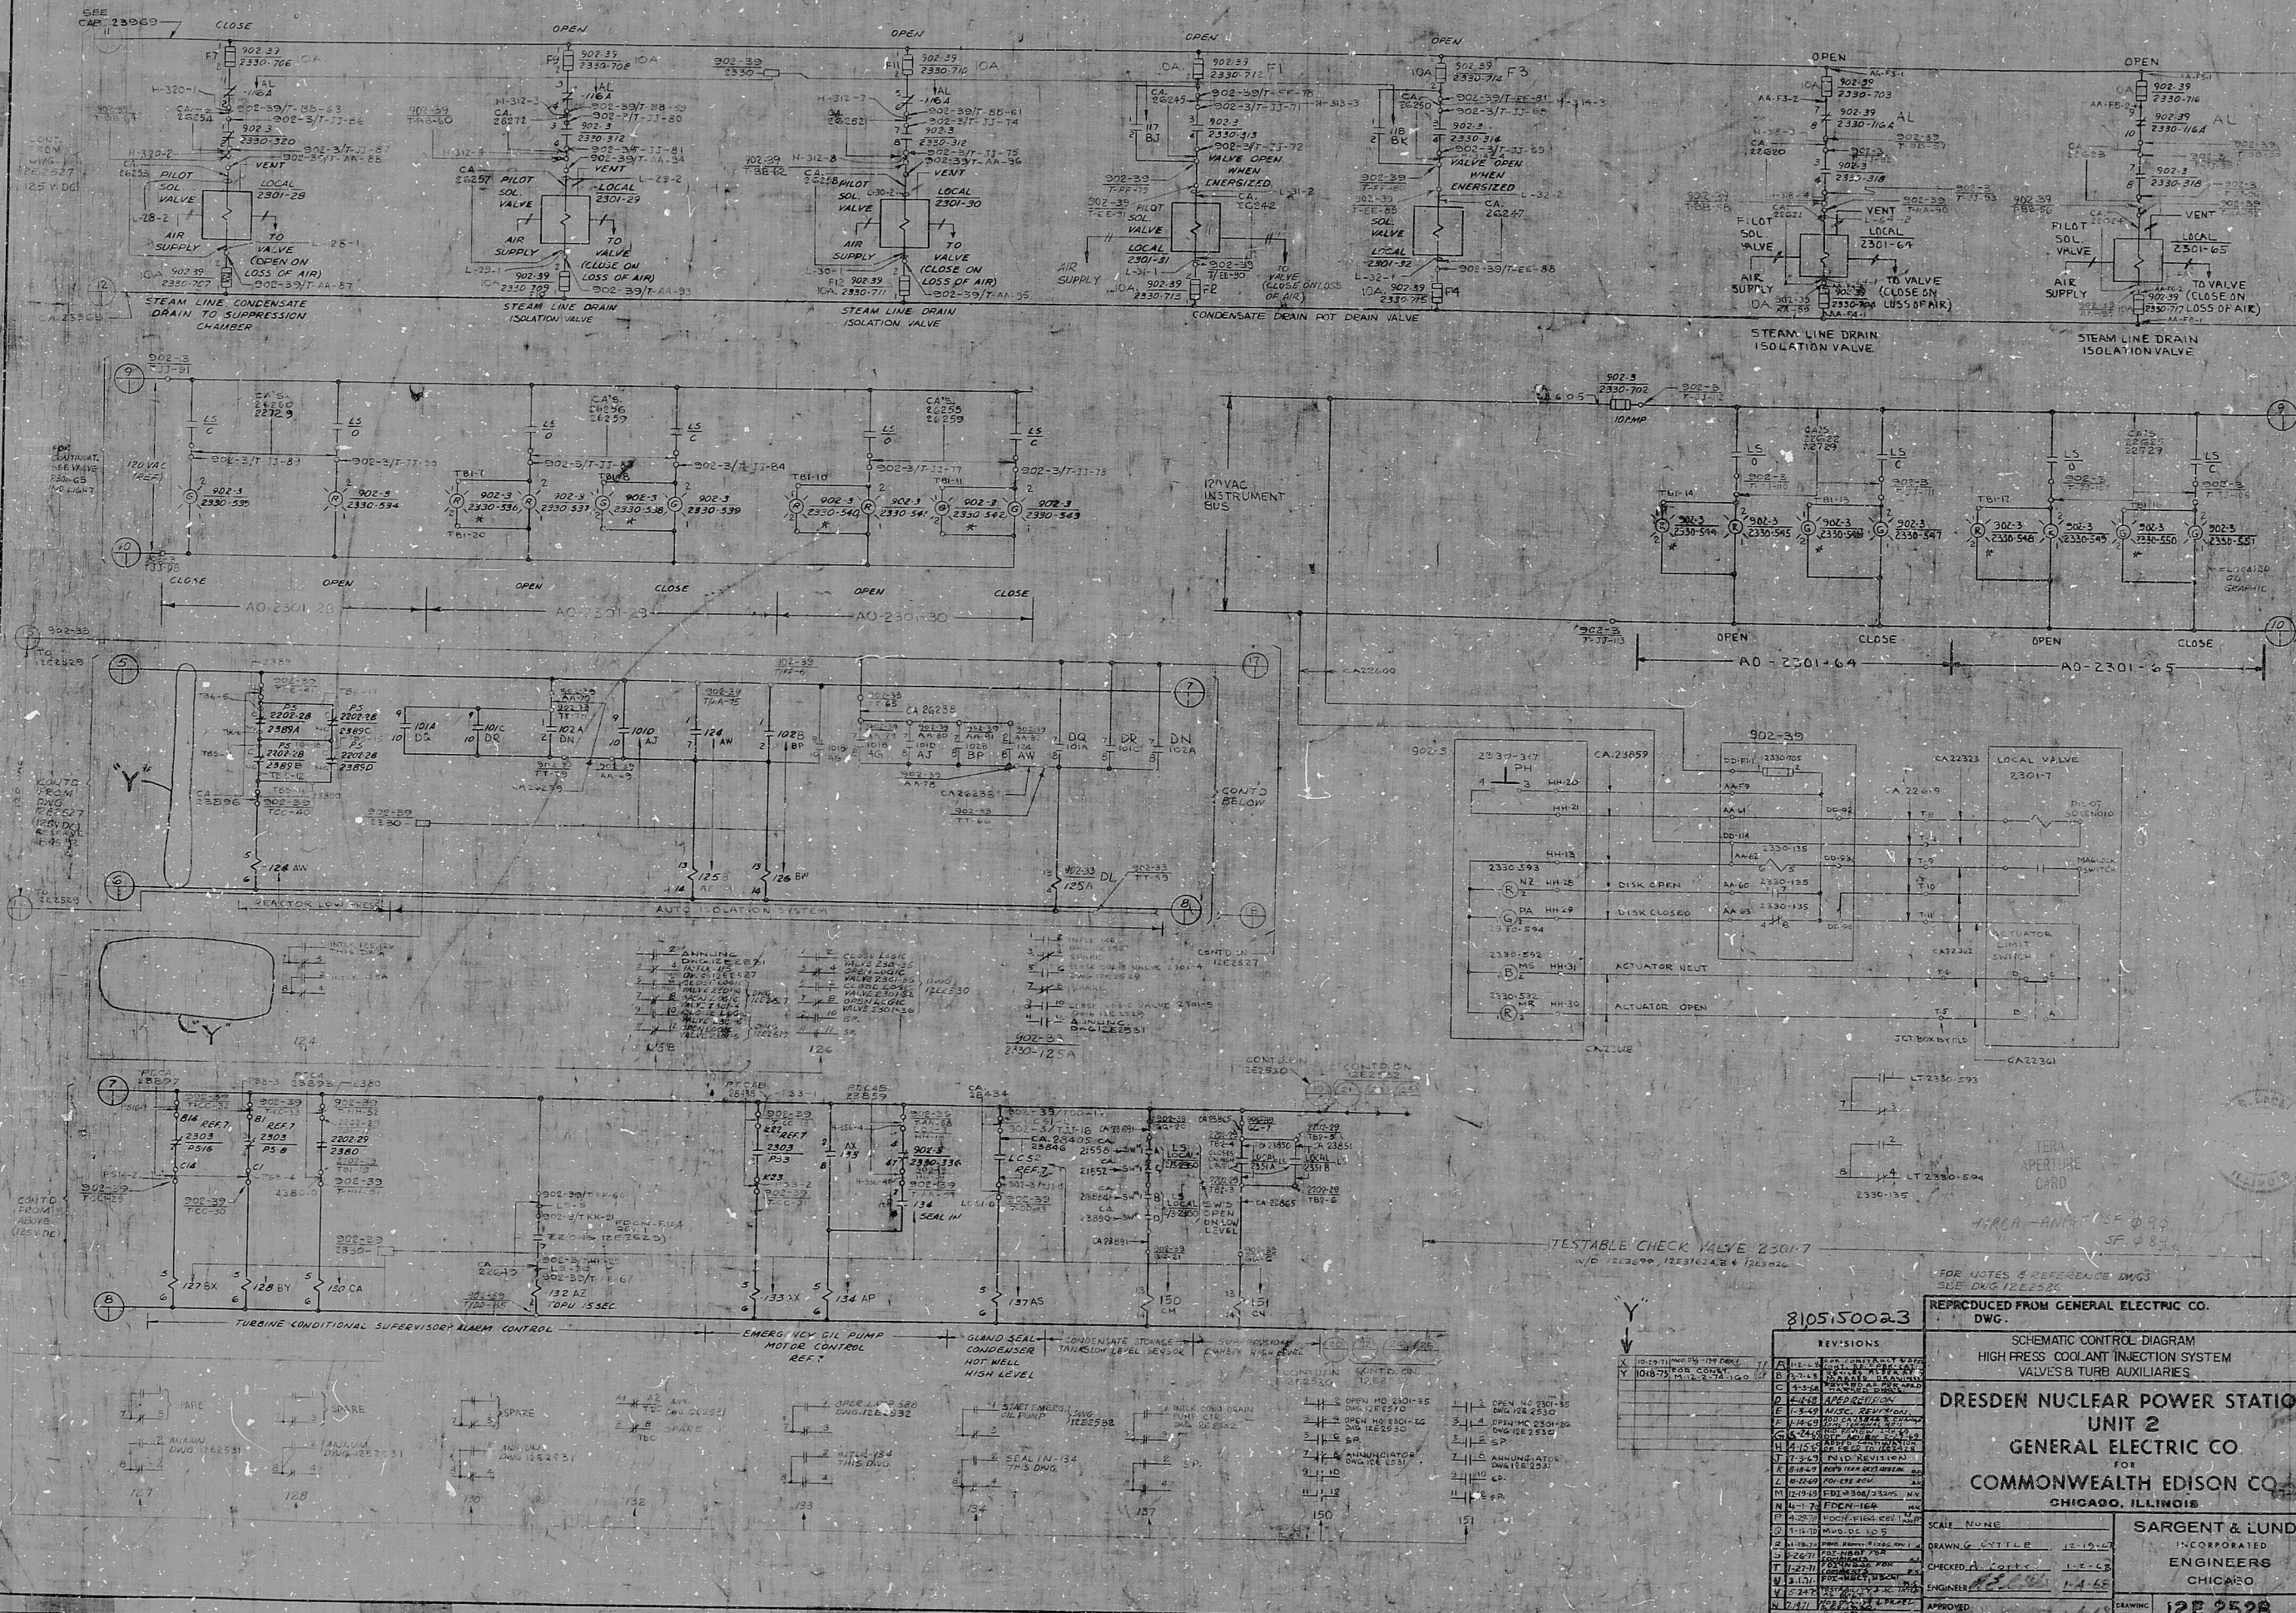

8105150023

REPRODUCED FROM GENERAL ELECTRIC CO. DWG.

SCHEMATIC CONTROL DIAGRAM
HIGH PRESS COOLANT INJECTION SYSTEM
VALVES & TURB AUXILIARIES
**DRESDEN NUCLEAR POWER STATION
UNIT 2**
GENERAL ELECTRIC CO
for
COMMONWEALTH EDISON CO
CHICAGO, ILLINOIS

SCALE: NONE
DRAWING TITLE: 12-10-12
CHECKED BY: J. L. LUNDY
ENGINEER: J. L. LUNDY
APPROVED: J. L. LUNDY
DATE: 12-10-12
DRAWING NUMBER: 125222

ERASE WITH WATER

DDAELB

8105150023

DOCKET
NUMBER

ACCESSION
NUMBER

DRAWING NUMBER

SHEET REV.

