


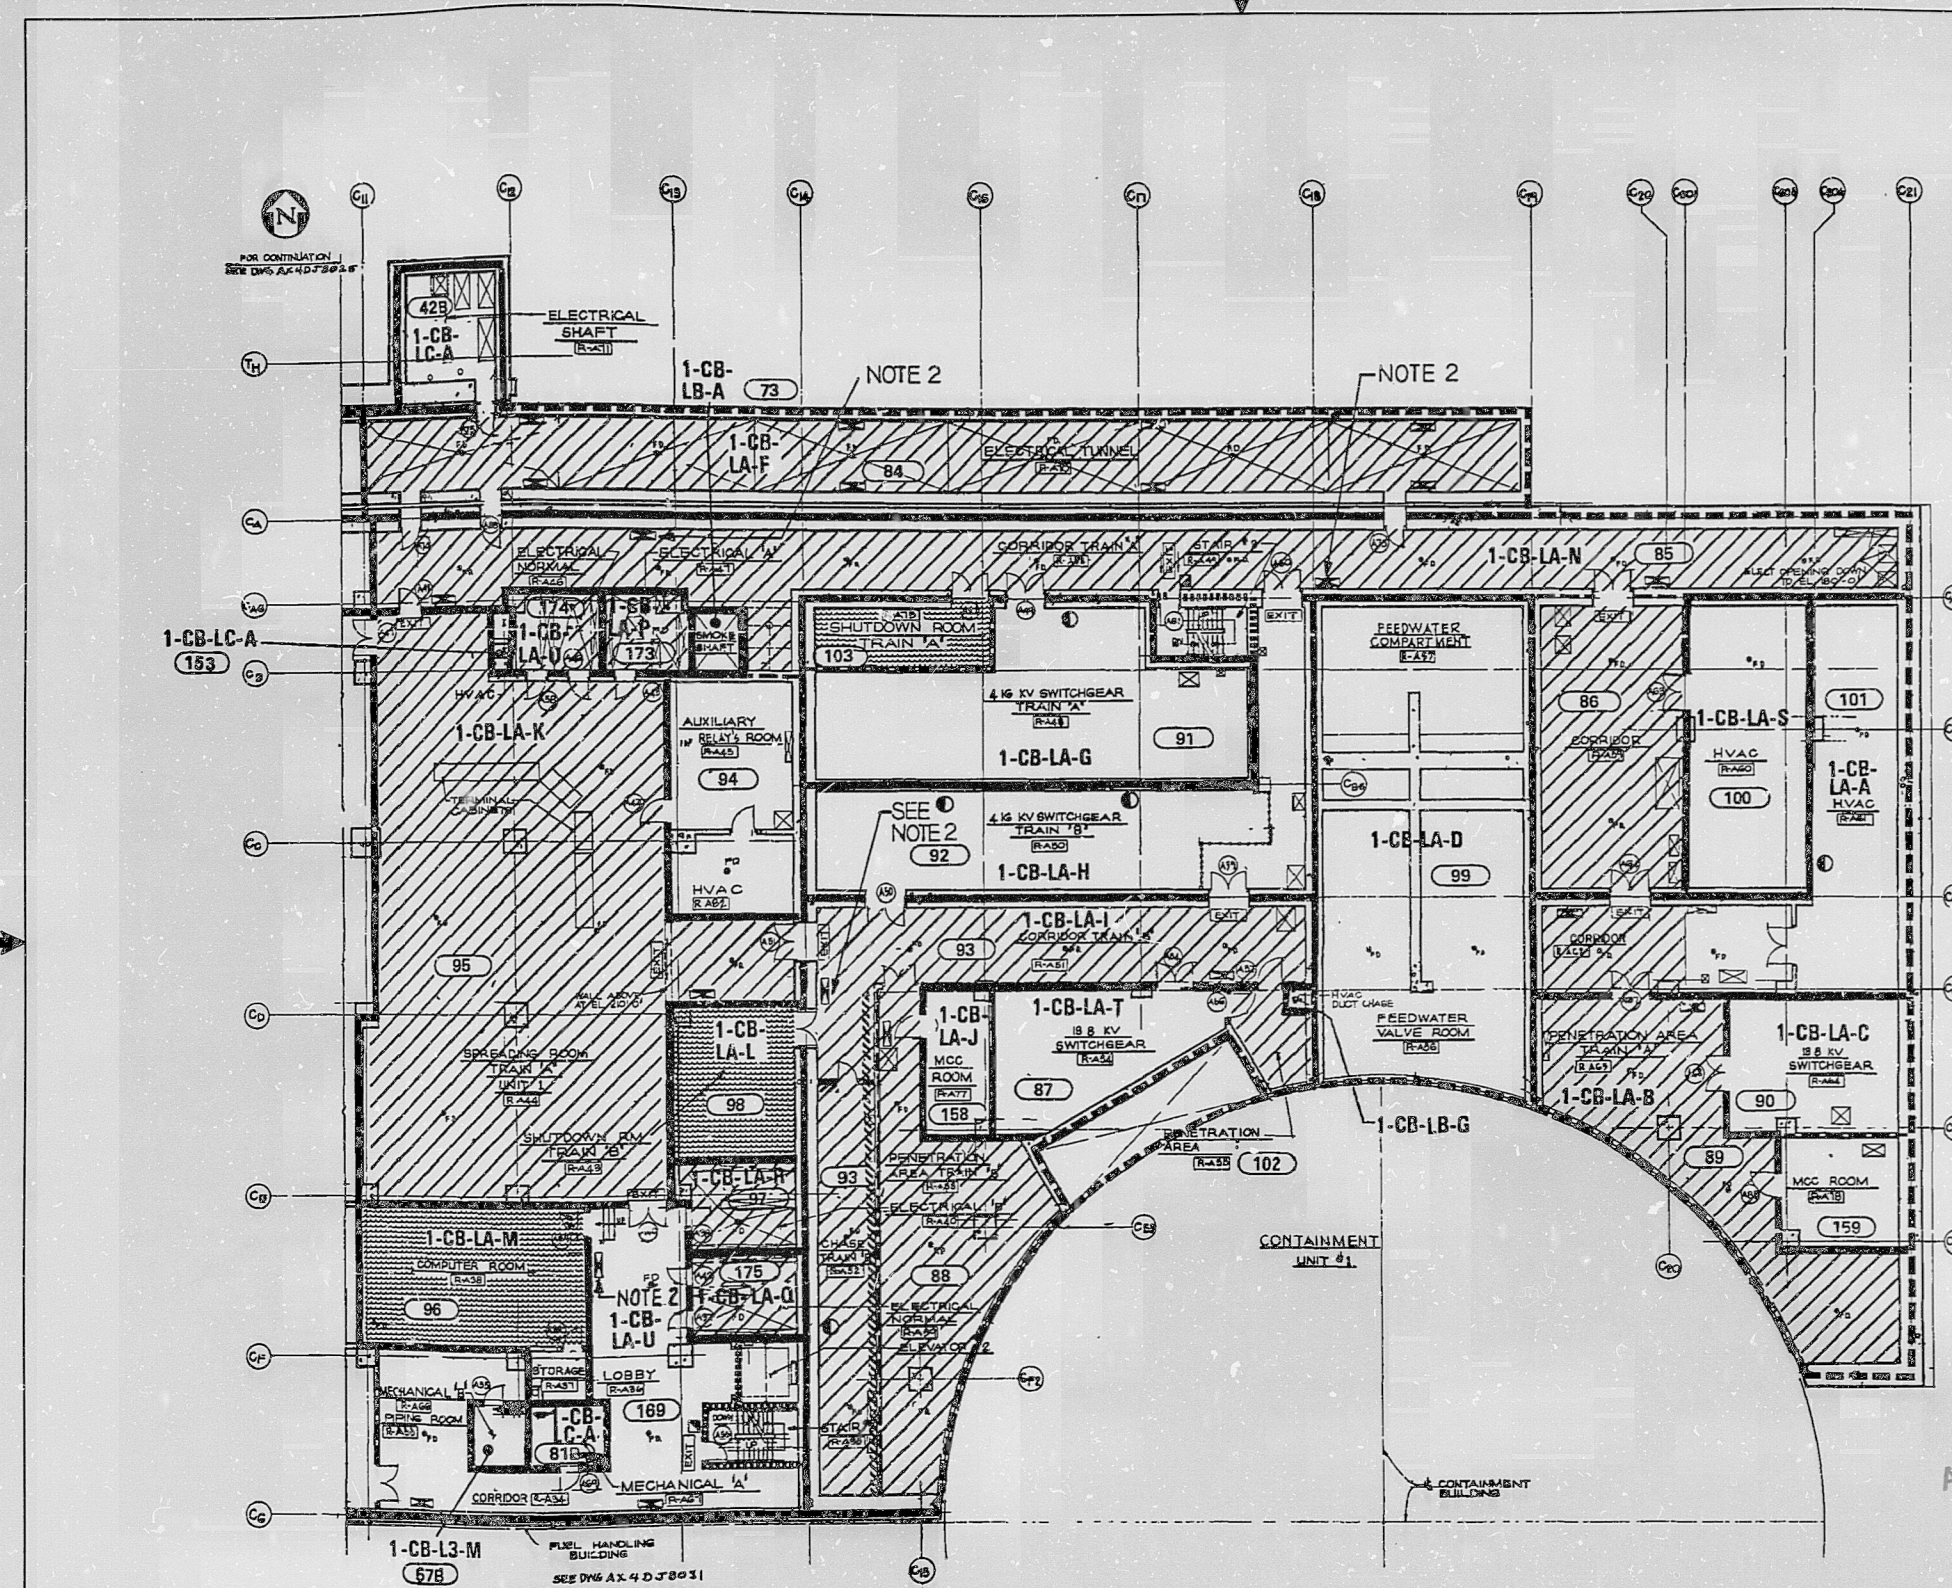

ELECTRICAL CABLE LOCATION CROSS REFERENCE		
FIRE ZONE	UNIT 1 E4 CODE	UNIT 2 E4 CODE
42B	TI	-
57B	JP	-
73	IT	-
81B	KP	-
84	VI	-
85	JE	-
86	KB	-
87	JL	-
88	JA	-
89	J2	-
90	J4	-
91	J8	-
92	J9	-
93	JA	-
94	KQ	-
95	JC	-
96	JE	-
97	J1	-
98	JD	-
99	J5	-
100	JK	-
101	J3	-
102	JL	-
103	J8	-
158	J8	-
159	J4	-
169	J6	-
173	JH	-
174	JG	-
175	J1	-
153	JQ	-

LEGEND	
[Symbol]	3 HR RATED FIRE AREA BOUNDARY
[Symbol]	UNRATED FIRE AREA BOUNDARY
[Symbol]	3 HR RATED BOUNDARY
[Symbol]	2 HR RATED BOUNDARY
[Symbol]	PRE ACTION SPRINKLER SYSTEM
[Symbol]	HALON SYSTEM
[Symbol]	FIRE HOSE CABINET
[Symbol]	FIRE HOSE REEL
[Symbol]	PORTABLE EXTINGUISHER
[Symbol]	EXIT SIGN LOCATION
[Symbol]	FIRE ALARM PULL BOX
[Symbol]	KNOCK OUT PANEL
[Symbol]	FIRE ZONE BOUNDARY
[Symbol]	FIRE ZONE DESIGNATOR

NOTES:
 1. THE BACKGROUND USED ON THIS DRAWING IS PROVIDED FOR ORIENTATION PURPOSES ONLY.
 2. THIS FIRE HOSE CABINET IS EQUIPPED WITH A PORTABLE HALON 1211 FIRE EXTINGUISHER.

NO.	REVISIONS	DATE	DR	CHK	APPV	DTL
1	INCORP. PER ABN-32053	7-29-97	LVL	MWD	EOG	
2	ISSUED FOR CONSTRUCTION					

SOUTHERN COMPANY SERVICES, INC.
 BIRMINGHAM, ALABAMA

GEORGIA POWER COMPANY
 ALVIN W. VOGTLE NUCLEAR PLANT

FIRE AREAS
 CONTROL BUILDING
 FLOOR PLAN EL. 200'-0"
 LEVEL A

SCALE: NONE
 JOB NO. 10604

DRAWING NO. AX4DJ8024
 REV. 5

CAD NAME A4DJ8024

THIS DOCUMENT CONTAINS PROPRIETARY, CONFIDENTIAL, AND/OR TRADE SECRET INFORMATION OF THE SUBSIDIARIES OF THE SOUTHERN COMPANY OR OF THIRD PARTIES. IT IS INTENDED FOR USE ONLY BY EMPLOYEES OF, OR AUTHORIZED CONTRACTORS OF, THE SUBSIDIARIES OF THE SOUTHERN COMPANY. UNAUTHORIZED POSSESSION, USE, DISTRIBUTION, COPYING, DISSEMINATION, OR DISCLOSURE OF ANY PORTION HEREOF IS PROHIBITED.

9910210021


PDR RIDS

[REDACTED]

9910210021

11
11
11
11

[REDACTED]

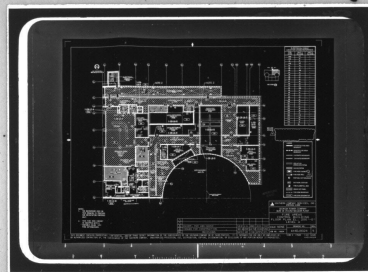

11