


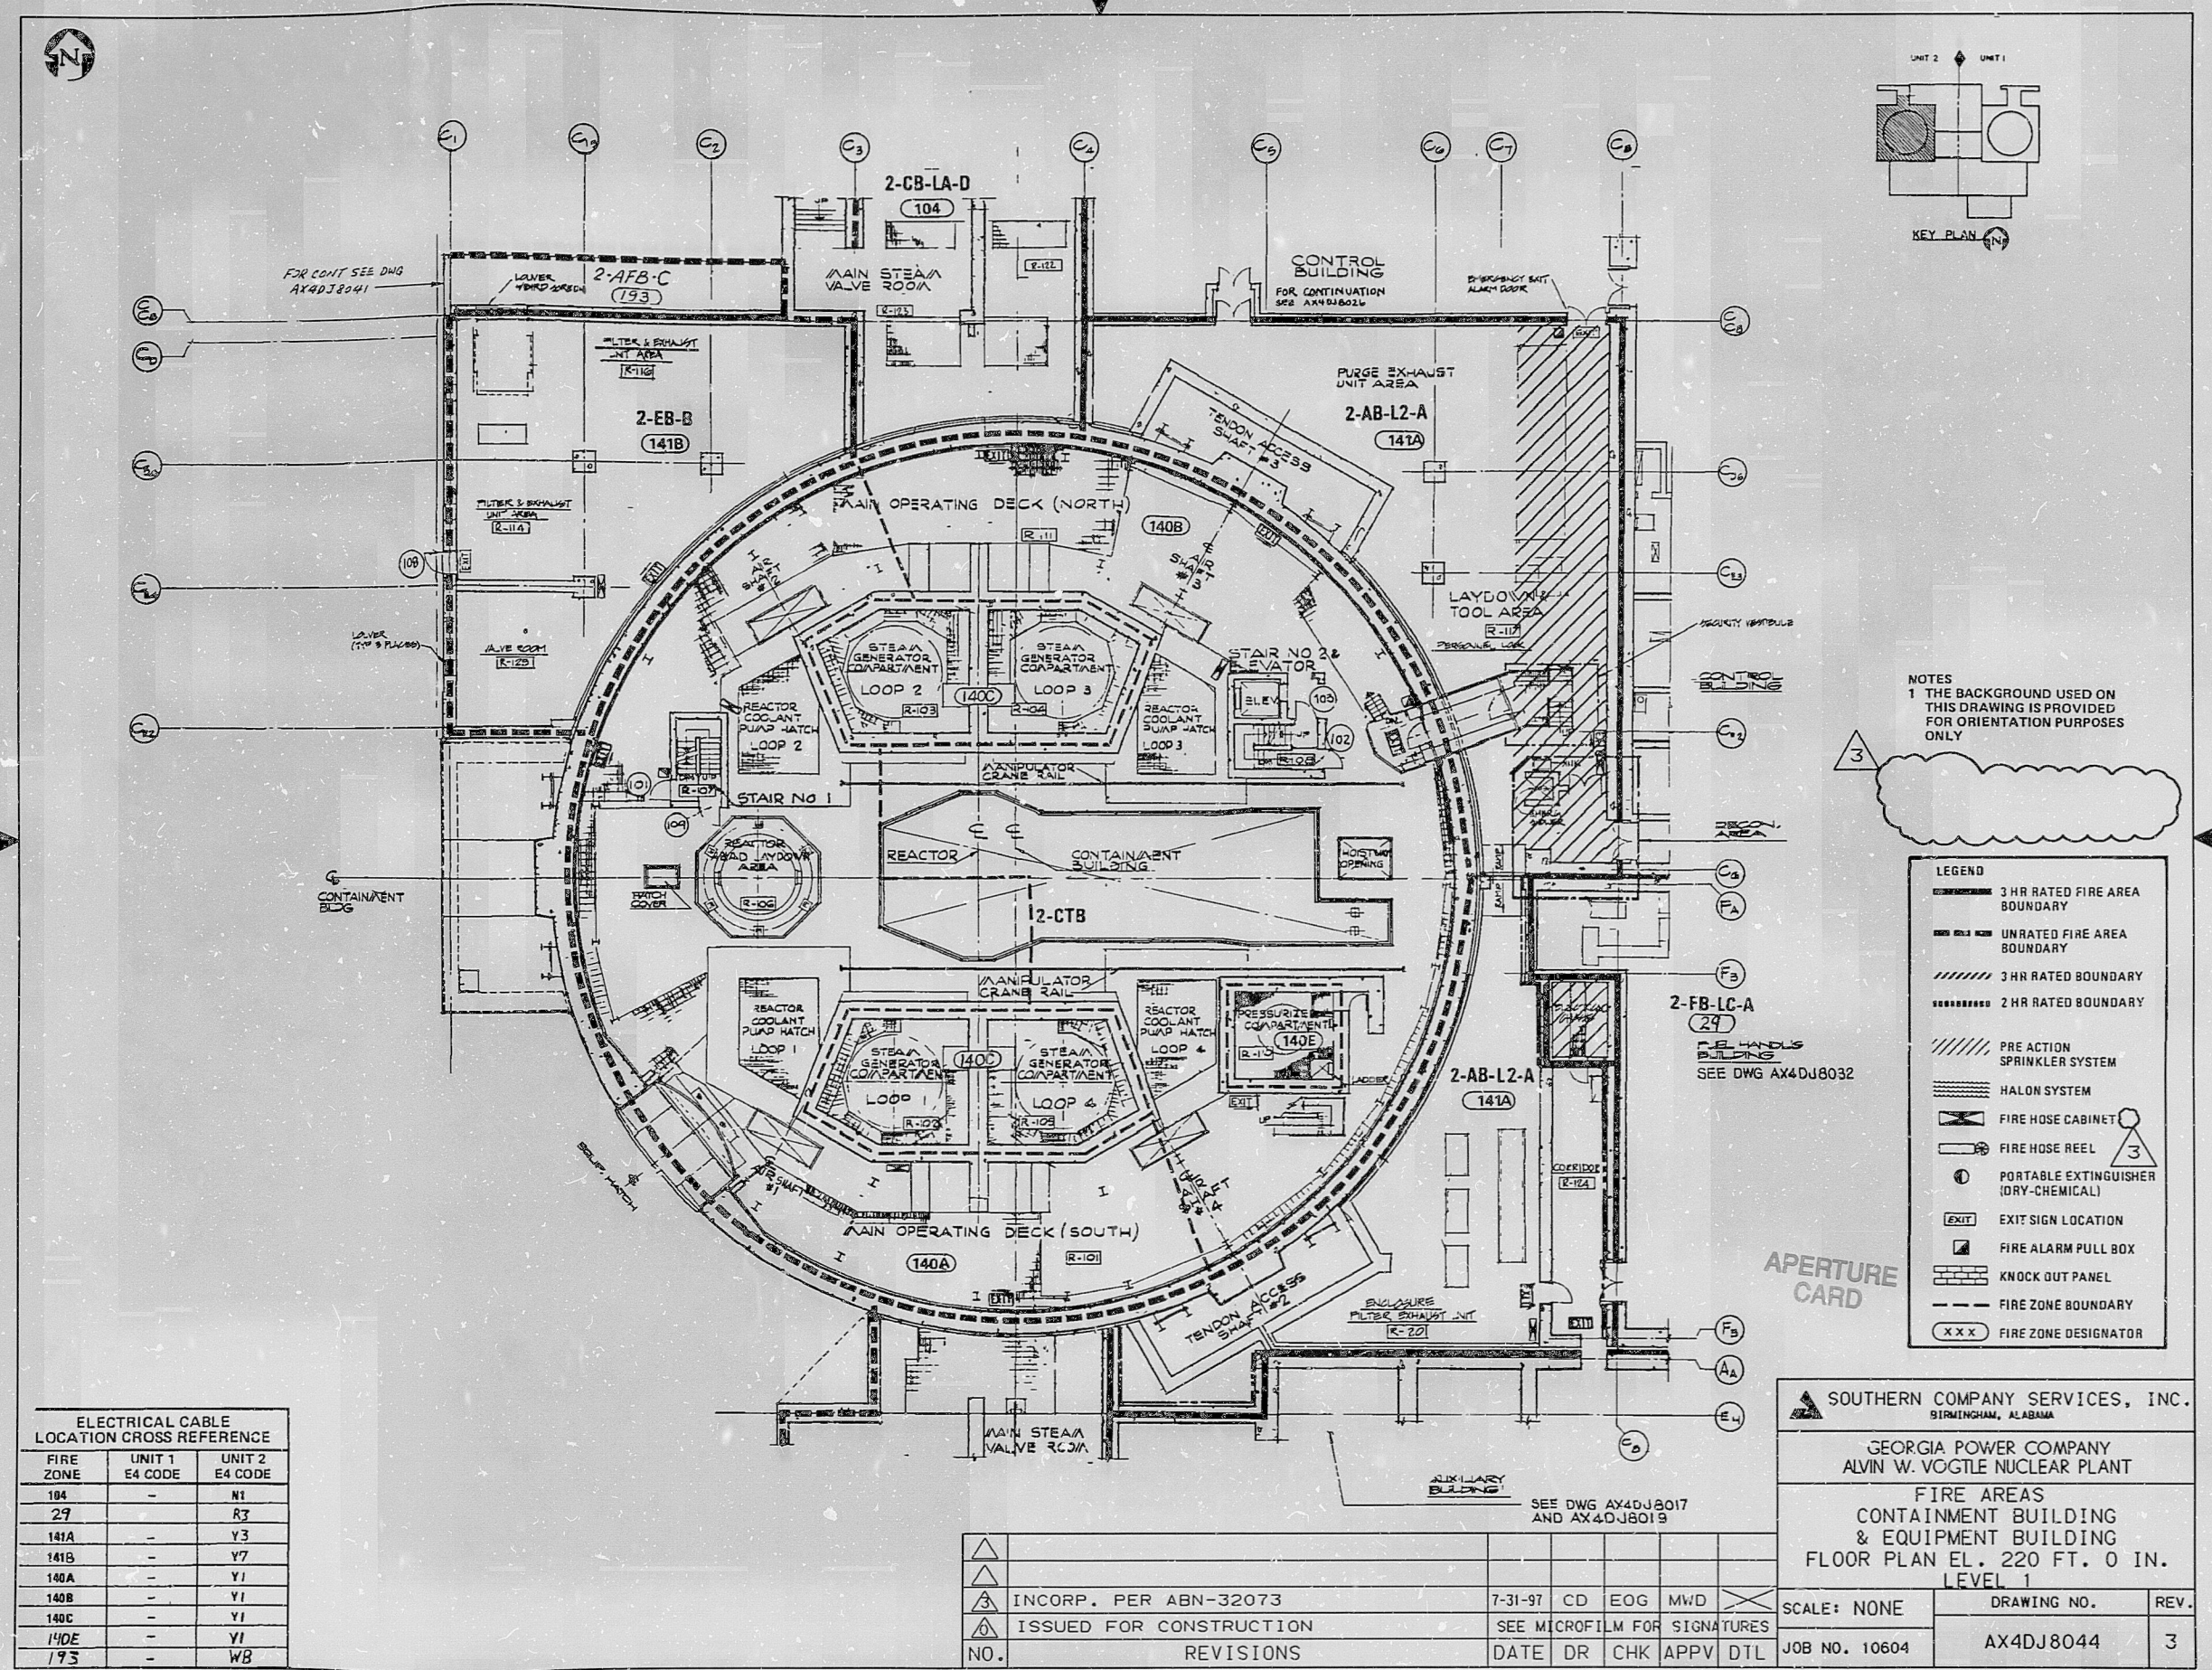

ELECTRICAL CABLE LOCATION CROSS REFERENCE		
FIRE ZONE	UNIT 1 E4 CODE	UNIT 2 E4 CODE
104	-	N1
29	-	R3
141A	-	Y3
141B	-	Y7
140A	-	Y1
140B	-	Y1
140C	-	Y1
140E	-	Y1
193	-	WB

REVISIONS					
NO.	DATE	DR	CHK	APPV	DIT
1	7-31-97	CD	EOG	MWD	
2					
3					

SOUTHERN COMPANY SERVICES, INC. BIRMINGHAM, ALABAMA		
GEORGIA POWER COMPANY ALVIN W. VOGTLE NUCLEAR PLANT		
FIRE AREAS CONTAINMENT BUILDING & EQUIPMENT BUILDING FLOOR PLAN EL. 220 FT. 0 IN. LEVEL 1		
SCALE: NONE	DRAWING NO.	REV.
JOB NO. 10604	AX4DJ8044	3

THIS DOCUMENT CONTAINS PROPRIETARY, CONFIDENTIAL, AND/OR TRADE SECRET INFORMATION OF THE SUBSIDIARIES OF THE SOUTHERN COMPANY OR OF THIRD PARTIES. IT IS INTENDED FOR USE ONLY BY EMPLOYEES OF, OR AUTHORIZED CONTRACTORS OF, THE SUBSIDIARIES OF THE SOUTHERN COMPANY. UNAUTHORIZED POSSESSION, USE, DISTRIBUTION, COPYING, DISSEMINATION, OR DISCLOSURE OF ANY PORTION HEREOF IS PROHIBITED.

SIZE C 17X22 CAD NAME
A4DJ8044

PDR RIDS 9910210172

[REDACTED]

9910210172

[REDACTED]

