


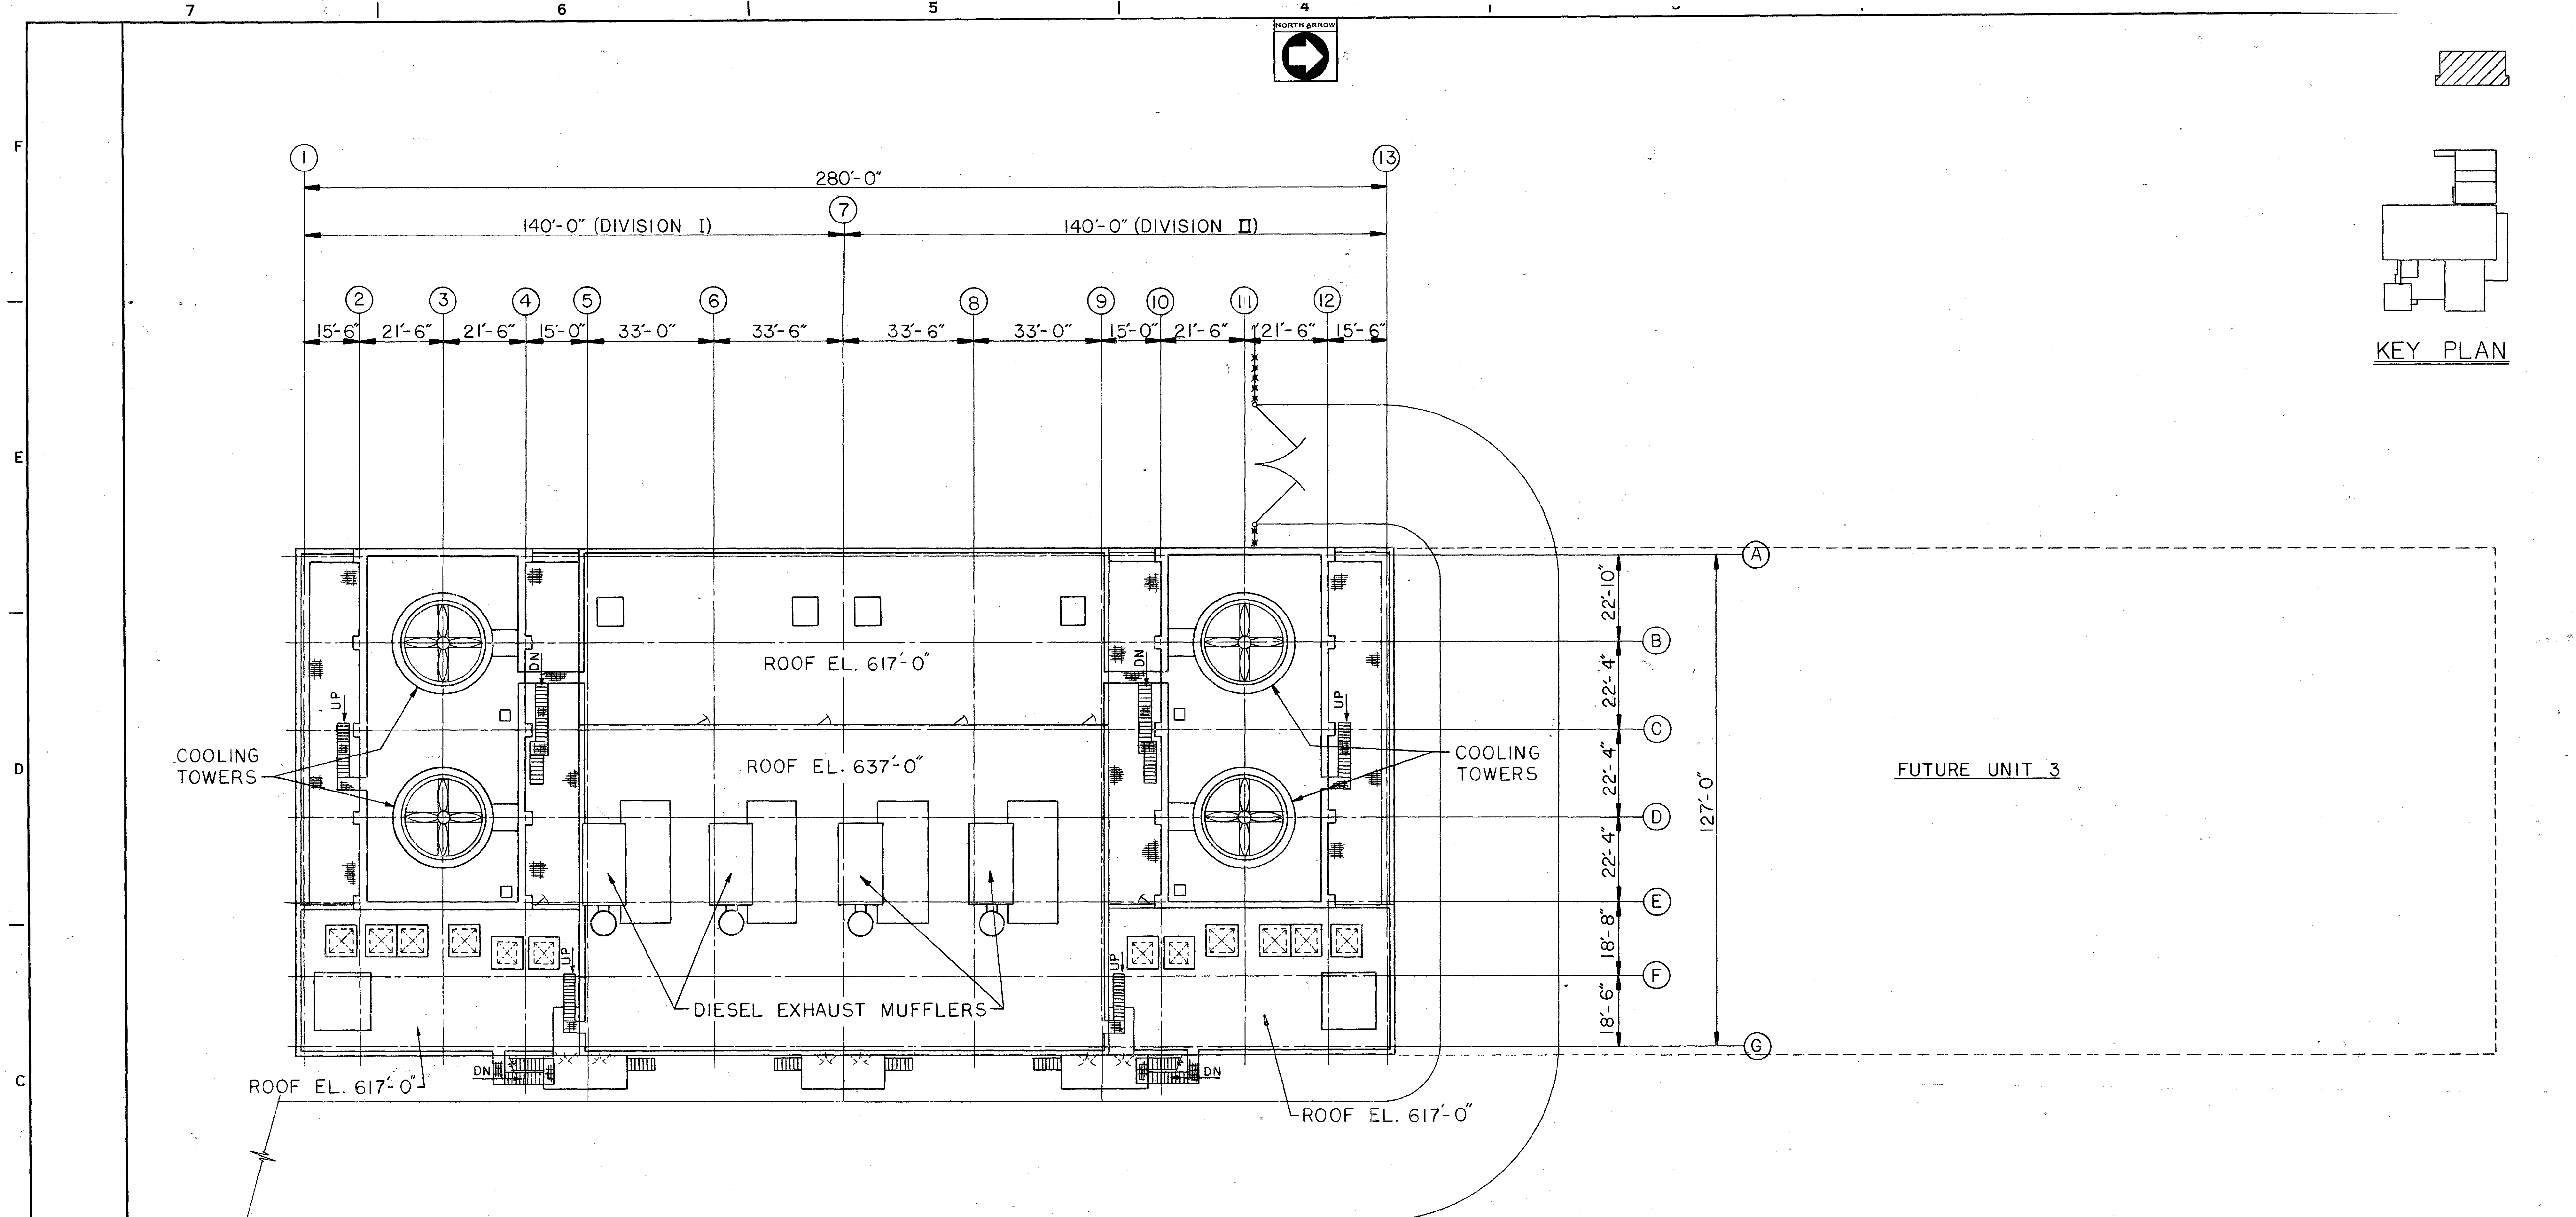

KEY PLAN

6A72IN-2043
LATEST REVISION "A"

ARMS INFORMATION SYSTEMS
DTC: DDDACS
PAGE: 1
REV: A
DATE: Nov 28, 1984
PIS: X80030
RECHMENT: NO
APPROVAL REQ'D: YES

NON-NUCLEAR SAFETY RELATED

THIS IS AN INITIAL EDISON
TSRB AND APPROVAL.

GILBERT ASSOCIATES, INC. ENGINEERS AND CONSULTANTS READING, PA	
ENGINEERING DEPARTMENTS	
TITLE: FIRE PROTECTION EVALUATION RESIDUAL HEAT REMOVAL COMPLEX ROOF - PLAN - EL. 617'-0" AND 637'-0" LOCATION: ENRICO FERMIL ATOMIC POWER PLANT UNIT 2	
DOCUMENT CONTROL NO. X80-03-D-000-DA-011 X00-63	
DRAWING NUMBER: 04 4761 D-023-015	
DRAFTING: MTW/JWM CHECKED: J. McMillen DATE: 6-25-77 SCALE: 1/8"=1'-0"	
DIVISION: ARCH-CIVIL SUPERVISOR: JL BELKO DATE: 11-28-77 PROJECT ENGINEER: FB YOUNG DATE: 12-7-77 PROJECT DIRECTOR: WF COLBERT/WMS DATE: 1-17-78 MECH: WALLACE DATE: 11-28-77 DIVISION DIRECTOR: DAVID SPIERS DATE: 1-5-78	
STATIONS: ENG.	
ORDER NO.: 8BP1AO	

I		H		G		F		E		D		C		B		A	
PROJ. ENG.	PROJ. DIR.	PROJ. ENG.	PROJ. DIR.	PROJ. ENG.	PROJ. DIR.	PROJ. ENG.	PROJ. DIR.	PROJ. ENG.	PROJ. DIR.	PROJ. ENG.	PROJ. DIR.	PROJ. ENG.	PROJ. DIR.	PROJ. ENG.	PROJ. DIR.	PROJ. ENG.	PROJ. DIR.
OPW		OPW		OPW		OPW		OPW		OPW		OPW		OPW		OPW	
MADE BY	DATE	ARCH-CIVIL	ELECT.	MADE BY	DATE	ARCH-CIVIL	ELECT.	MADE BY	DATE	ARCH-CIVIL	ELECT.	MADE BY	DATE	ARCH-CIVIL	ELECT.	MADE BY	DATE
CHK BY	DATE	MECH.	DIV. DIRECTOR	CHK BY	DATE	MECH.	DIV. DIRECTOR	CHK BY	DATE	MECH.	DIV. DIRECTOR	CHK BY	DATE	MECH.	DIV. DIRECTOR	CHK BY	DATE