


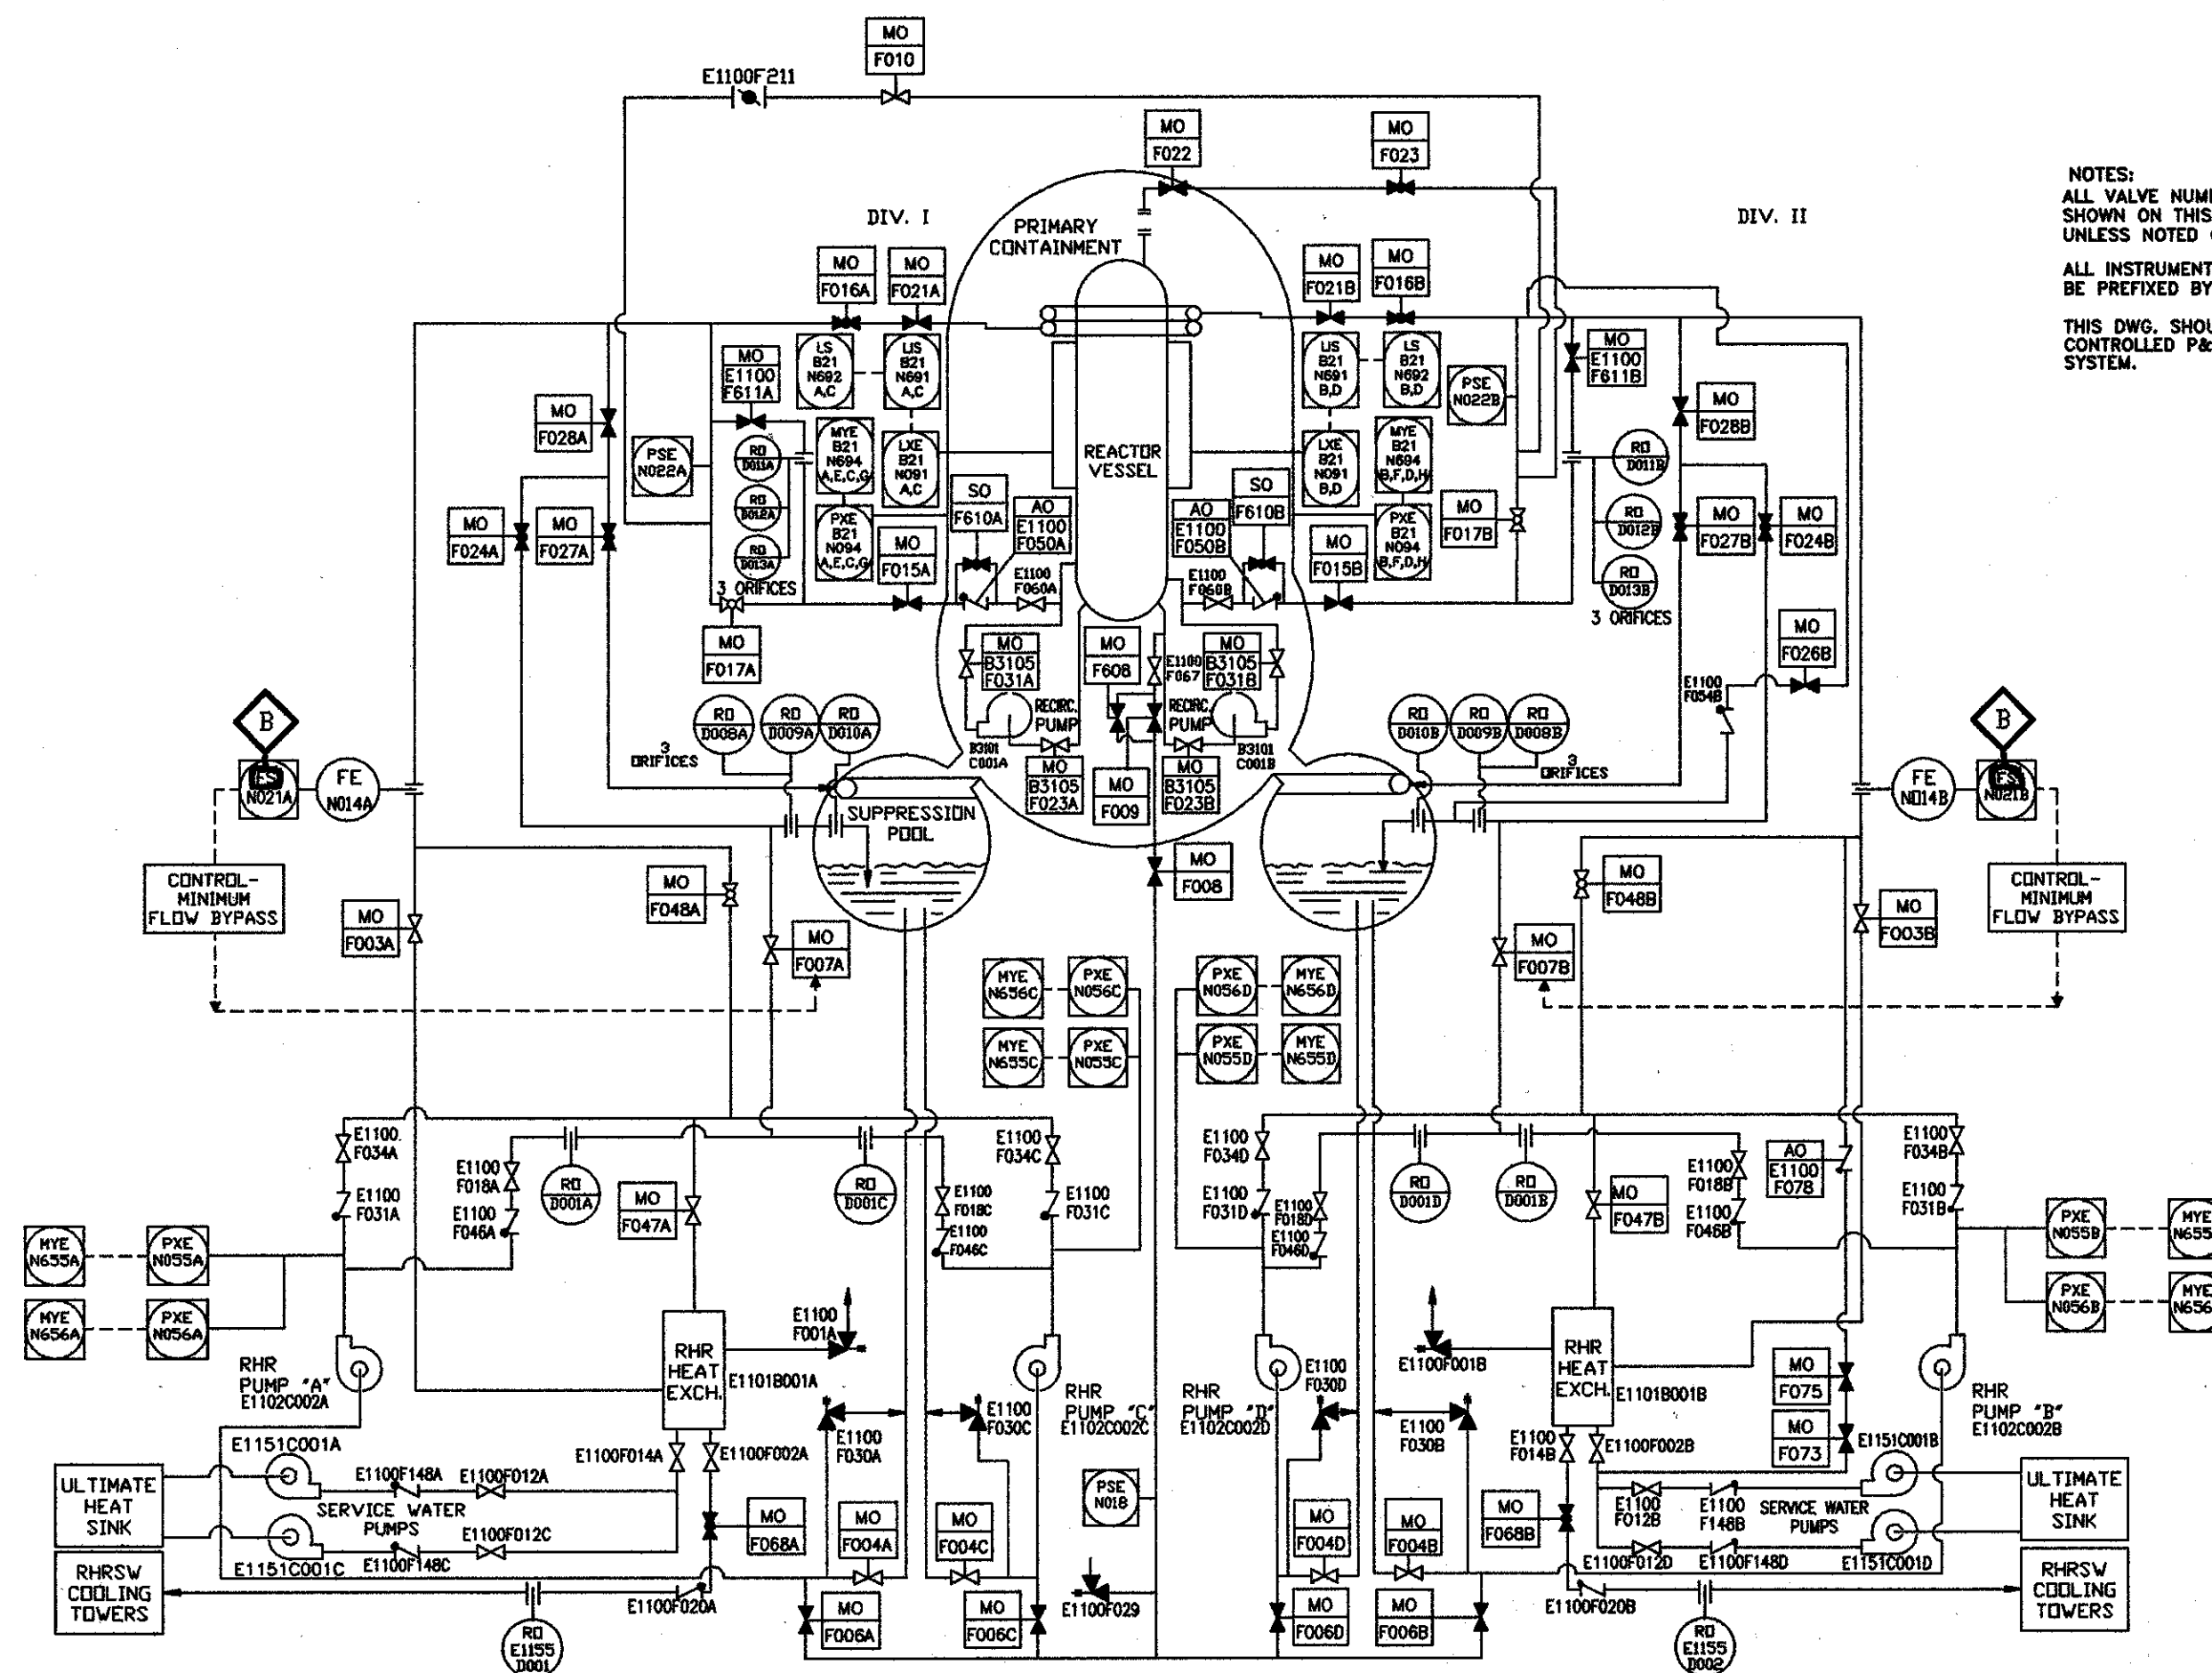

NOTES:
ALL VALVE NUMBERS AND PIPING ORIFICES
SHOWN ON THIS DIAGRAM SHOULD BE PREFIXED BY E1150
UNLESS NOTED OTHERWISE.
ALL INSTRUMENTATION SHOWN ON THIS DIAGRAM SHOULD
BE PREFIXED BY E11 UNLESS NOTED OTHERWISE.
THIS DWG. SHOULD NOT BE CONSTRUED AS THE
CONTROLLED P&ID OF THE RESIDUAL HEAT REMOVAL
SYSTEM.

4M721-5862
LATEST REVISION

B

NUCLEAR SAFETY RELATED

THIS IS AN AUTOCAD PRODUCED DRAWING.
CHANGES OR REVISIONS MUST BE BROUGHT
TO THE ATTENTION OF THE PLANT ENGINEERING
DESIGN GROUP TO ENSURE THAT CONFIGURATION
CONTROL IS MAINTAINED.

B DCD'S INCORPORATED: EDP 27275 REV. 8 EDP 27329 REV. 8			
OTHER REVISIONS:			
PREPARED BY JIGNESH SHAH	DATE 6/7/96	CHECKED BY S.M. PATEL	DATE 6/25/96
APPROVED BY G. SCARF	DATE 6/25/96		

A PORTION OF THIS DRAWING
IS AFFECTED BY THE FOLLOWING:

TC	CHANGE DOCUMENT

EDP POSTING ENTRIES REQUIRE THE
ADDITION OF THE ARMS STATUS CODE
EITHER 'AFC' OR 'ASB'

PREPARED BY

INC. CODE

U

CHECKED BY

APPROVED BY

OTHER APPROVALS

DATE

DATE

DATE

DATE

Detroit Edison

Fermi 2

TITLE

RESIDUAL HEAT REMOVAL
VALVE POSITIONS DURING NORMAL
REACTOR OPERATIONS

APERTURE CARD TITLE

UFSAR FIG. 5.5-14

PLANT IDENTIFICATION SYSTEM NUMBER

E1100

DOCUMENT TYPE CODE

DDDMC

NUC OPS FILE NO.

1801

ARMS RECIPIENT #

DATE ISSUED TO IS

6-27-96

DRAWING NUMBER

4M721-5862

REV.

B