


E

D

C

B

A

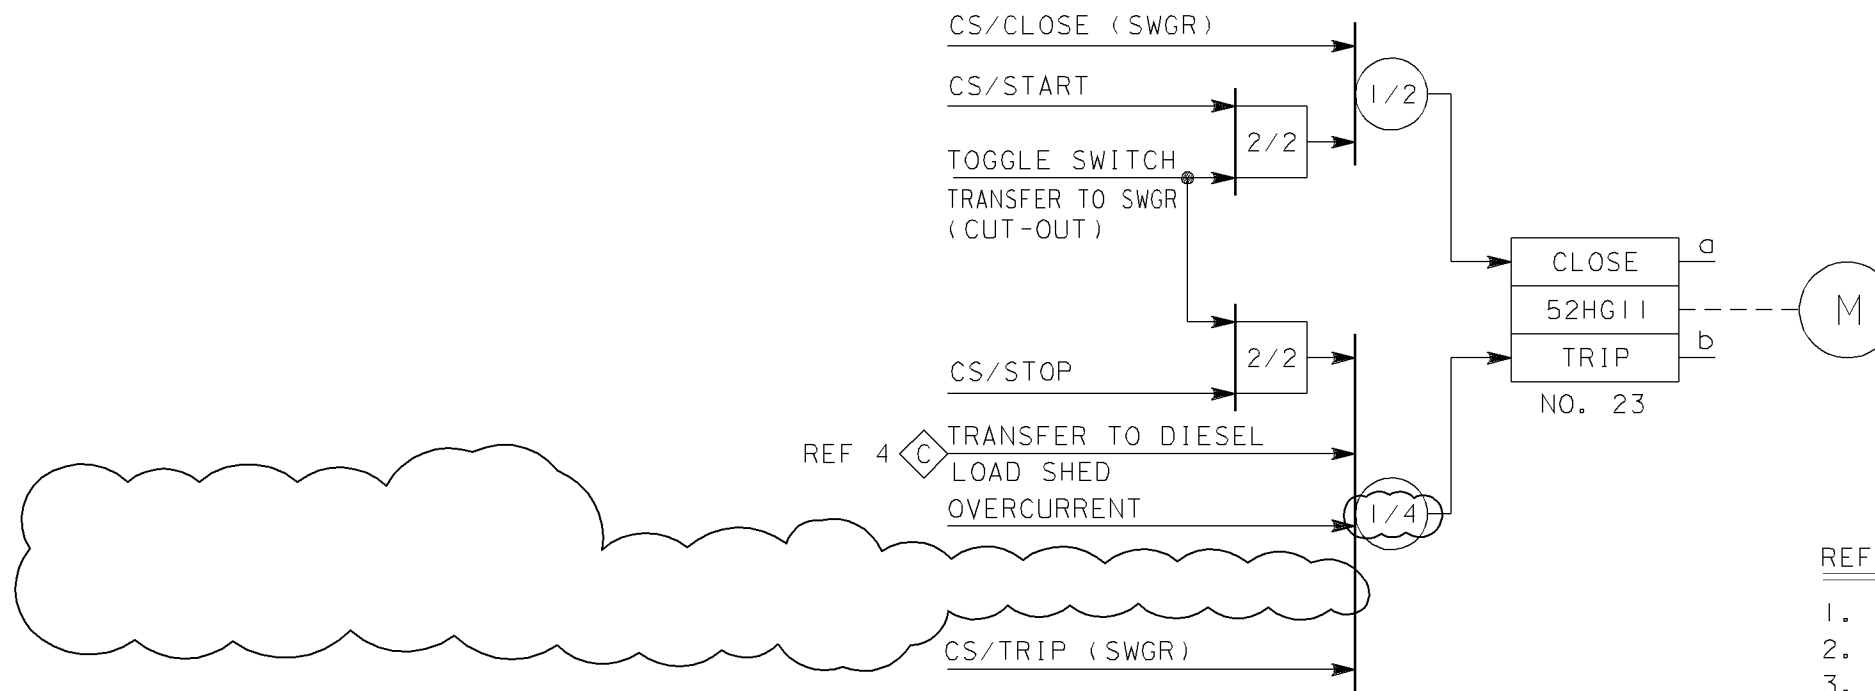

- REFERENCES: DWG NO.
1. LOGIC DIAGRAM SYMBOLS \_\_\_\_\_ 19425
  2. SCH DIAG CHARGING PUMP #23 \_\_\_\_\_ 4008751
  3. SLM&R DIAG 4KV BUS G & H \_\_\_\_\_ 441230
  4. LOGIC DIAG 4KV BUS SECT G TRANS \_\_ 441297

# NUCLEAR SAFETY RELATED

KEY DWG. SECTION 3

UNIT 2

RASTER=102788.dgn  
 DGN=102788.dgn  
 CAD User:FAZI Date:04-09-2008

	DATE 04-09-2008		REVISION DESCRIPTION REVISED PER DC2-SE-50704-01	I & C LOGIC DIAGRAM (CENTRIFUGAL) CHARGING PUMP (2-3)	DWG SCALE:								
	D. D. FAZI					BILL OF MATL:							
	R. E. FxC2					SUPSDS:							
	I. V.					SUPSD BY:							
	P. E. AGB2					<table border="1" style="width: 100%; border-collapse: collapse;"> <tr> <td style="width: 25%;">DRAWING</td> <td style="width: 12.5%;">SHEET</td> <td style="width: 12.5%;">PAGE</td> <td style="width: 12.5%;">REV</td> </tr> <tr> <td style="font-size: 24pt;">102788</td> <td style="text-align: center;">1</td> <td style="text-align: center;">0</td> <td style="text-align: center;">5</td> </tr> </table>	DRAWING	SHEET	PAGE	REV	102788	1	0
DRAWING	SHEET	PAGE	REV										
102788	1	0	5										

DIABLO CANYON POWER PLANT  
 PACIFIC GAS AND ELECTRIC COMPANY  
 SAN FRANCISCO, CALIFORNIA