


RASTER=2016sl.dgn
 DGN=2016sl.dgn
 CAD User: JBMX Date: 11-01-2010

BASIC DIAGRAM

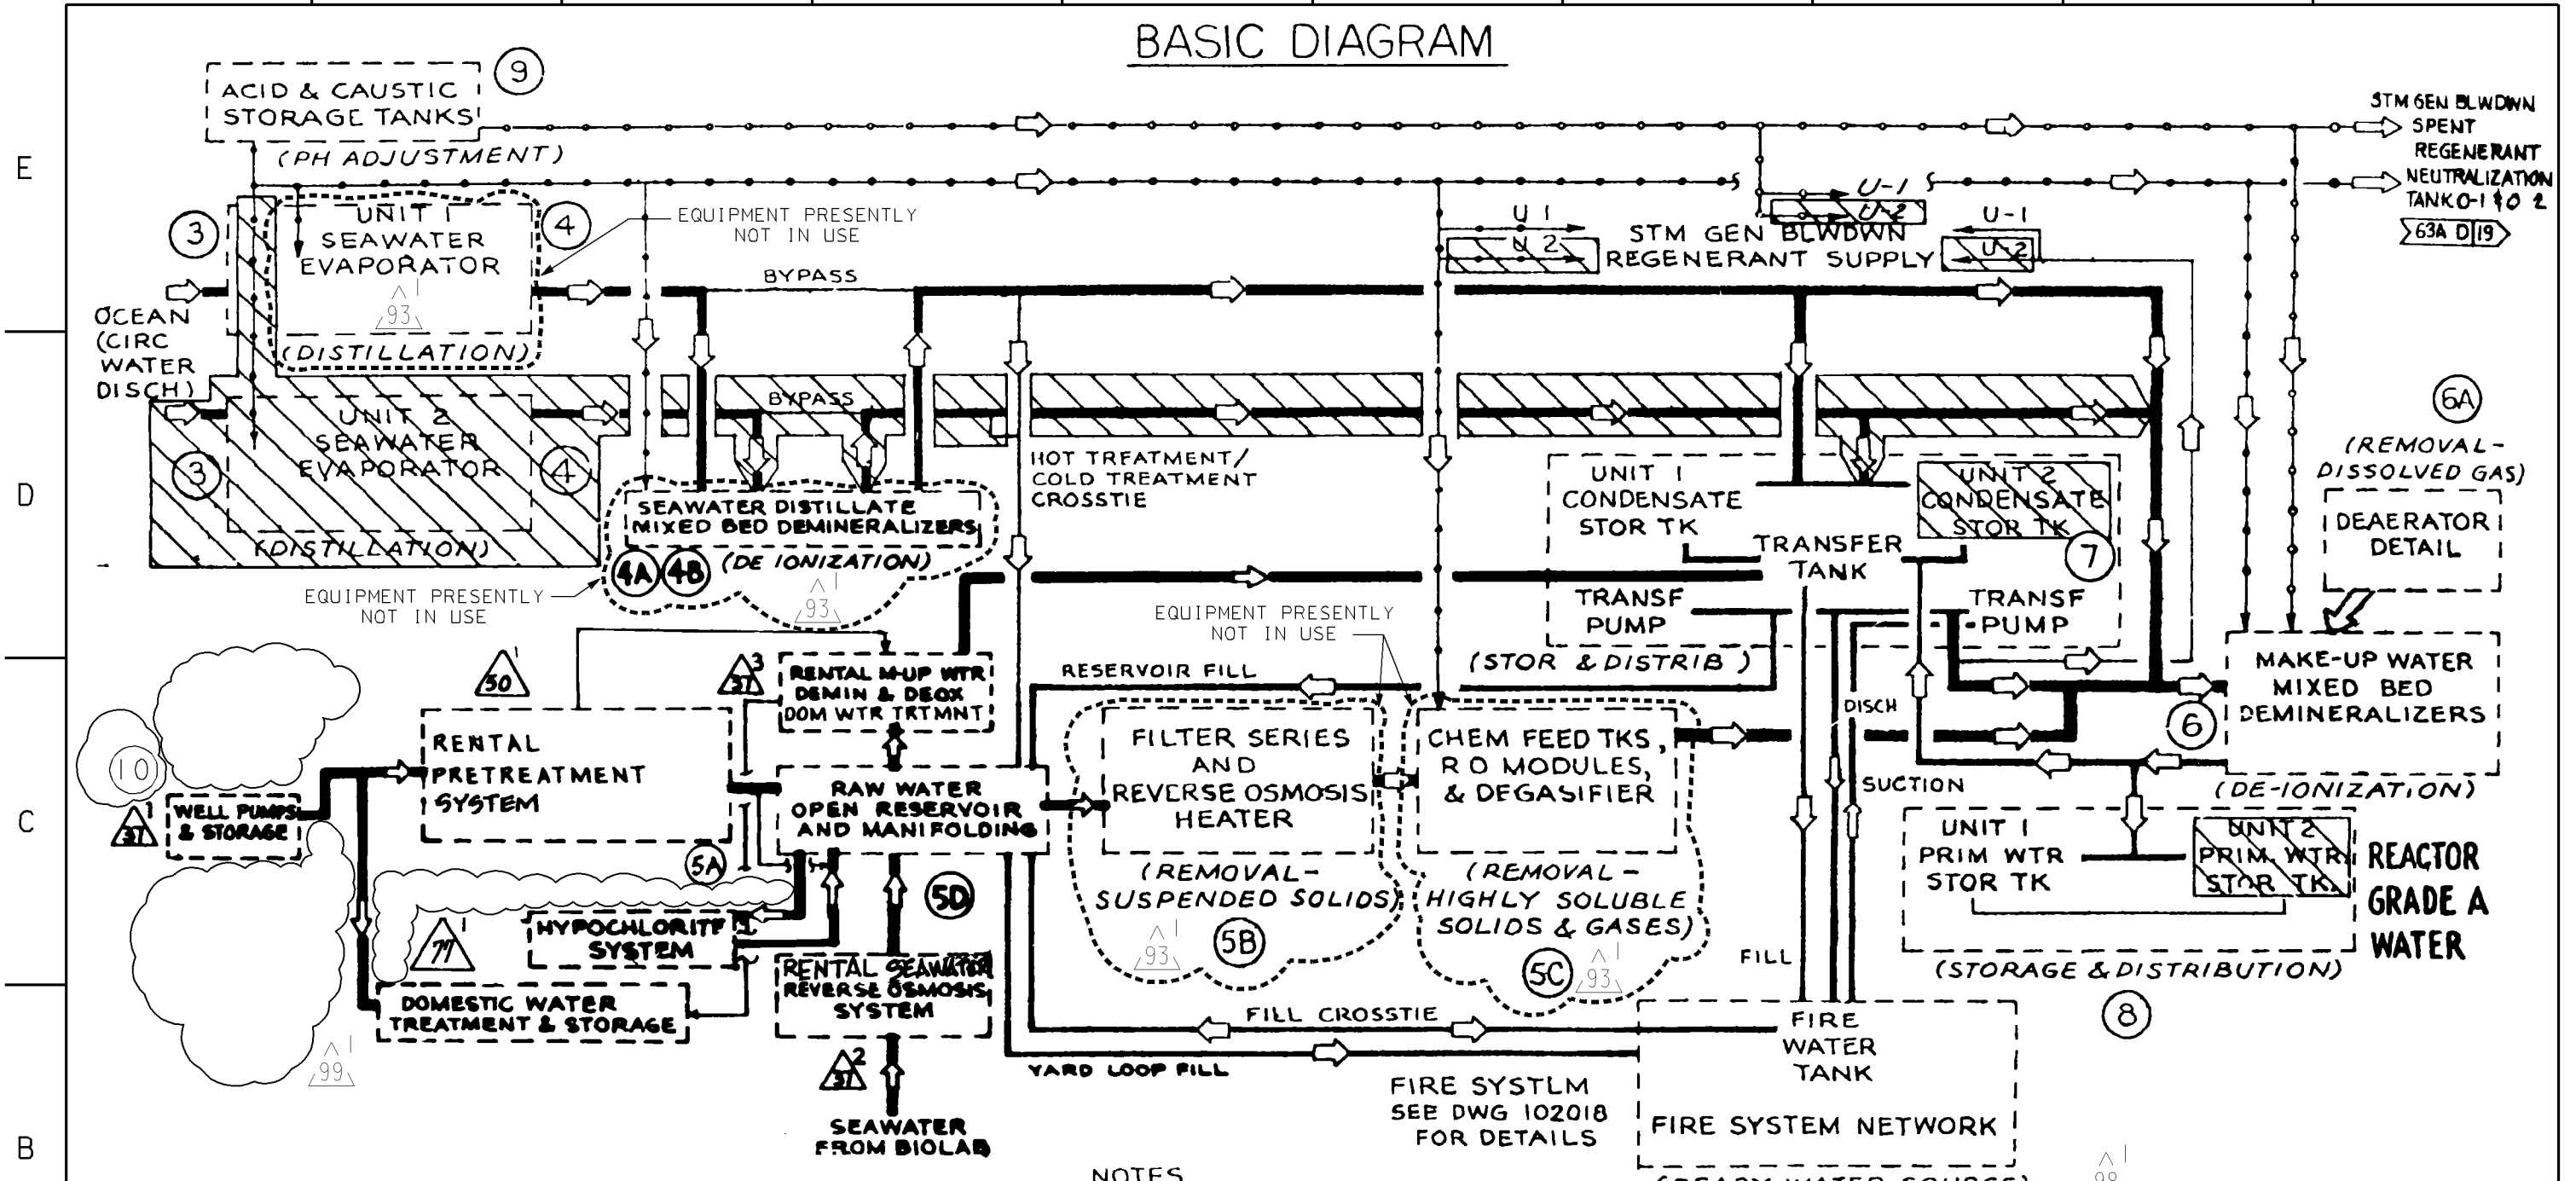

NOTES

- 1 (N) INDICATES DRAWING SHEET NUMBER
- 2 SEE SHEET 2 FOR EQUIPMENT, VALVING AND DETAILS OF BASIC DIAGRAM

FROM THIS REVISION FORWARD EACH SHEET WILL BE REVISED INDIVIDUALLY. SHEET 1 DOES NOT REQUIRE REVISION WITH OTHER SHEETS. REFER TO SHEET 27 FOR CHANGE INFORMATION. CHANGE INFORMATION SHEET CAN BE VIEWED IN THE WIP LIBRARY.

UNIT 1

	DATE		REVISION DESCRIPTION		PIPING SCHEMATIC MAKE-UP WATER SYSTEM				DWG SCALE:			
	11-01-2010		REVISED PER DDN-2*715						BILL OF MATL:			
	D.D.	JBMX			DIABLO CANYON POWER PLANT PACIFIC GAS AND ELECTRIC COMPANY SAN FRANCISCO, CALIFORNIA				SUPSDS:			
	R.E.	FxC2							SUPSD BY:			
	I.V.								DRAWING	SHEET	PAGE	REV
P.E.	KJD3			102016	1	0	99					